


**C1 LIGHTING PLAN - LRG**  
1/4" = 1'-0"

LIGHTING LEGEND		
SYMBOL	DESCRIPTION	MTG HT AFF TO CL
LIGHTING FIXTURES		
[Symbol]	SURFACE MOUNTED LIGHTING FIXTURE	
[Symbol]	RECESSED LED TROFFER LIGHTING FIXTURE	
[Symbol]	SURFACE MOUNTED LED LIGHTING FIXTURE	
[Symbol]	RECESSED LED LIGHTING FIXTURE	
[Symbol]	WALL MOUNTED LIGHTING FIXTURE, SEE LIGHTING FIXTURE SCHEDULE	AS NOTED
[Symbol]	WALL MOUNTED EXIT SIGN, SHADE INDICATES FACES, PROVIDE CHEVRON DIRECTIONALS WHEN NEEDED	AS NOTED
[Symbol]	CEILING MTD EXIT SIGN, SHADING INDICATES FACES, PROVIDE W/ CHEVRON DIRECTIONALS WHEN NEEDED	AS NOTED
[Symbol]	COMBO EXIT WITH TWO LAMPHEADS	AS NOTED
[Symbol]	WALL MTD EMERGENCY BATTERY PACK LIGHTING FIXTURE	AS NOTED
[Symbol]	CEILING MTD EMERGENCY BATTERY PACK LIGHTING FIXTURE	AS NOTED
[Symbol]	FLUORESCENT STRIP LIGHTING FIXTURE	
[Symbol]	WALLWASHER TYPE RECESSED DOWNLIGHT, AIM LIGHT TOWARD WALL	
[Symbol]	RECESSED LIGHTING FIXTURE W/ EMERGENCY BATTERY PACK	AS NOTED
[Symbol]	PENDANT LIGHTING FIXTURE	AS NOTED
[Symbol]	LIGHTING TRACK WITH TRACK HEADS	

REFER TO SHEET E-003 FOR KEYNOTES

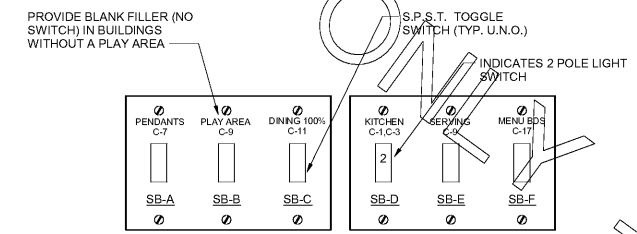

NOTE: LOCATE JUNCTION BOXES IN CEILING SPACE ABOVE THE LOCATION OF THE SWITCHBANK FOR SPLICING OF LINE, LOAD, AND SWITCHED CONDUCTORS. PROVIDE GANGED BACKBOX FOR SWITCHES AS REQUIRED AND LABEL ALL CONDUCTORS SO AS TO INDICATE THEIR USE (LINE, LOAD, SWITCH), THE LOAD SERVED, AND THE CIRCUIT NUMBER.

**A1 SWITCH BANK "SB" DETAIL**  
NO SCALE



**Chick-fil-A**  
5200 Buffington Road  
Atlanta, Georgia 30349-2998

**INTERPLAN**  
ARCHITECTURE  
ENGINEERING  
INTERIOR DESIGN  
PROJECT MANAGEMENT

604 COURTLAND STREET SUITE 100  
ORLANDO, FLORIDA 32804  
PH 407.645.5008  
FX 407.629.9124

SEAL:  
THIS DOCUMENT IS NOT FOR CONSTRUCTION  
UNLESS THE ARCHITECT'S OR ENGINEER'S  
SIGNATURE AND SEAL APPEAR BELOW.

**CHICK-FIL-A**  
**P12\_LS**  
SAR South Cobb Drive FSR  
3100 South Cobb Dr SE, Smyrna, GA 30080

**FSR# 00810**

REVISION		
NO.	DATE	DESCRIPTION
1	11.06.17	COORDINATION REV.
3	12.12.17	COORDINATION REVISIONS
4	12.18.17	CITY COMMENTS

CONSULTANT PROJECT # 2017.0165  
PRINTED FOR BID  
DATE September 06 2017  
DRAWN BY MI

Information contained on this drawing and to all rights there included for which no other project may be introduced in any manner without written or verbal consent from authorized project representative.

SHEET LIGHTING PLAN -LRG

**E-211L**

Order Plans @ WWW.BIDLINE.COM

2/5/2018 8:20 PM

COPYRIGHT © 2017 INTERPLAN, LLC. ALL RIGHTS RESERVED. THIS DOCUMENT IS THE ORIGINAL OR TRUE COPY WHICH HAS NOT BEEN REPRODUCED, CHANGED OR OTHERWISE INCORPORATED.