




Chick-fil-A
5200 Buffington Road
Atlanta, Georgia 30349-2998


INTERPLAN
ARCHITECTURE
ENGINEERING
INTERIOR DESIGN
PROJECT MANAGEMENT

604 COURTLAND STREET
SUITE 100
ORLANDO, FLORIDA 32804
PH 407.645.5008
FX 407.629.9124

SEAL:
THIS DOCUMENT IS NOT FOR CONSTRUCTION
UNLESS THE ARCHITECT OR ENGINEER
SIGNATURE AND SEAL APPEAR BELOW.

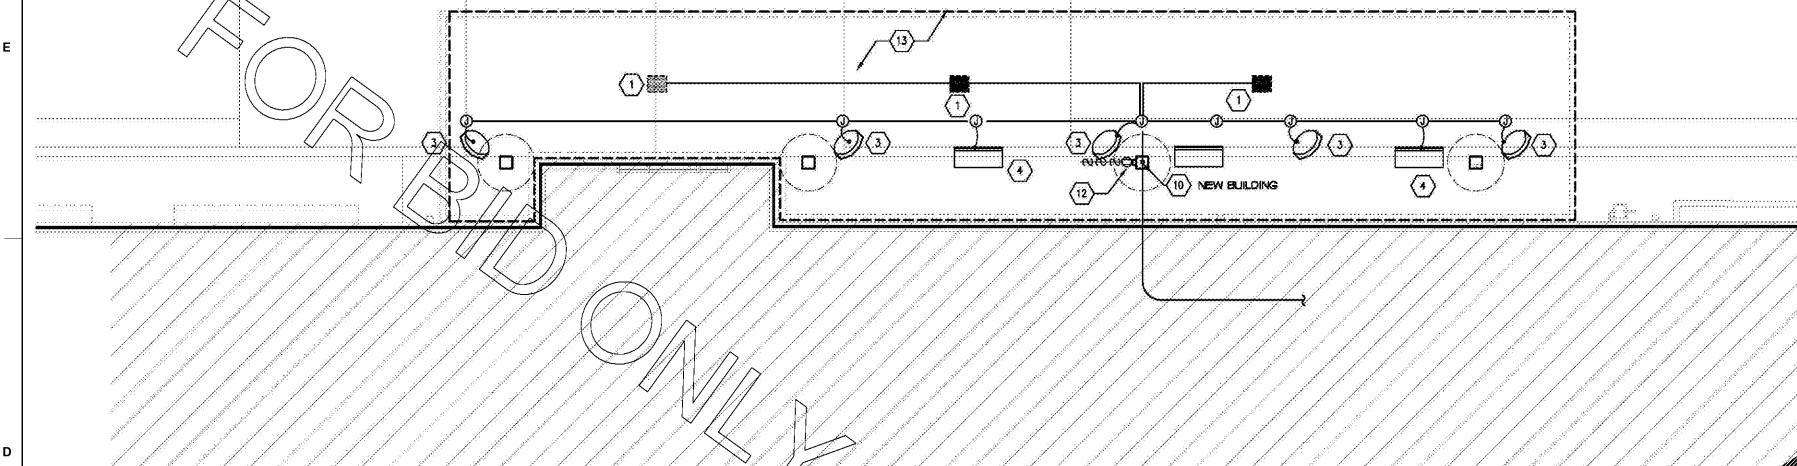


1 ELECTRICAL PLAN OMD CANOPY
1/8" = 1'-0"

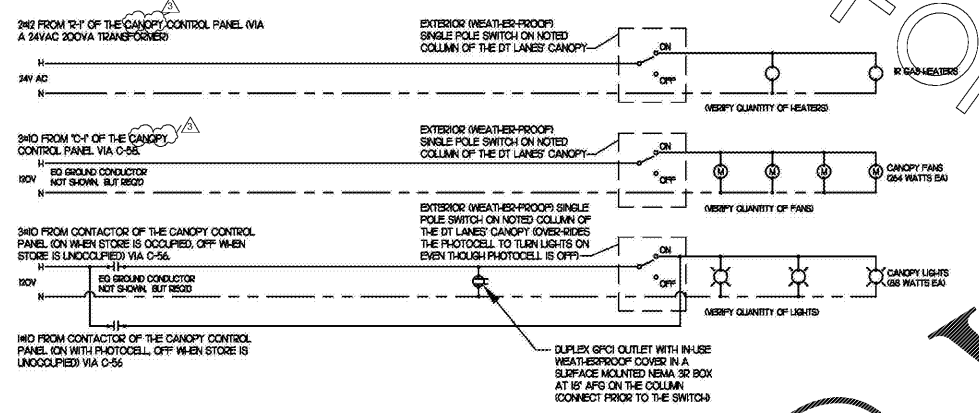


MEAL DELIVERY CANOPY CANOPY POWER WIRING SCHEMATIC
NO SCALE

- ELECTRICAL KEYNOTES NEW BUILDING:**
- CEILING LIGHT PROVIDED BY CANOPY SUPPLIER AND INSTALLED BY E.C.
 - NOT USED.
 - AIR CIRCULATING FAN WITH INTEGRAL ON-OFF SWITCH PROVIDED BY OTHERS.
 - INFRARED GAS HEATER WITH INTEGRAL ON-OFF SWITCH PROVIDED BY OTHERS.
 - THRU (2) NOT USED.
 - AT NEW BUILDINGS INSTALL UNDERGROUND 3" SCH40 PVC CONDUIT UP INTO THE CANOPY COLUMN WITH TYPE MC CABLE GALVANIZED STEEL WITH PVC JACKETED IN WITH IN FOR THE 20V POWER FOR LIGHTS, 120 VOLT POWER FOR FANS, AND 24 VOLT POWER FOR THE INFRARED GAS HEATERS.
 - NOT USED.
 - PROVIDE ONE DUPLEX GFCI WITH IN-HOUSE W/COVER PLATE AND ALUMINUM SWIMMING SWITCHES REACH WITH GFCI HANGES TO COVER PLEATED MOLDED CANOPY COLUMN IN FULLY FINISHED METAL SHELTER BOXES FOLLOWING THE CONTROL OF THE HEATERS AND FANS. SEE WIRING SCHEDULE AND CANOPY COLUMN DETAILS FOR PHOTOCELL INFORMATION. SURFACE MOUNTED ITEMS COVER PLATES TO BE FIELD PAINTED MATCH BUILDING.
 - ALL CONDUIT AND BOXES SHALL BE CONCEALED FROM NORMAL VIEW UNDERGROUND, IN COLUMNS, ABOVE THE CANOPY (ON THE ROOF), MC CABLE GALVANIZED STEEL WITH PVC JACKET TO BE USED IN THE COLUMNS, BUT MUST CONVERT BACK TO IMC ABOVE THE ROOF. REFER TO THE MECHANICAL DRAWINGS FOR DETAILS OF MOUNTING CONDUIT ON THE ROOF OF THE CANOPY. ALL EXPOSED ELECTRICAL BOXES TO BE NEMA 3R CAST-METAL.

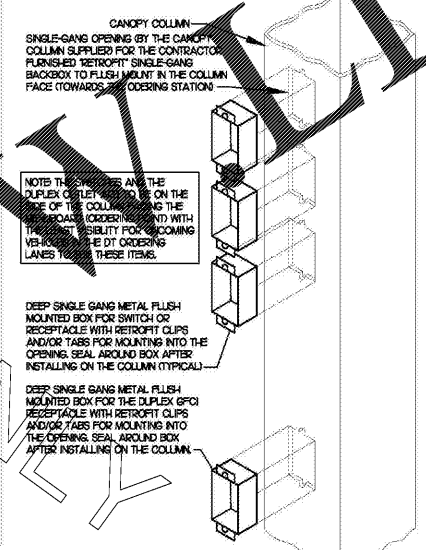

CANOPY COLUMN ISOMETRIC
NOT TO SCALE

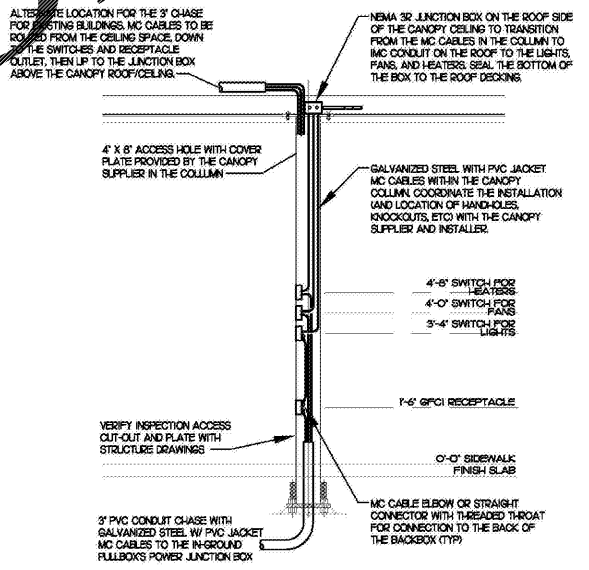

SECTION - CANOPY COLUMN
NOT TO SCALE

CHICK-FIL-A
P12_LS
SAR South Cobb Drive FSR
3100 South Cobb Dr SE, Smyrna, GA 30080

FSR# 00810

NO.	DATE	DESCRIPTION
3	12.12.17	COORDINATION REVISIONS

CONSULTANT PROJECT # 2017.0165
PRINTED FOR BID
DATE September 06 2017
DRAWN BY MI

SHEET ELECTRICAL PLAN OMD CANOPY
SHEET NUMBER

E-223

2/5/2018 8:45 PM

Order Plans @

FOR BID ONLY