



Chick-fil-A
 5200 Buffington Road
 Atlanta, Georgia 30349-2998

INTERPLAN
 ARCHITECTURE
 ENGINEERING
 INTERIOR DESIGN
 PROJECT MANAGEMENT

604 COURTLAND STREET
 SUITE 100
 ORLANDO, FLORIDA 32804
 PH 407.645.5008
 FX 407.629.9124

SEAL:
 THE ARCHITECT IS NOT FOR CONSTRUCTION
 UNLESS THE ARCHITECT OR ENGINEER
 SIGNATURE AND SEAL APPEAR BELOW

CHICK-FIL-A
 P12_LS
 SAR South Cobb Drive FSR
 3100 South Cobb Dr SE, Smyrna, GA 30080


FSR# 00810

REVISION SCHEDULE		
NO.	DATE	DESCRIPTION

CONSULTANT PROJECT # 2017.0165
 PRINTED FOR BID
 DATE September 06, 2017
 DRAWN BY MI

Information contained on this drawing and in all digital files
 provided for digital transfer under this title shall be restricted to
 any manner without express written or verbal consent from
 authorized project representatives.
 SHEET # ROOF POWER PLAN -LRG

SHEET NUMBER
E-250L

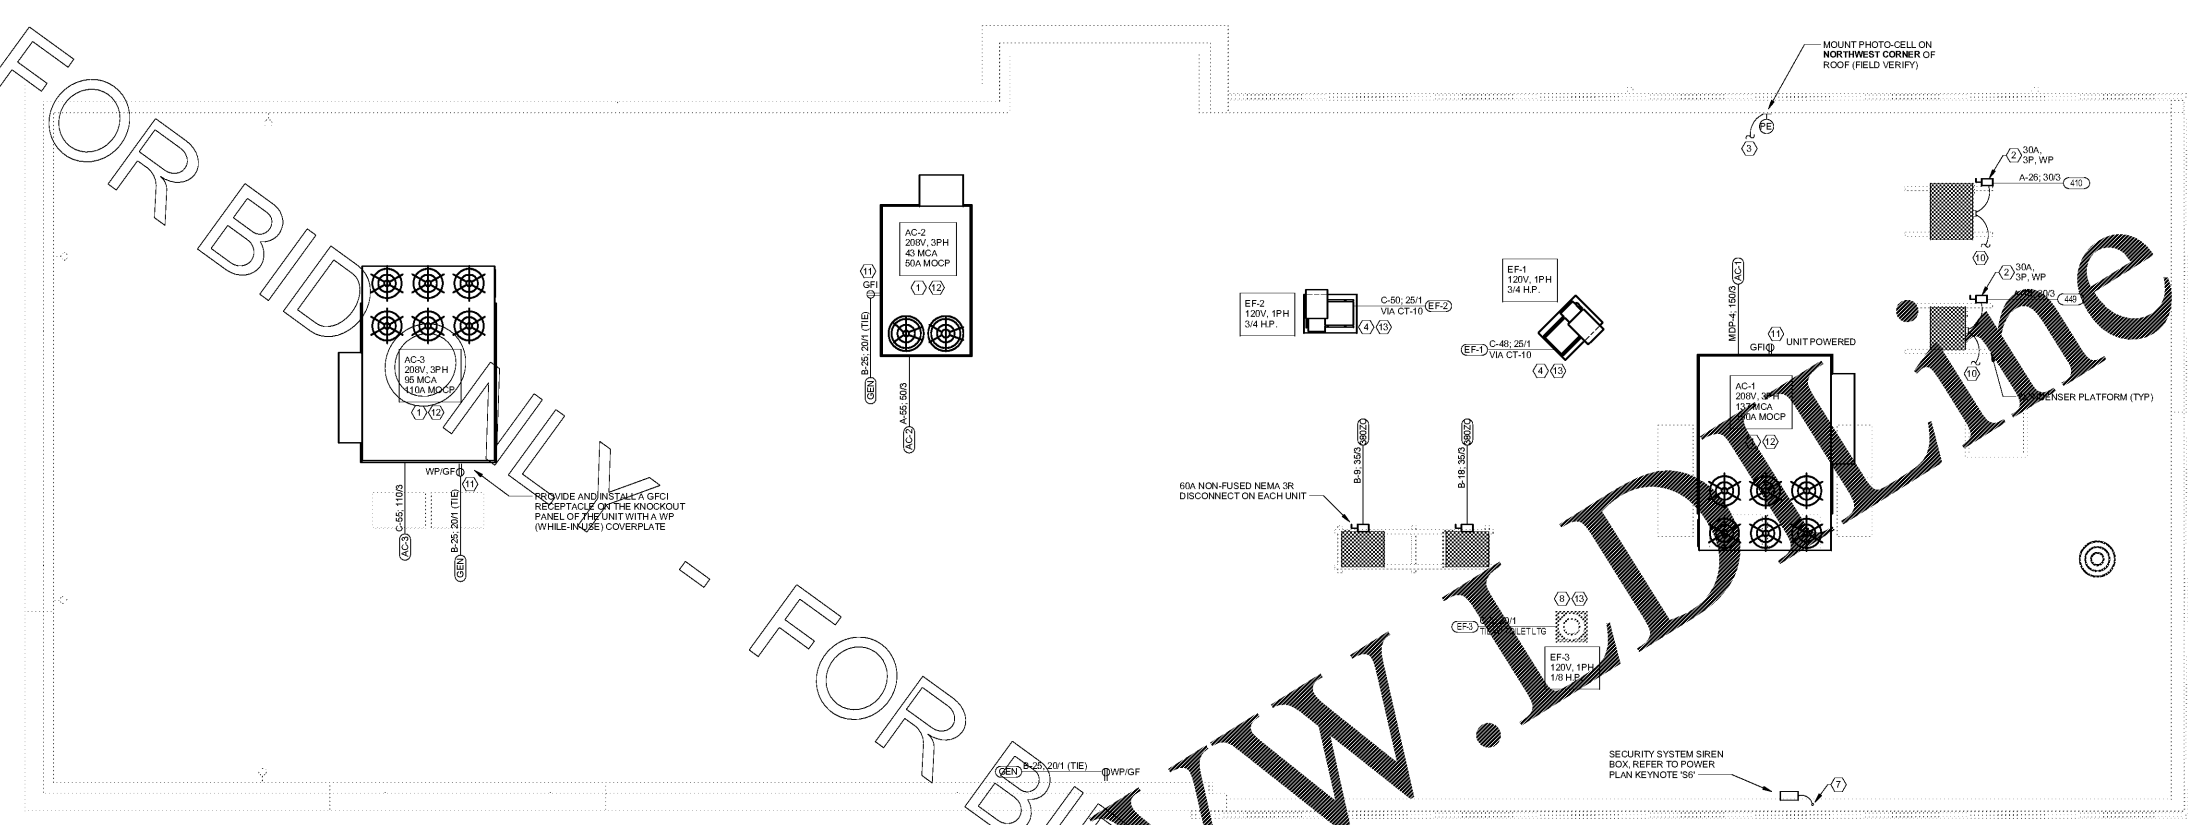

C1 ROOF POWER PLAN LRG
 1/4" = 1'-0"

NOTE: REFER TO MECHANICAL DRAWINGS FOR ROOF TOP
 PACKAGED AC UNIT SCHEDULE. ALL UNITS ARE FURNISHED
 WITH FACTORY INSTALLED DISCONNECT SWITCH. REFER
 TO SAME SCHEDULE FOR INDICATION OF UNITS FURNISHED
 WITH FACTORY RECEPTACLE FOR COMPLIANCE WITH NEC
 210-63.

REFER TO
 SHEET E-003
 FOR KEYNOTES

2/5/2018 8:49 PM

COPYRIGHT © 2017 INTERPLAN, LLC. REPEATS COPYRIGHT & OTHER RESTRICTIONS FROM DOCUMENTS TO THE ORIGINAL SET OF PAPERS FOR WHICH THEY WERE PREPARED. REPRODUCTIONS, CHANGES OR ADJUSTMENTS ARE PROHIBITED.