



Chick-fil-A
5200 Buffington Road
Atlanta, Georgia 30349-2998

INTERPLAN
ARCHITECTURE
ENGINEERING
INTERIOR DESIGN
PROJECT MANAGEMENT

604 COURTLAND STREET SUITE 100
ORLANDO, FLORIDA 32804
PH 407.645.5008
FX 407.629.9124

SEAL THIS DOCUMENT IS NOT FOR CONSTRUCTION UNLESS THE ARCHITECT OR ENGINEER SIGNATURE AND SEAL APPEAR BELOW.

CHICK-FIL-A
P12_LS

SAR South Cobb Drive FSR
3100 South Cobb Dr SE, Smyrna, GA 30080

FSR# 00810


NO.	DATE	DESCRIPTION
3	12.12.17	COORDINATION REVISIONS
5	12.27.17	OWNER REVISIONS

CONSULTANT PROJECT # 2017.0165
PRINTED FOR BID
DATE September 06 2017
DRAWN BY MI

Information contained on this drawing and in all digital files produced for this project shall be the property of the architect and shall not be reproduced, stored in a retrieval system, or transmitted in any manner without express written or verbal consent from the architect's project representative.
SHEET ENLARGED KITCHEN POWER PLAN
SHEET NUMBER

BID

E-301

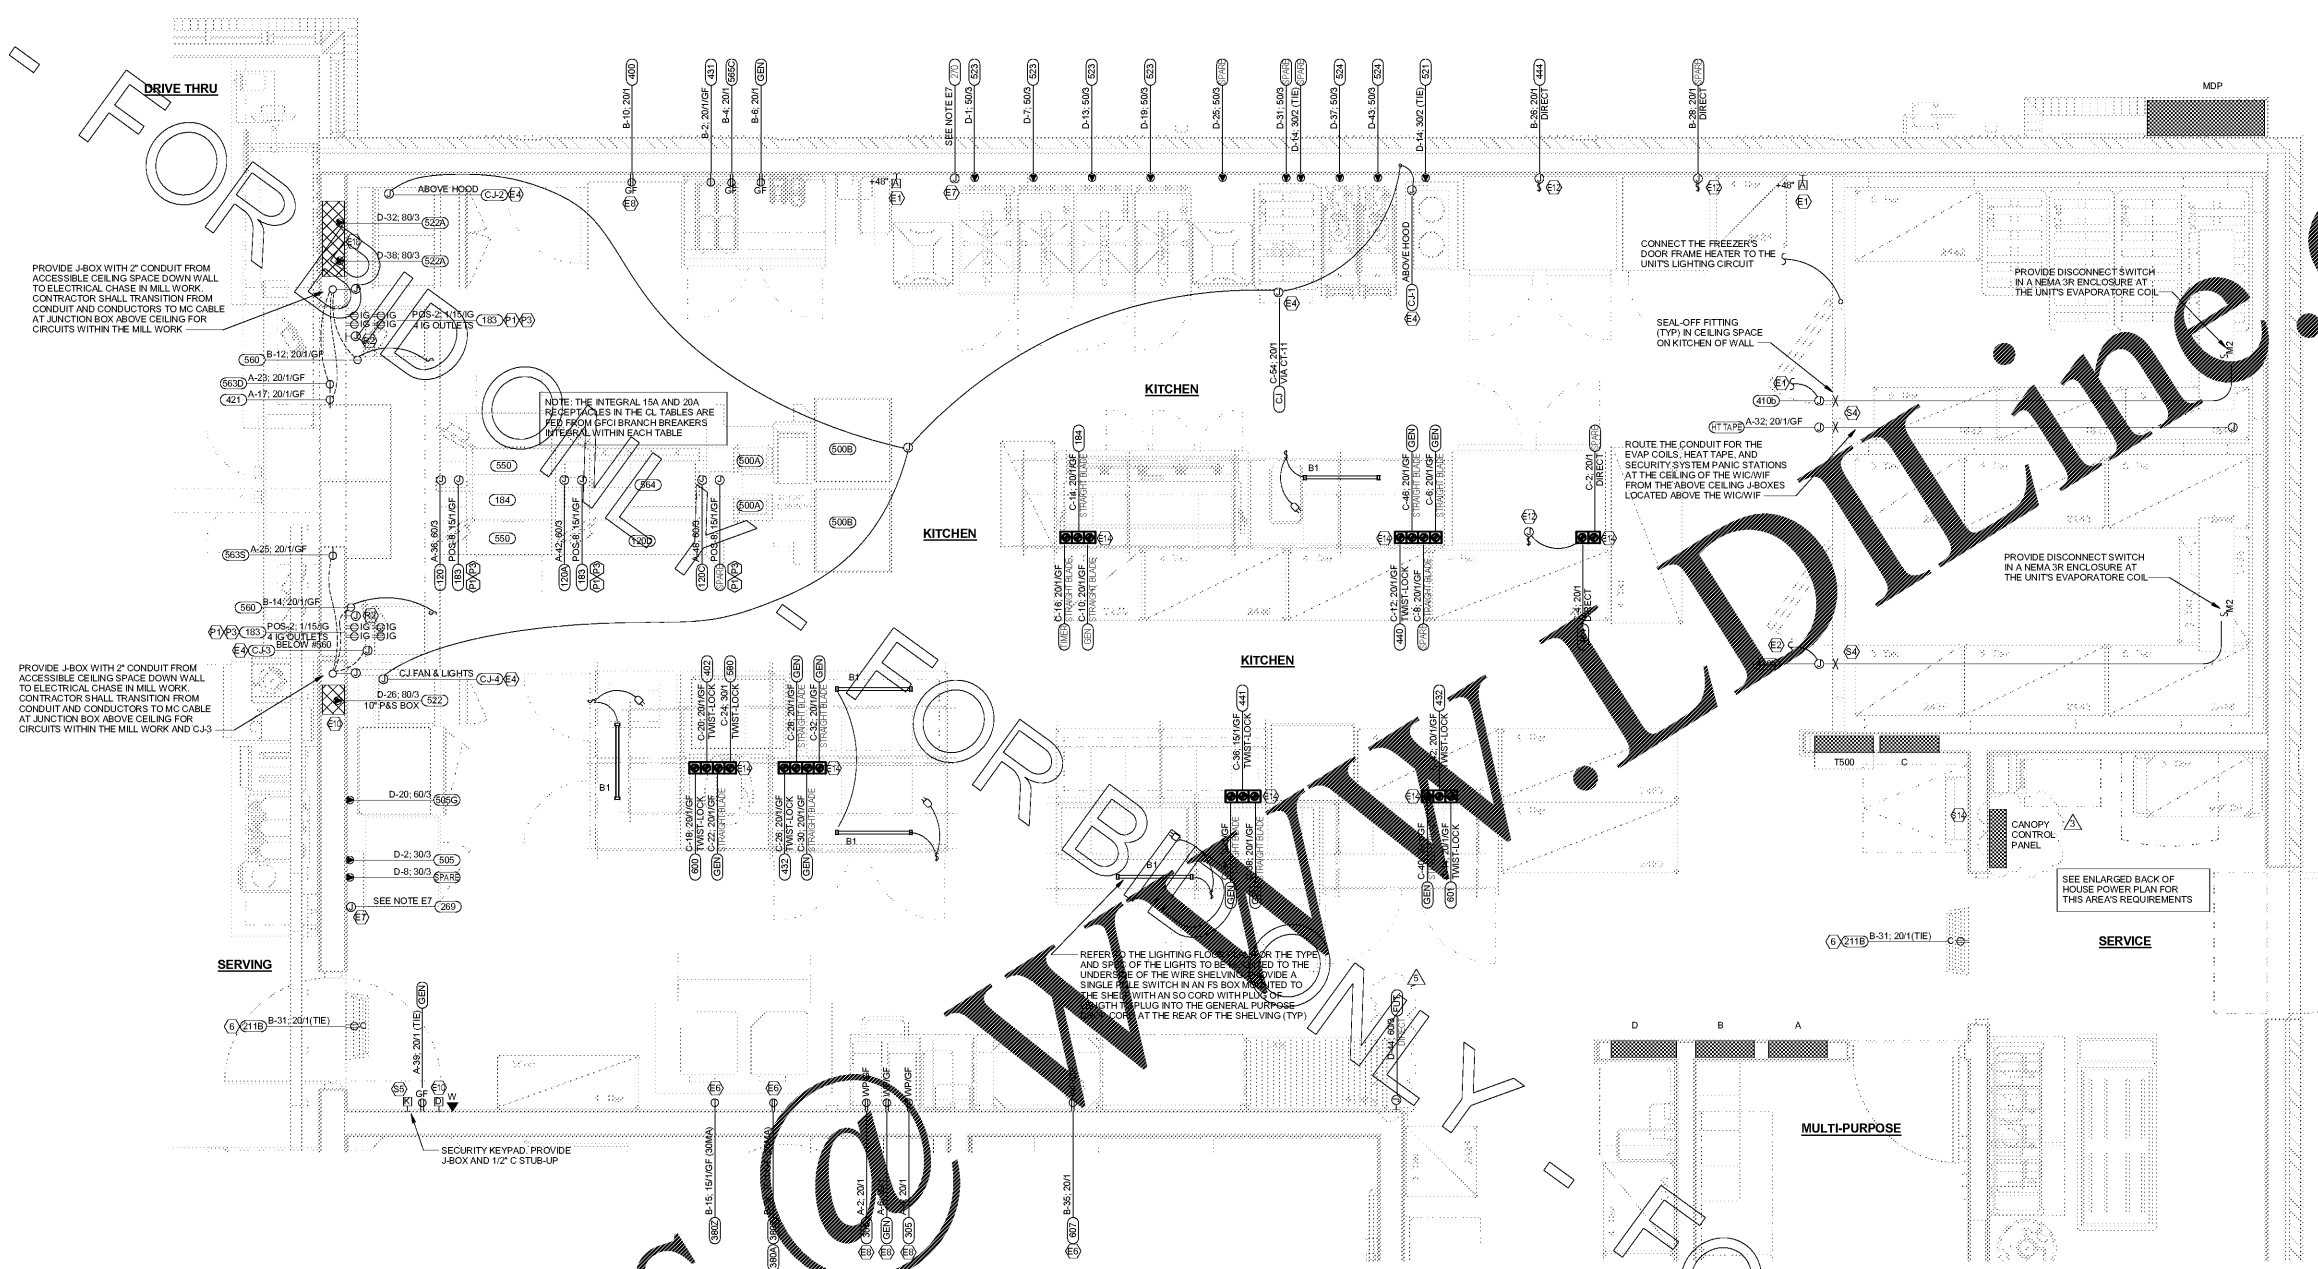

Order Plans

2/5/2018 8:55 PM

FOR BID ONLY

FOR BIDDING

FOR BIDDING

FOR BIDDING

C1 ENLARGED KITCHEN POWER PLAN

1/2" = 1'-0"

NOTE:
RECEPTACLES FOR THE POS EQUIPMENT SHALL BE THE ONLY ITEMS THAT CONNECT TO THIS ISOLATED GROUND PANEL AND IF SO, SHALL BE REMOVED AND RECONNECTED TO ANOTHER PANELBOARD AT THE EXPENSE OF THE CONTRACTOR.

NOTE FOR POS GF IN KITCHEN:
THE CONTRACTOR SHALL PROVIDE GROUND FAULT PROTECTION FOR ALL 120 VOLT, 15 AND 20 AMP ISOLATED GROUND RECEPTACLE OUTLET BRANCH CIRCUITS IN THE KITCHEN/FOOD PREPARATION AREAS. GROUND FAULT PROTECTION SHALL BE PROVIDED AT THE RECEPTACLE VIA A GROUND FAULT TYPE BRANCH BREAKER (GFCI) UNLESS OTHERWISE NOTED ON THIS PLAN. REFER TO THE CONDUIT AND CONDUCTOR SCHEDULE FOR ADDITIONAL INFORMATION.

REFER TO SHEET E-003 FOR KEYNOTES

1A KITCHEN EQUIP NOMENCLATURE
NO SCALE

XX X-XX AMP/POLE

KITCHEN EQUIPMENT MARK NUMBER-SEE SCHEDULE FOR REQUIREMENTS
PANEL AND CIRCUIT NUMBER
BRANCH BREAKER SIZE (AMP/POLES), REFER TO THE CONDUIT AND CONDUCTOR SCHEDULE FOR WIRE AND CONDUIT SIZE RELATED TO THE BREAKER (VERIFY)

REFER TO THE KITCHEN ELEVATIONS FOR THE ROUGH-IN HEIGHT

BID

E-301