


Order Plans @

WWW.DLINE.COM

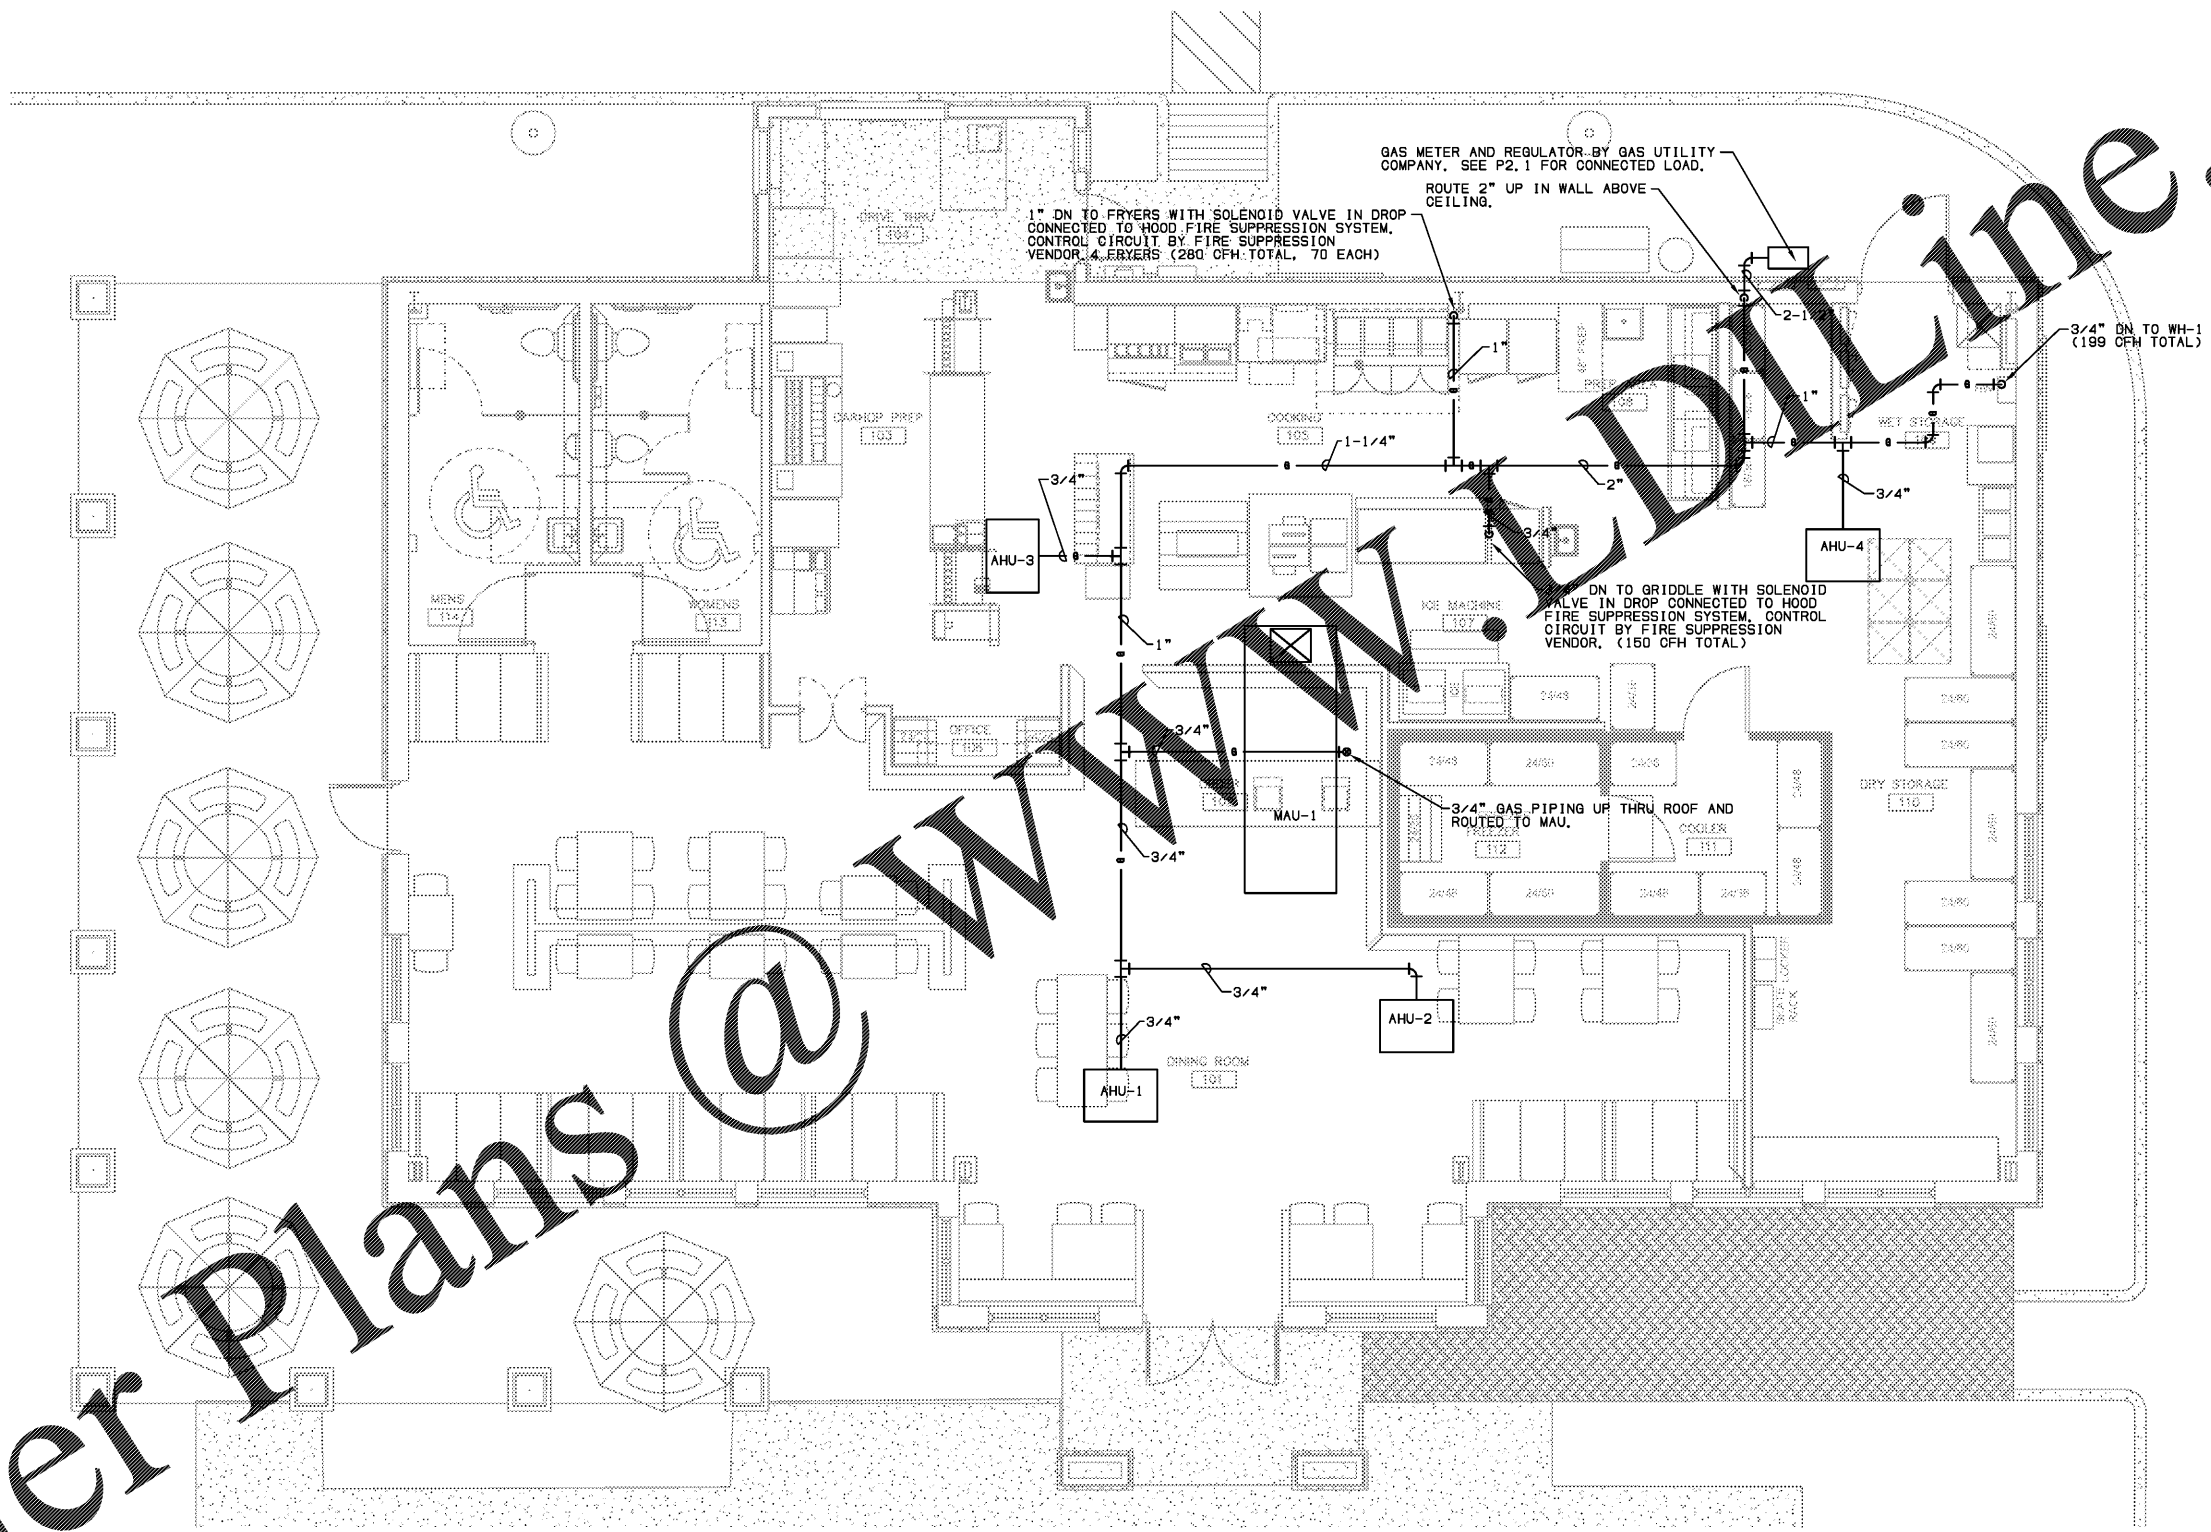

1 FLOOR PLAN - GAS PIPING
1/4" = 1' - 0"



STORE #6679

6808 SIEGEN LANE
BATON ROUGE, LA 70809

PROJ. NO.: 1722
DATE: 01/22/2018

SHEET TITLE:
FLOOR PLAN -
PLUMBING AND
MECHANICAL

DRAWING SHEET IS FULL SIZE AT 22" x 34"
REDUCED 11" x 17" SHEET IS HALF SIZE

SHEET NO.:

MEP1.01