


Order Plans

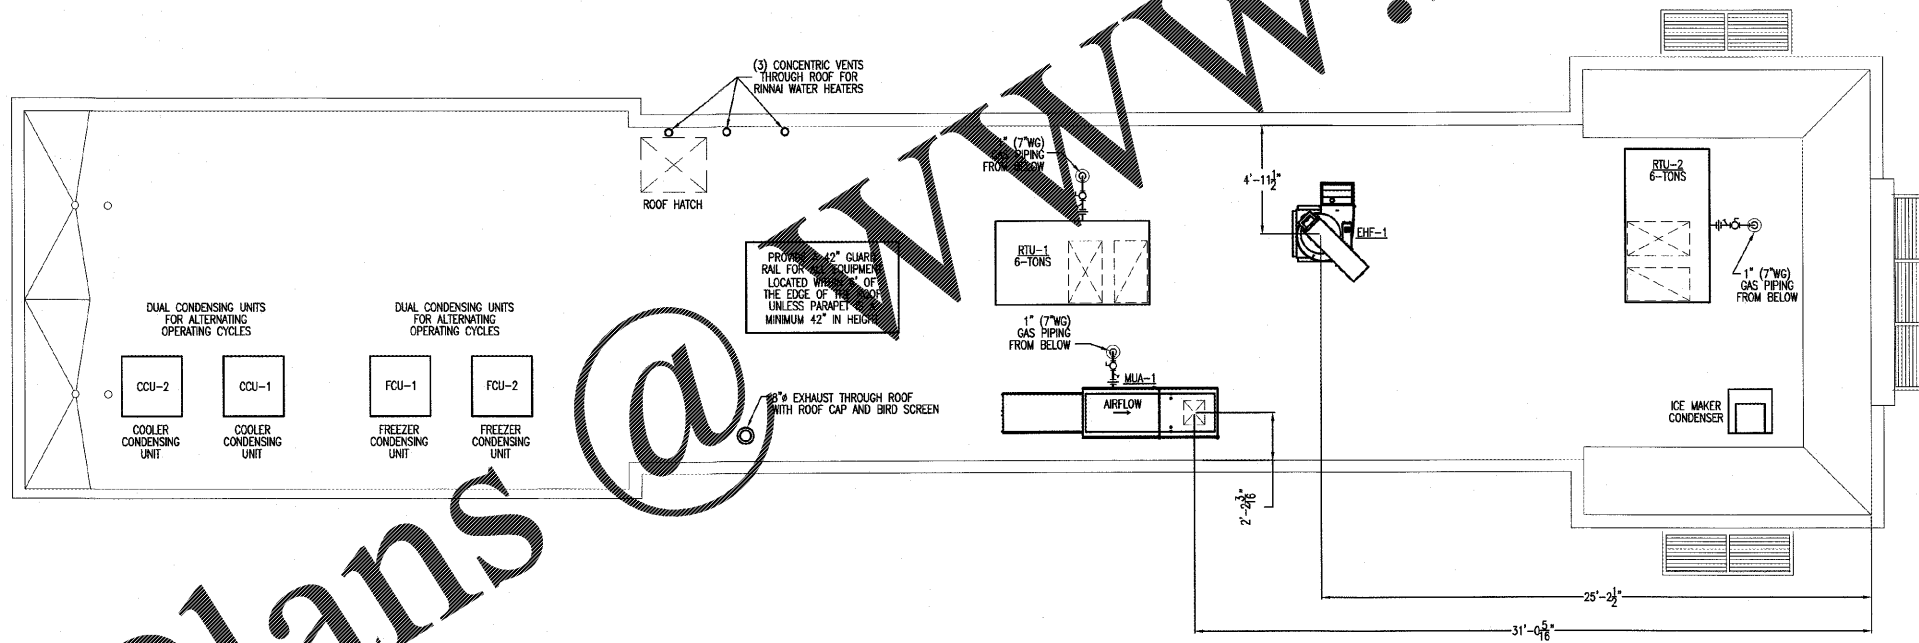

ROOF MECHANICAL PLAN  
SCALE: 1/4" = 1'-0"

Copyright © 2018 Alamance Consulting Engineers, P.A. All Rights Reserved. No part of these plans may be copied, reproduced or reused in any way without the express written permission of Alamance Consulting Engineers, P.A.

**Alamance Consulting Engineers**  
961-F Burlington Ave.  
Gibsonville, N.C. 27249  
Phone: (336) 449-4558  
www.ace-nc.net  
N.C. Firm License Number C-2071

**LINDSEY ARCHITECTURE**  
125 S. Elm Street, Suite 300  
Greensboro, NC 27401  
p. 336.617.4402  
f. 336.617.4434  
www.lindseyarchitecture.com

NEW BUILDING FACILITY:  
**COOK OUT**  
601 West 3rd St.  
Pembroke, North Carolina

DRAWING NAME:  
ROOF MECHANICAL PLAN

PROFESSIONAL SEAL  
NORTH CAROLINA PROFESSIONAL ENGINEER  
SEAL 25043  
G. KEVIN BENNETT  
1/17/18

DRAWN: MRS  
CHECKED: MK  
DATE: 1/17/18  
SCALE: AS NOTED  
JOB NO.: 17116  
SHEET:

M-3