


WIRING NOTES:  
 -MOUNT CONTACTOR SWITCH IN EVAPORATOR CONTROL WIRING AREA  
 -DO NOT MOUNT TO DRAIN PAN  
 -SWITCH IS ONLY BREAKING THE NEUTRAL LINE  
 Δ - CONTROL WIRES FROM CONDENSER UNIT TIME CLOCK  
 — LINE WIRE  
 - - CONTROL WIRE

WIRING FOR ALTERNATING THE COOLER/  
 FREEZER EVAPORATOR FAN COIL OPERATION

2  
 E-3 SCALE: N.T.S.

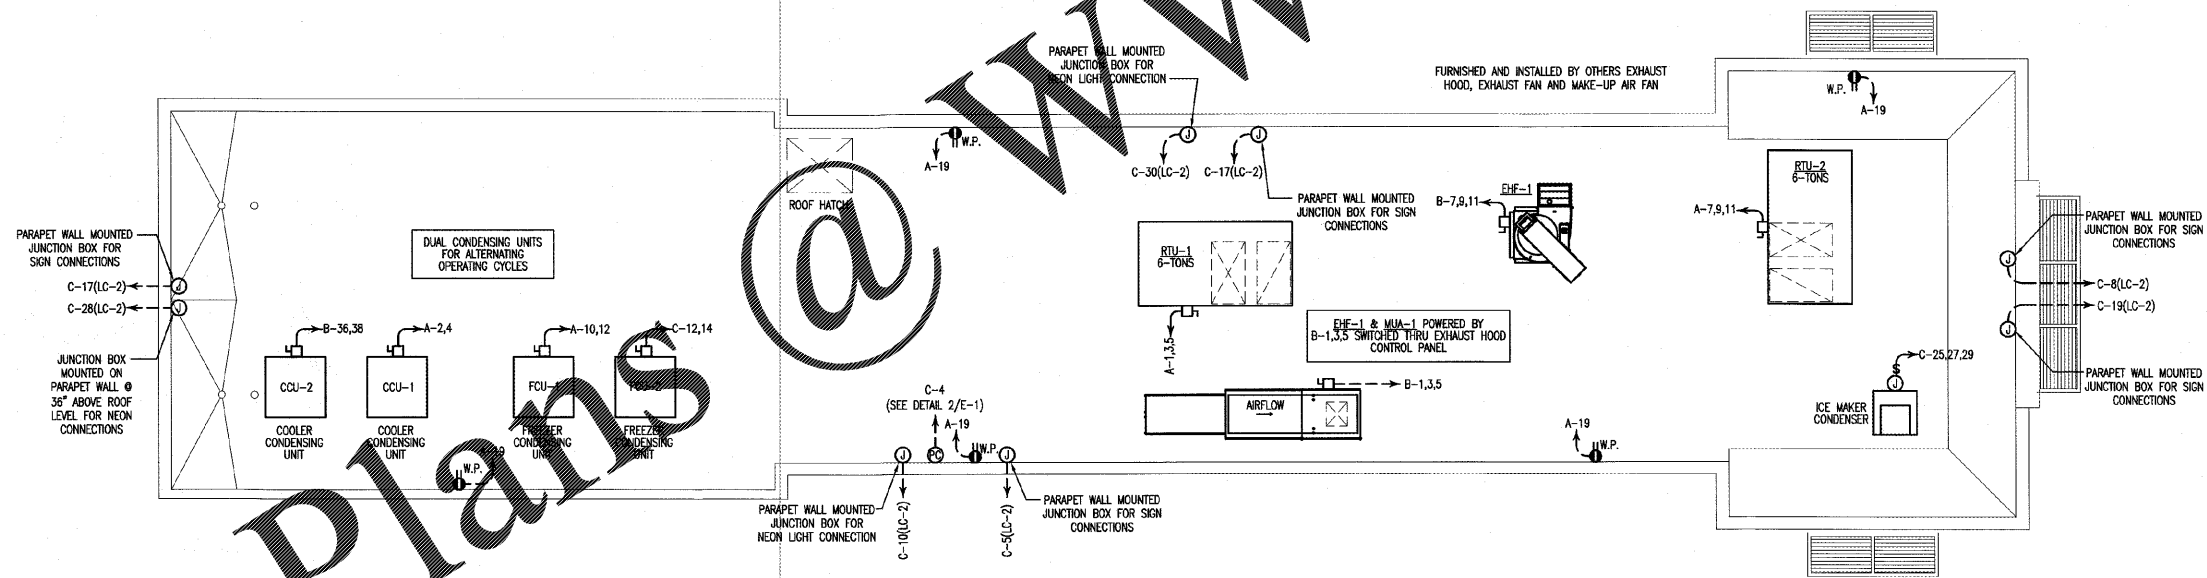

ROOF  
 ELECTRICAL PLAN  
 1  
 E-3 SCALE: 1/4"=1'-0"

Copyright © 2018 Alomance Consulting Engineers, P.A. All Rights Reserved. No part of these plans may be copied, reproduced or used in any way without the express written permission of Alomance Consulting Engineers, P.A.



**Alomance Consulting Engineers**

961-F Burlington Ave.  
 Gibsonville, N.C. 27249  
 Phone: (336) 449-4558  
 www.ace-nc.net


N.C. Firm License Number C-2071



**Lindsay Architecture**  
 125 S. Elm Street, Suite 300  
 Greensboro, NC 27401  
 p. 336.617.4402  
 f. 336.617.4434  
 www.lindsayarchitecture.com

NEW BUILDING FACILITY:  
**COOK OUT**  
 601 West 3rd St.  
 Pembroke, North Carolina

DRAWING NAME  
 ROOF  
 ELECTRICAL PLAN

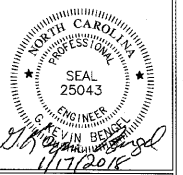

DRAWN  
 MRS  
 CHECKED  
 DATE  
 11/7/18  
 SCALE  
 AS NOTED  
 JOB NO.  
 17116  
 SHEET

E-3