



Alamance Consulting Engineers


961-F Burlington Ave.
Gibsonville, N.C. 27249
Phone: (336) 449-4558
www.ace-nc.net
N.C. Firm License Number C-2071



Lindsay Architecture
125 S. Elm Street, Suite 300
Greensboro, NC 27401
p. 336.617.4402
f. 336.617.4434
www.lindsayarchitecture.com

NEW BUILDING FACILITY:
COOK OUT
601 West 3rd St.
Pembroke, North Carolina



DRAWING NAME:
PLUMBING PLAN

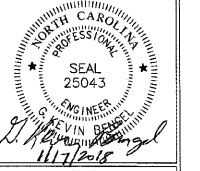

DRAWN:
MRS. [Signature]
DATE: 11/7/18
SCALE: AS NOTED
JOB NO.: 17116
SHEET:

P-1

EQUIPMENT SCHEDULE	
NO.	DESCRIPTION
1	CAN WASH AREA
2	DRY STORAGE SHELVING RACKS
3	WALL MOUNTED HAND SINKS
4	DRY STORAGE SHELVING RACKS (WALK INS)
5	WALK IN FREEZER
6	(4) COMP. SINK
7	(2) DRAWER SANDWICH PREP UNIT
8	CHAR. GRILL W/ STAND (ON CASTERS)
9	GRIDDLE W/ STAND (ON CASTERS)
10	35 LB. FRYERS (ON CASTERS)
11	HOOD W/ EXHAUST SYSTEM AND ANSUL SYSTEM
12	WALK IN COOLER
13	CARBONATED BEVERAGE MACHINE W/ ICE BIN
14	STAINLESS STEEL WORK TABLE
15	ICE MAKER W/ BIN
16	STAINLESS STEEL SPLASH GUARDS
17	(2) DOOR SANDWICH/ SALAD PREP. UNIT (ON CASTERS)
18	MILK SHAKE MACHINE (ON CASTERS)
19	STAINLESS STEEL WORK TABLE
20	STAINLESS STEEL WORK TABLE
21	TEA DISPENSERS
22	STAINLESS STEEL WORK TABLE
23	BUN WARMER
24	STEAM TABLE (ON CASTERS)
25	(2) DOOR SANDWICH/ SALAD PREP. UNIT (ON CASTERS)
26	PREP. SINK
28	(4) DRAWER UNDER COUNTER REFRIGERATOR
29	STAINLESS STEEL WORK TABLE
30	STAINLESS STEEL WORK TABLE
31	DRINK MIXERS
32	UPRIGHT REFRIGERATOR

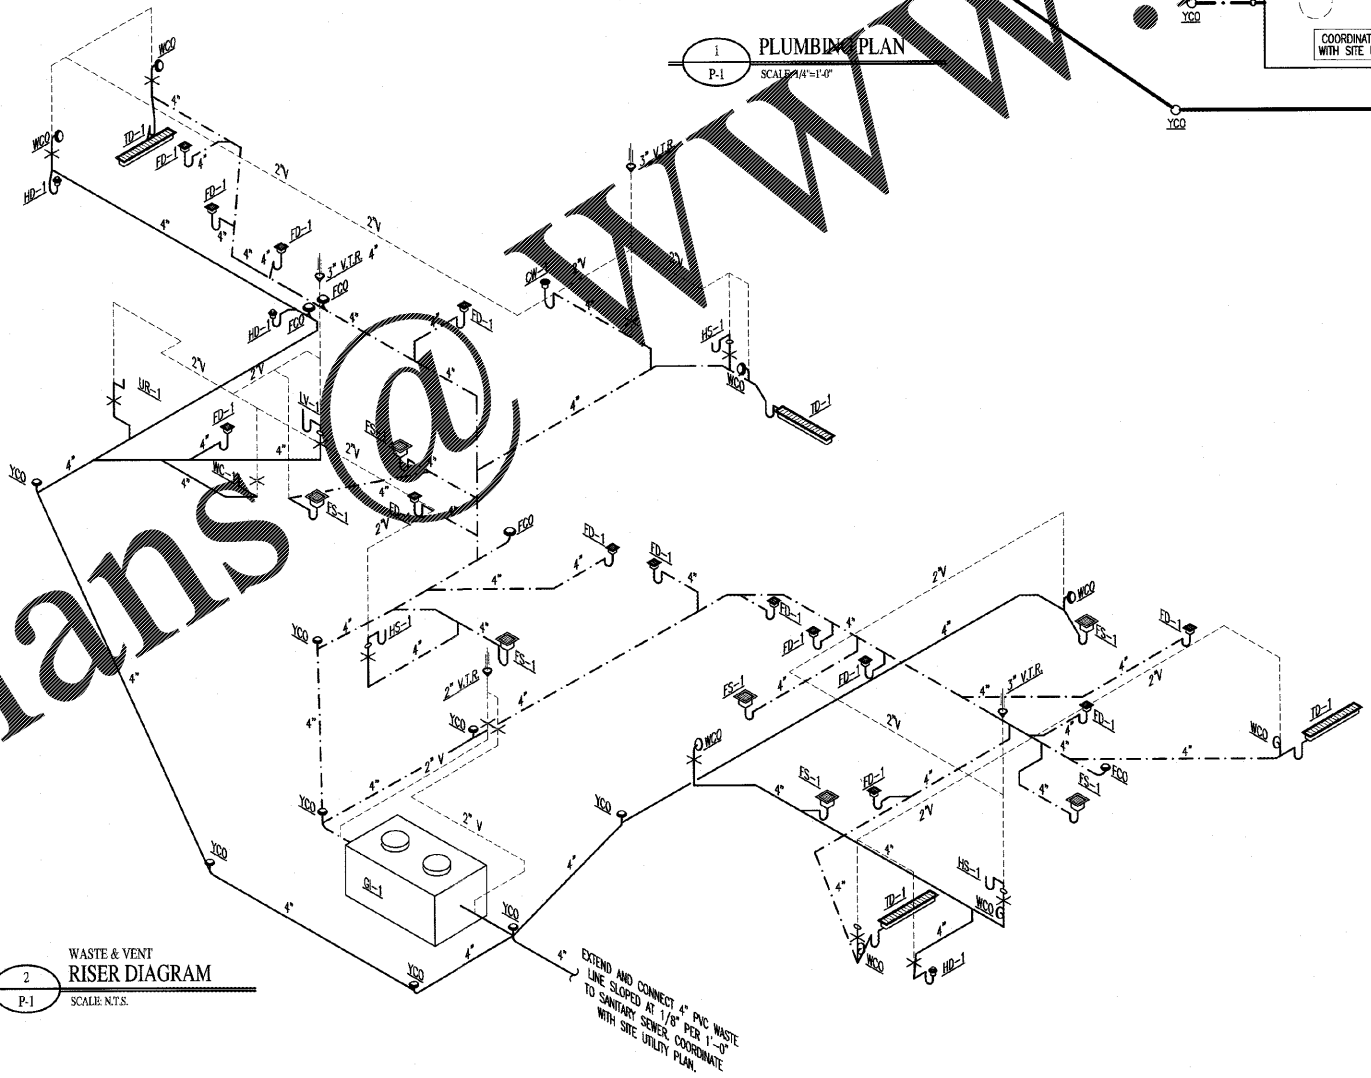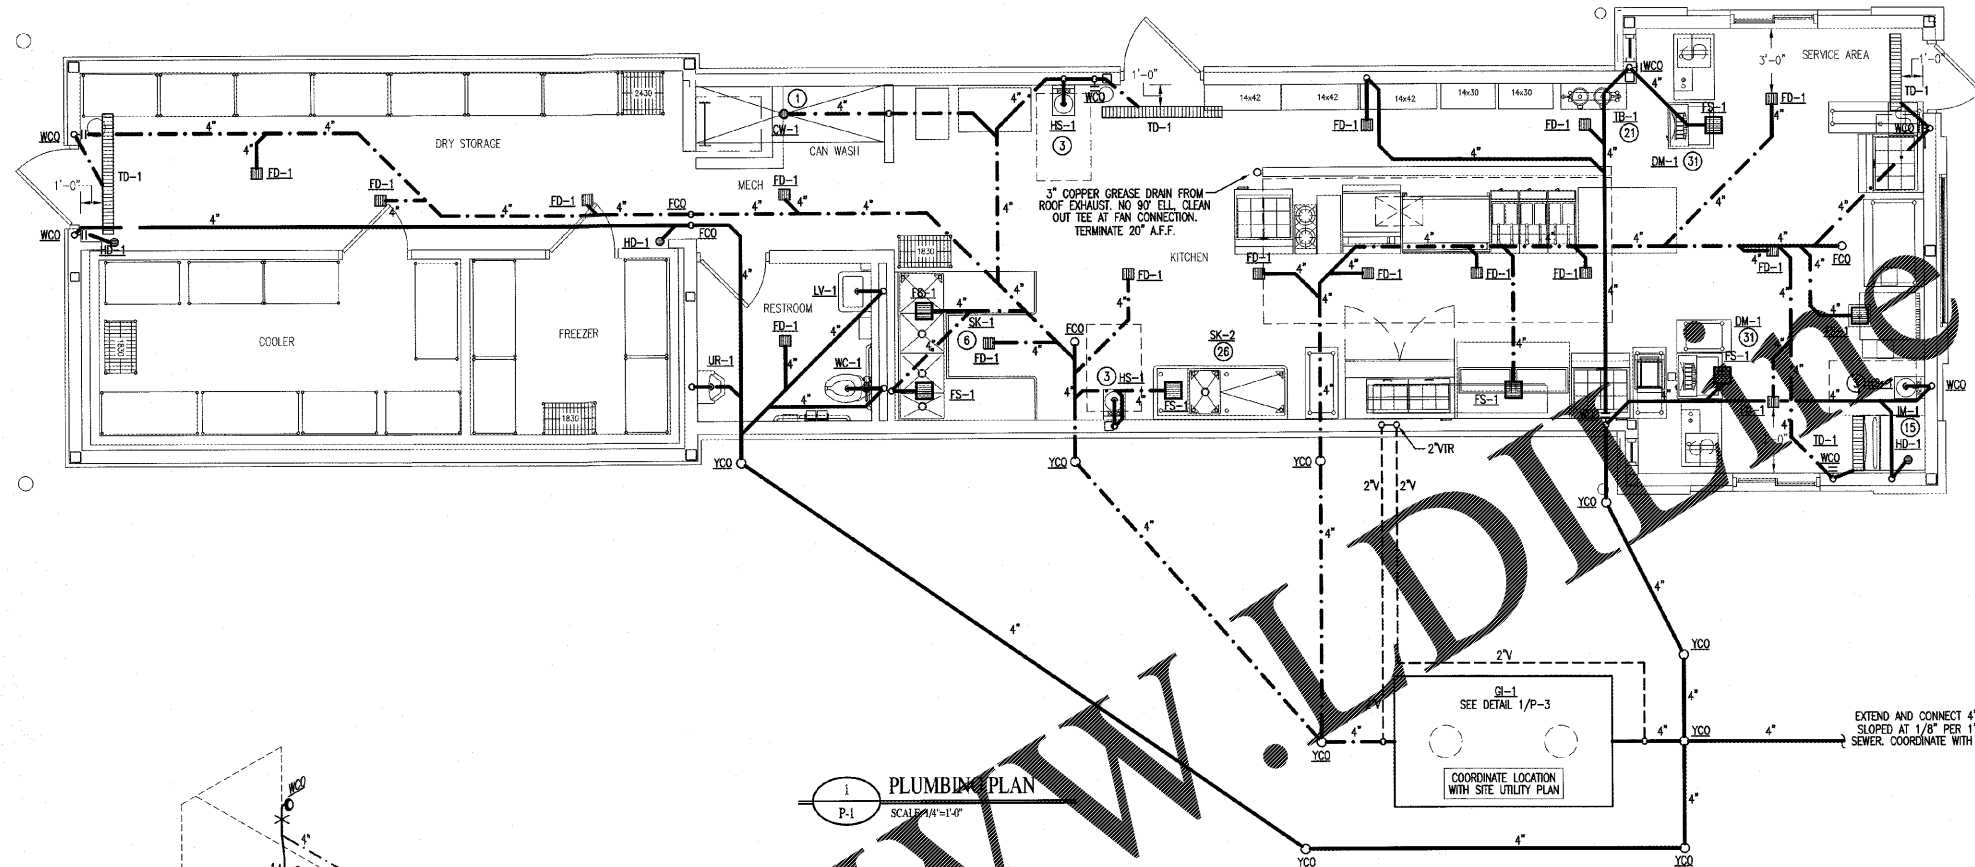

PIPING LEGEND	
SYMBOL	DESCRIPTION
	SEWER PIPING
	GREASE PIPING
	VENT PIPING

WASTE & VENT RISER DIAGRAM
SCALE: N.T.S.

PLUMBING PLAN
SCALE: 1/4" = 1'-0"

EXTEND AND CONNECT 4" PVC WASTE LINE SLOPED AT 1/8" PER 1'-0" TO SANITARY SEWER. COORDINATE WITH SITE UTILITY PLAN.

GL-1
SEE DETAIL 1/P-3
COORDINATE LOCATION WITH SITE UTILITY PLAN

EXTEND AND CONNECT 4" PVC WASTE LINE SLOPED AT 1/8" PER 1'-0" TO SANITARY SEWER. COORDINATE WITH SITE UTILITY PLAN.

Order Plans @ www.wldplans.com