



1 PLUMBING PLAN - ABOVE FLOOR
P2.1
1" = 1'-0"

2 WATER RISER DIAGRAM
P2.1
N.T.S.

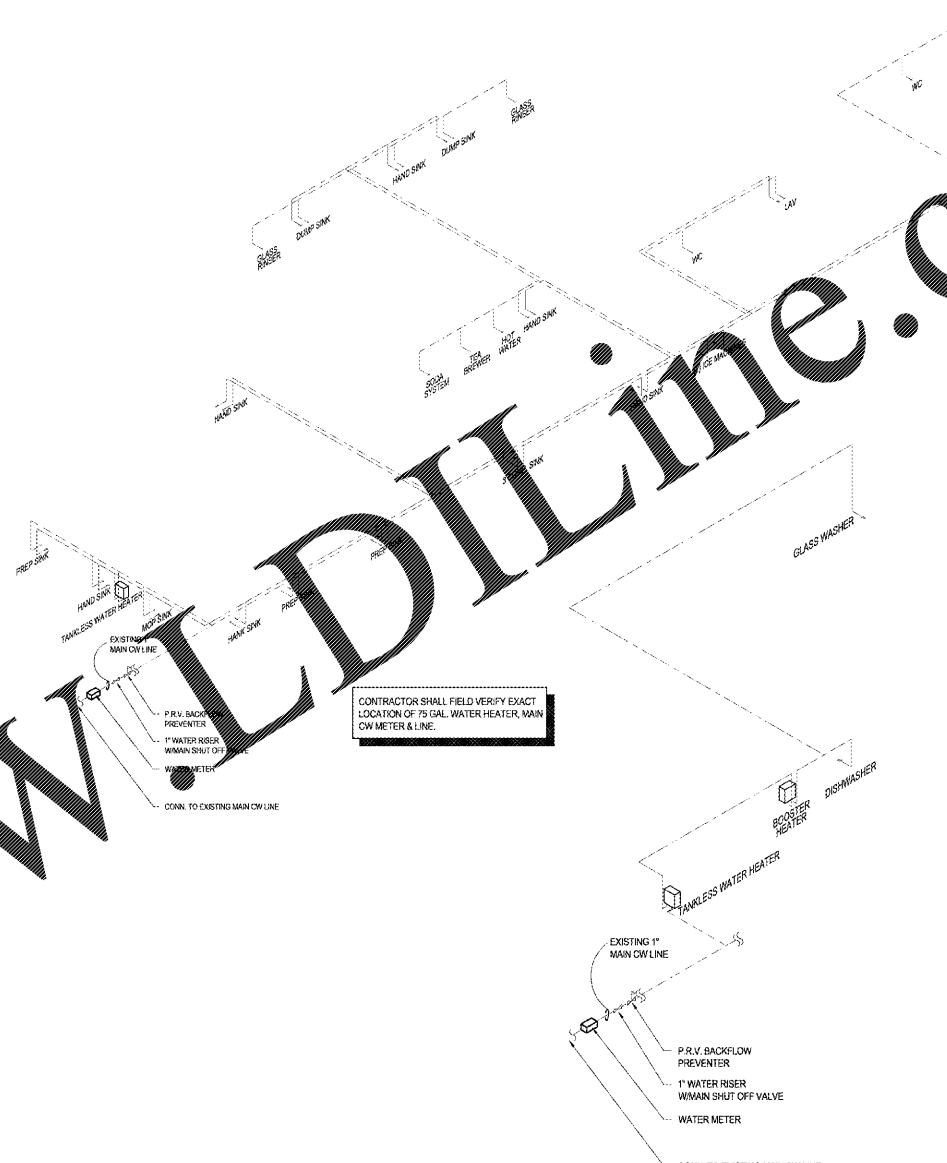

3 GAS RISER DIAGRAM
P2.1
N.T.S.

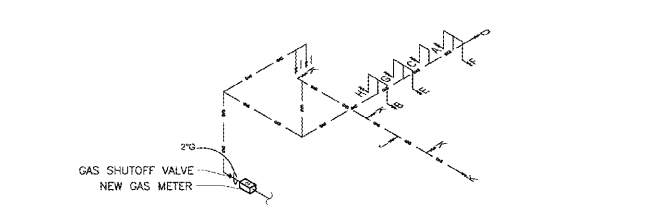

LEGENDS

○	COLD WATER	CW	COLD WATER
○	HOT WATER	FW	FLOOR CLEAN OUT
○	HUB DRAIN	FD	FLOOR DRAIN
○	FLOOR DRAIN	FS	FLOOR SINK
○	VENT STACK PIPE	HD	HUB DRAIN
○	FLOOR CLEAN OUT	HW	HOT WATER
○	WALL CLEAN OUT	VT	VENT
○	FLOOR SINK - PARTIAL GRATE	WH	WATER HEATER
○	COLD WATER LINE	WOD	WALL CLEAN OUT
○	HOT WATER LINE		
○	SANITARY LINE		
○	GREASE WASTE LINE		
○	GAS LINE		

ABBREVIATIONS

GAS LOAD

HEATING	415.0
WH	473.0
COOKING	675.0
TOTAL	1,563.0

* NOTE: 2LB PRESSURE CAPACITY OF PIPES AND PUT REGULATOR TO EACH APPLIANCE.

EQUIPMENT

MARK	DESCRIPTION	BTUH	INLET Ø
A	FRYER	140,000	3/4"
B	RANGE SPREADER	125,000	1 1/4"
C	FRANKIA	225,000	1 1/4"
D	CHEESEMELTER	20,000	3/4"
E	BROILER	135,000	1 1/4"
F	SPREADER	60,000	1 1/4"
G	PASTA COOKER	140,000	3/4"
H	RANGE, 6 BURNER	225,000	1 1/4"
I	TANKLESS WATER HEATER	190,000	3/4"
J	ROOF TOP UNIT	100,000	1/2"
K	FURNACE A	80,000	1/2"

LAPEER
ALPHARETTA, GEORGIA
PLUMBING PLAN & DIAGRAMS

M. Christopher Baldwin, Architect
6017 Sandy Springs Circle
Sandy Springs, Georgia 30328
(404) 406-9041

Copyright Ownership
This drawing is the property of M-CINEERS, LLC, and may not be used, copied, or revised without expressed written permission.

Revision

No.	Date	By

DATE 04/03/2018
DRAWN CC
CHECKED SCH

JOB NO.

SHEET NO.
P2.1