
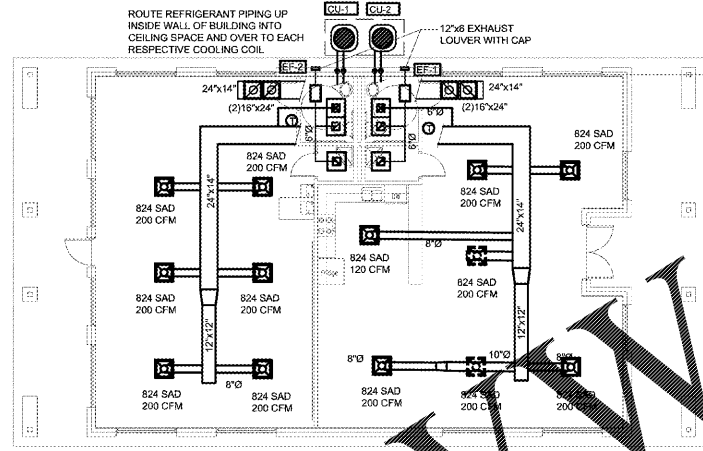


Order Plans @ [www.LDILine.com](http://www.LDILine.com)

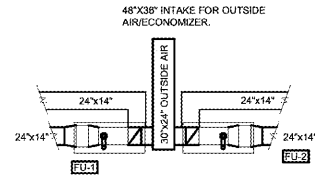

HVAC PLAN  
SCALE: 1/8"=1'-0"

CONTRACTOR MAY USE RECTANGLE DUCT OR FLEX DUCT  
WORK MUST BE PERFORMED BY A HVAC AND GAS CONTRACTOR LICENSED IN THE STATE OF TENNESSEE.  
ALLOW CLEARANCE AROUND ALL GAS APPLIANCES FOR SERVICE WORK. REFER TO MANUFACTURERS REQUIREMENTS FOR INSTALLATION.  
ALL RETURNS ARE 12"x3" UNLESS OTHERWISE SHOWN.  
ALL BRANCH DUCT ARE SIZE OF DIFFUSER NECK.

These drawings and specifications are owned and copyrighted by GUY PAYNE & ASSOCIATES ARCHITECTS and may not be used, copied or duplicated without written consent. Any information contained herein may be subject such persons to criminal and civil penalties and

GUY PAYNE & ASSOCIATES ARCHITECTS P.C.  
879 Willow Tree Circle, Suite 114  
Cordova, TN 38018  
901.756.1878(P) 901.756.1879(F)

NEW COMMUNITY CENTER FOR  
Hickory Chase Apartments  
600 HERITAGE DRIVE  
MADISON, TN

*Bernice Allen*  
12/13/17

DATE	NO.

PROJECT NUMBER  
DATE OF ORIGINAL ISSUE  
12/13/17  
SHEET NUMBER

M1