


ROOM USE SCHEDULE			
Number	Name	Area	USE
100	ENTRANCE LOBBY	305 SF	
101	ADMIN ASSIST OFFICE	218 SF	
102	WORK ROOM	206 SF	
103	DIRECTOR OFFICE	259 SF	
104	CLOSET	30 SF	
105	PRIVATE TOILET	56 SF	
106	STAFF TOILET	55 SF	
107	CORRIDOR	124 SF	
108	ALCOVE	234 SF	
109	OFFICE A	132 SF	EXTENSION AGENT AND/OR CAMP WORKER
110	OFFICE B	132 SF	EXTENSION AGENT AND/OR CAMP WORKER
111	OFFICE C	132 SF	EXTENSION AGENT AND/OR CAMP WORKER
112	OFFICE D	132 SF	EXTENSION AGENT AND/OR CAMP WORKER
113	OFFICE E	132 SF	EXTENSION AGENT AND/OR CAMP WORKER
114	OFFICE F	132 SF	EXTENSION AGENT AND/OR CAMP WORKER
115	IT ROOM	41 SF	
116	MECH/ELEC	76 SF	
117	JAN CLOSET	55 SF	
118	COORDOR	282 SF	
128	CORRIDOR	252 SF	
129	WOMEN BATHROOM	278 SF	
130	MEN BATHROOM	286 SF	
131	LEADERSHIP TRAINING	662 SF	VARIOUS TRAINING
132	STORAGE	67 SF	
133	BREAK ROOM	202 SF	
134	CORRIDOR	279 SF	
135	CORRIDOR	641 SF	
136	ARTS & CRAFT ROOM	691 SF	
137	STORAGE	95 SF	
138	STORAGE	109 SF	
139A	CONFERENCE ROOM A	476 SF	GROUP TRAINING / MEETINGS
139B	CONFERENCE ROOM B	472 SF	GROUP TRAINING / MEETINGS
139C	CONFERENCE ROOM C	477 SF	GROUP TRAINING / MEETINGS
140	CULINARY INSTRUCTION ROOM	934 SF	FOOD NUTRITION TRAINING CLASSES
141	OFFICE	116 SF	
142	STORAGE	84 SF	
143	STORAGE	85 SF	
144	RESEARCH LAB	450 SF	SMALL GROUP FITNESS AREA
145	CORRIDOR	156 SF	
146	OFFICE H	126 SF	EXTENSION AGENT AND/OR CAMP WORKER
147	STORAGE	142 SF	
148	SPRINKLER RISER ROOM	82 SF	
149	ELECTRICAL	49 SF	
150	OFFICE G	118 SF	EXTENSION AGENT AND/OR CAMP WORKER
151	CORRIDOR	713 SF	
152	CLASSROOM A	576 SF	VARIOUS OUTREACH PROGRAMS
153	CLASSROOM B	580 SF	VARIOUS OUTREACH PROGRAMS
154	CLASSROOM C	580 SF	VARIOUS OUTREACH PROGRAMS
155	CLOSET	33 SF	
156	COMPUTER LAB	645 SF	
157	MEZZANINE LEVEL	870 SF	

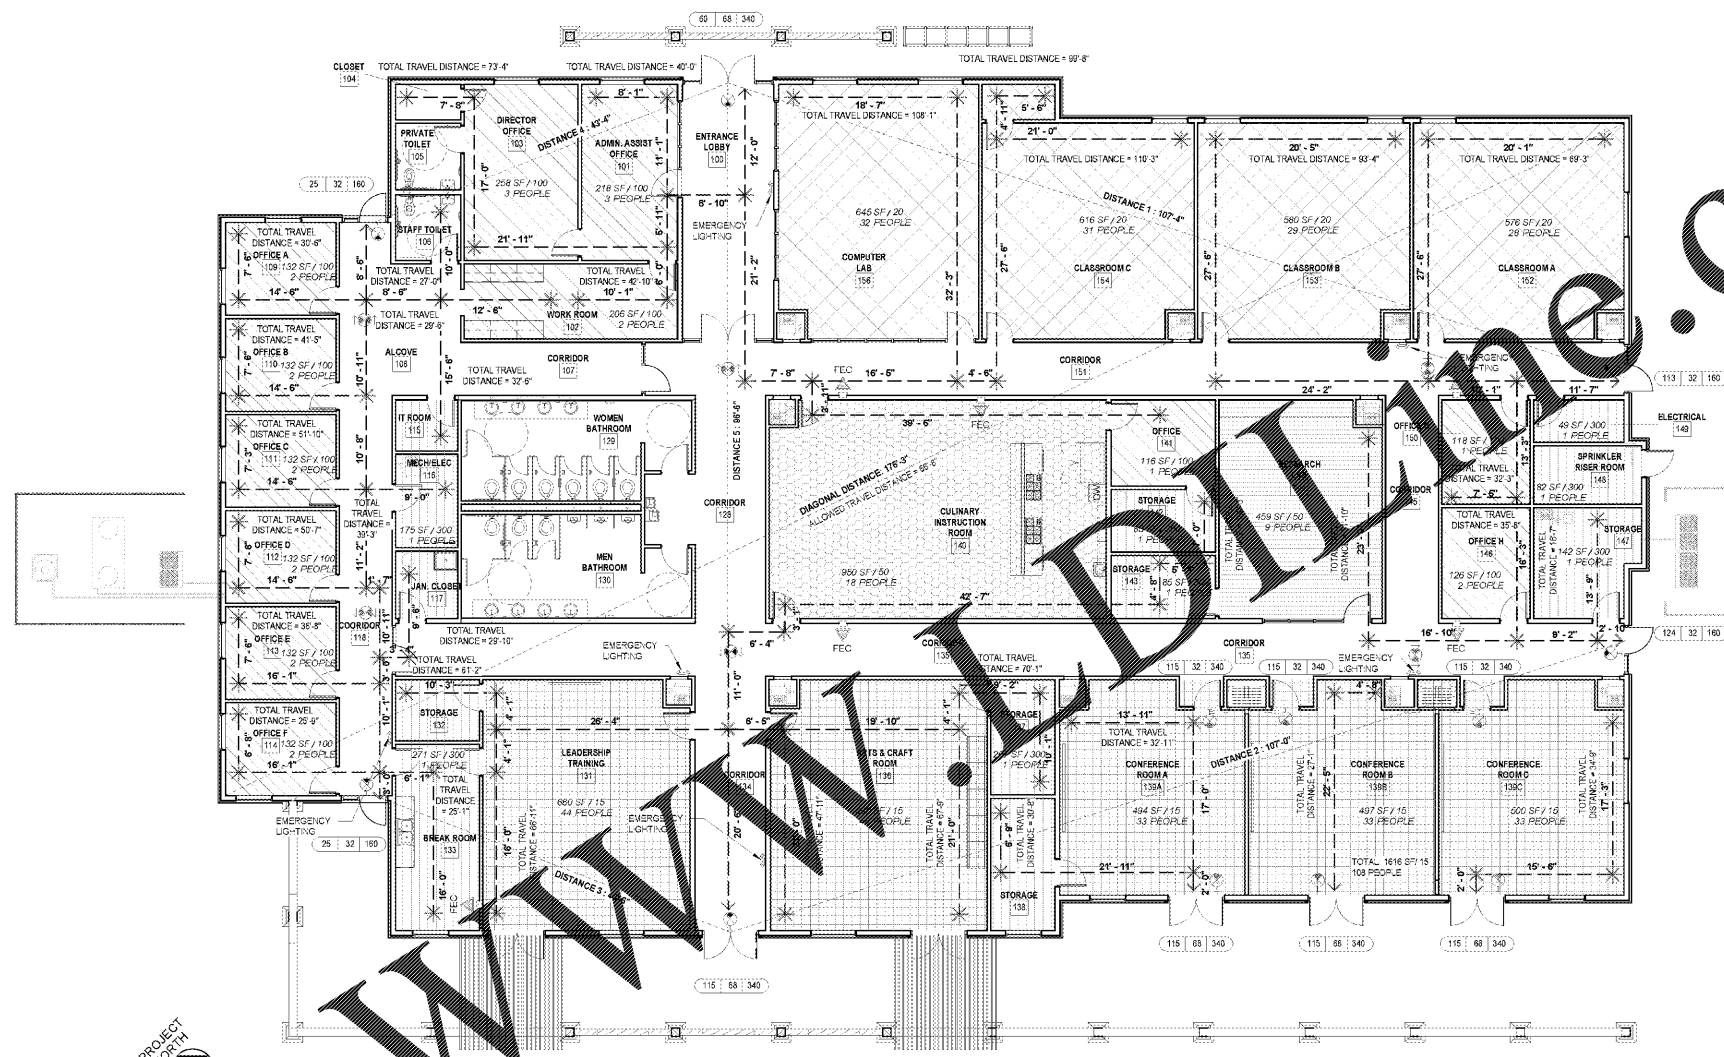


**LIFE SAFETY PLAN**

1" = 16' x 1" = 10'

**WALL SIGNAGE**

1. ALL SIGNAGE DESIGN AND SYMBOLS PER UNIVERSITY STANDARDS
2. SEE SEM FIRE SCHEDULE FOR ALL ROOMS REQUIRING SIGNAGE PER UNIVERSITY REGULATIONS
3. REQUIRED CODE AND SAFETY SIGNAGE:
  - A. "FIRE EXTINGUISHERS"
  - B. "MEDICAL ROOM"
  - C. "ELECTRICAL ROOM"

**LIFE SAFETY LEGEND**

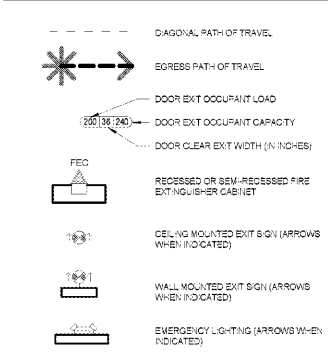

TRAVEL DISTANCES	
MAX. DIAGONAL DISTANCE	176'-3"
MAX. ALLOWABLE DISTANCE	66'-6"
DISTANCE 1	107'-4"
DISTANCE 2	107'-0"
DISTANCE 3	43'-6"
DISTANCE 4	43'-4"
DISTANCE 5	66'-6"

- FIRE RATING AND FIRE PROOFING NOTES**
1. SEE FLOOR PLANS AND WALL TYPE SCHEDULE FOR WALL ASSEMBLY TYPES AND CONSTRUCTION
  2. FIRE CALLS AROUND ALL PENETRATIONS PASSING THROUGH WALLS
  3. SEE MECHANICAL AND PLUMBING DRAWINGS FOR SPECIAL DETAILS WHERE DUCTWORK AND PIPING PASS THROUGH WALLS

**GENERAL NOTES**

1. PROVIDE FIRE EXTINGUISHERS IN ACCORDANCE WITH IFC 10. INSTALL WALL MOUNTED FIRE EXTINGUISHERS (FE) AT 4'-0" APFT TO TOP OF CABINET. SERIAL CONTRACTOR TO COORDINATE LOCATIONS WITH (OSE) THE STATE ENGINEER. BREAK ROOM APPLIANCES AND FURNISHINGS PROVIDED BY OWNER.
2. SEE SEM-EST C2.02 FOR FIRE DEPARTMENT ACCESS LOCATIONS

NO.	DATE	DESCRIPTION	BY
1	2018.03.29	Issued Package	MS

BD SET

OSR REVIEW SUBMITTAL 11/17/2017

PRINCIPAL IN CHARGE: SS  
PROJECT ARCHITECT: MA  
DESIGN BY: SS / CS

SHEET TITLE:  
LIFE SAFETY PLAN

SHEET NO. PROJ. NO.  
13140.00

G1.10



1890 EXTENSION SC STATE UNIVERSITY  
**CAMP HARRY G. DANIELS 1890 EXTENSION FACILITY - RE - BID**  
 Agency Review ID: H24-9649-CA  
 116 Camp Daniels Road, Ellenton, SC

**mc millan | parsons | smith**  
 architects  
 ashville atlanta charlotte columbus denver  
 pittsburgh richmond roanoke san francisco  
 p.o. box 8922 greenville, sc 29602-8922  
 864.242.2034  
 www.mcmillanparsonsmith.com

Order Plans

FORN