

ANTHONY CASSATA ARCHITECT  
280 W. BUTTERFIELD RD. SUITE 340  
WILMINGTON, IL 62523  
TEL: (312) 795-1245  
FAX: (312) 795-6123

dd's DISCOUNTS

OWNER:


ROSS STORES  
5130 HACIENDA DRIVE  
DUBLIN, CA 94568

PROJECT:

dd's DISCOUNTS STORE #5352 (GREENVILLE, SC)  
WHITE HORSE PLAZA  
6119 WHITE HORSE ROAD  
GREENVILLE, SC 29611

BASED ON DD'S 22K TURNKEY - EXISTING PROTOTYPE DATED MARCH, 2016

DRAWING TITLE:	MECHANICAL ROOF PLAN	
REV. NO.:	DATE:	DESCRIPTION:
1	02/02/18	FOR ROSS REVIEW
2	03/12/18	ROSS MARK-UPS

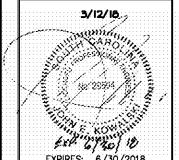


COPYRIGHT: ALL DRAWN AND WRITTEN INFO. APPEARING HEREIN SHALL NOT BE DUPLICATED, DISCLOSED OR OTHERWISE REPRODUCED WITHOUT WRITTEN CONSENT.

PFDA JOB: #16027

SCALE AS NOTED

DRAWN BY: CHECKED BY:

SHEET NUMBER M1.1

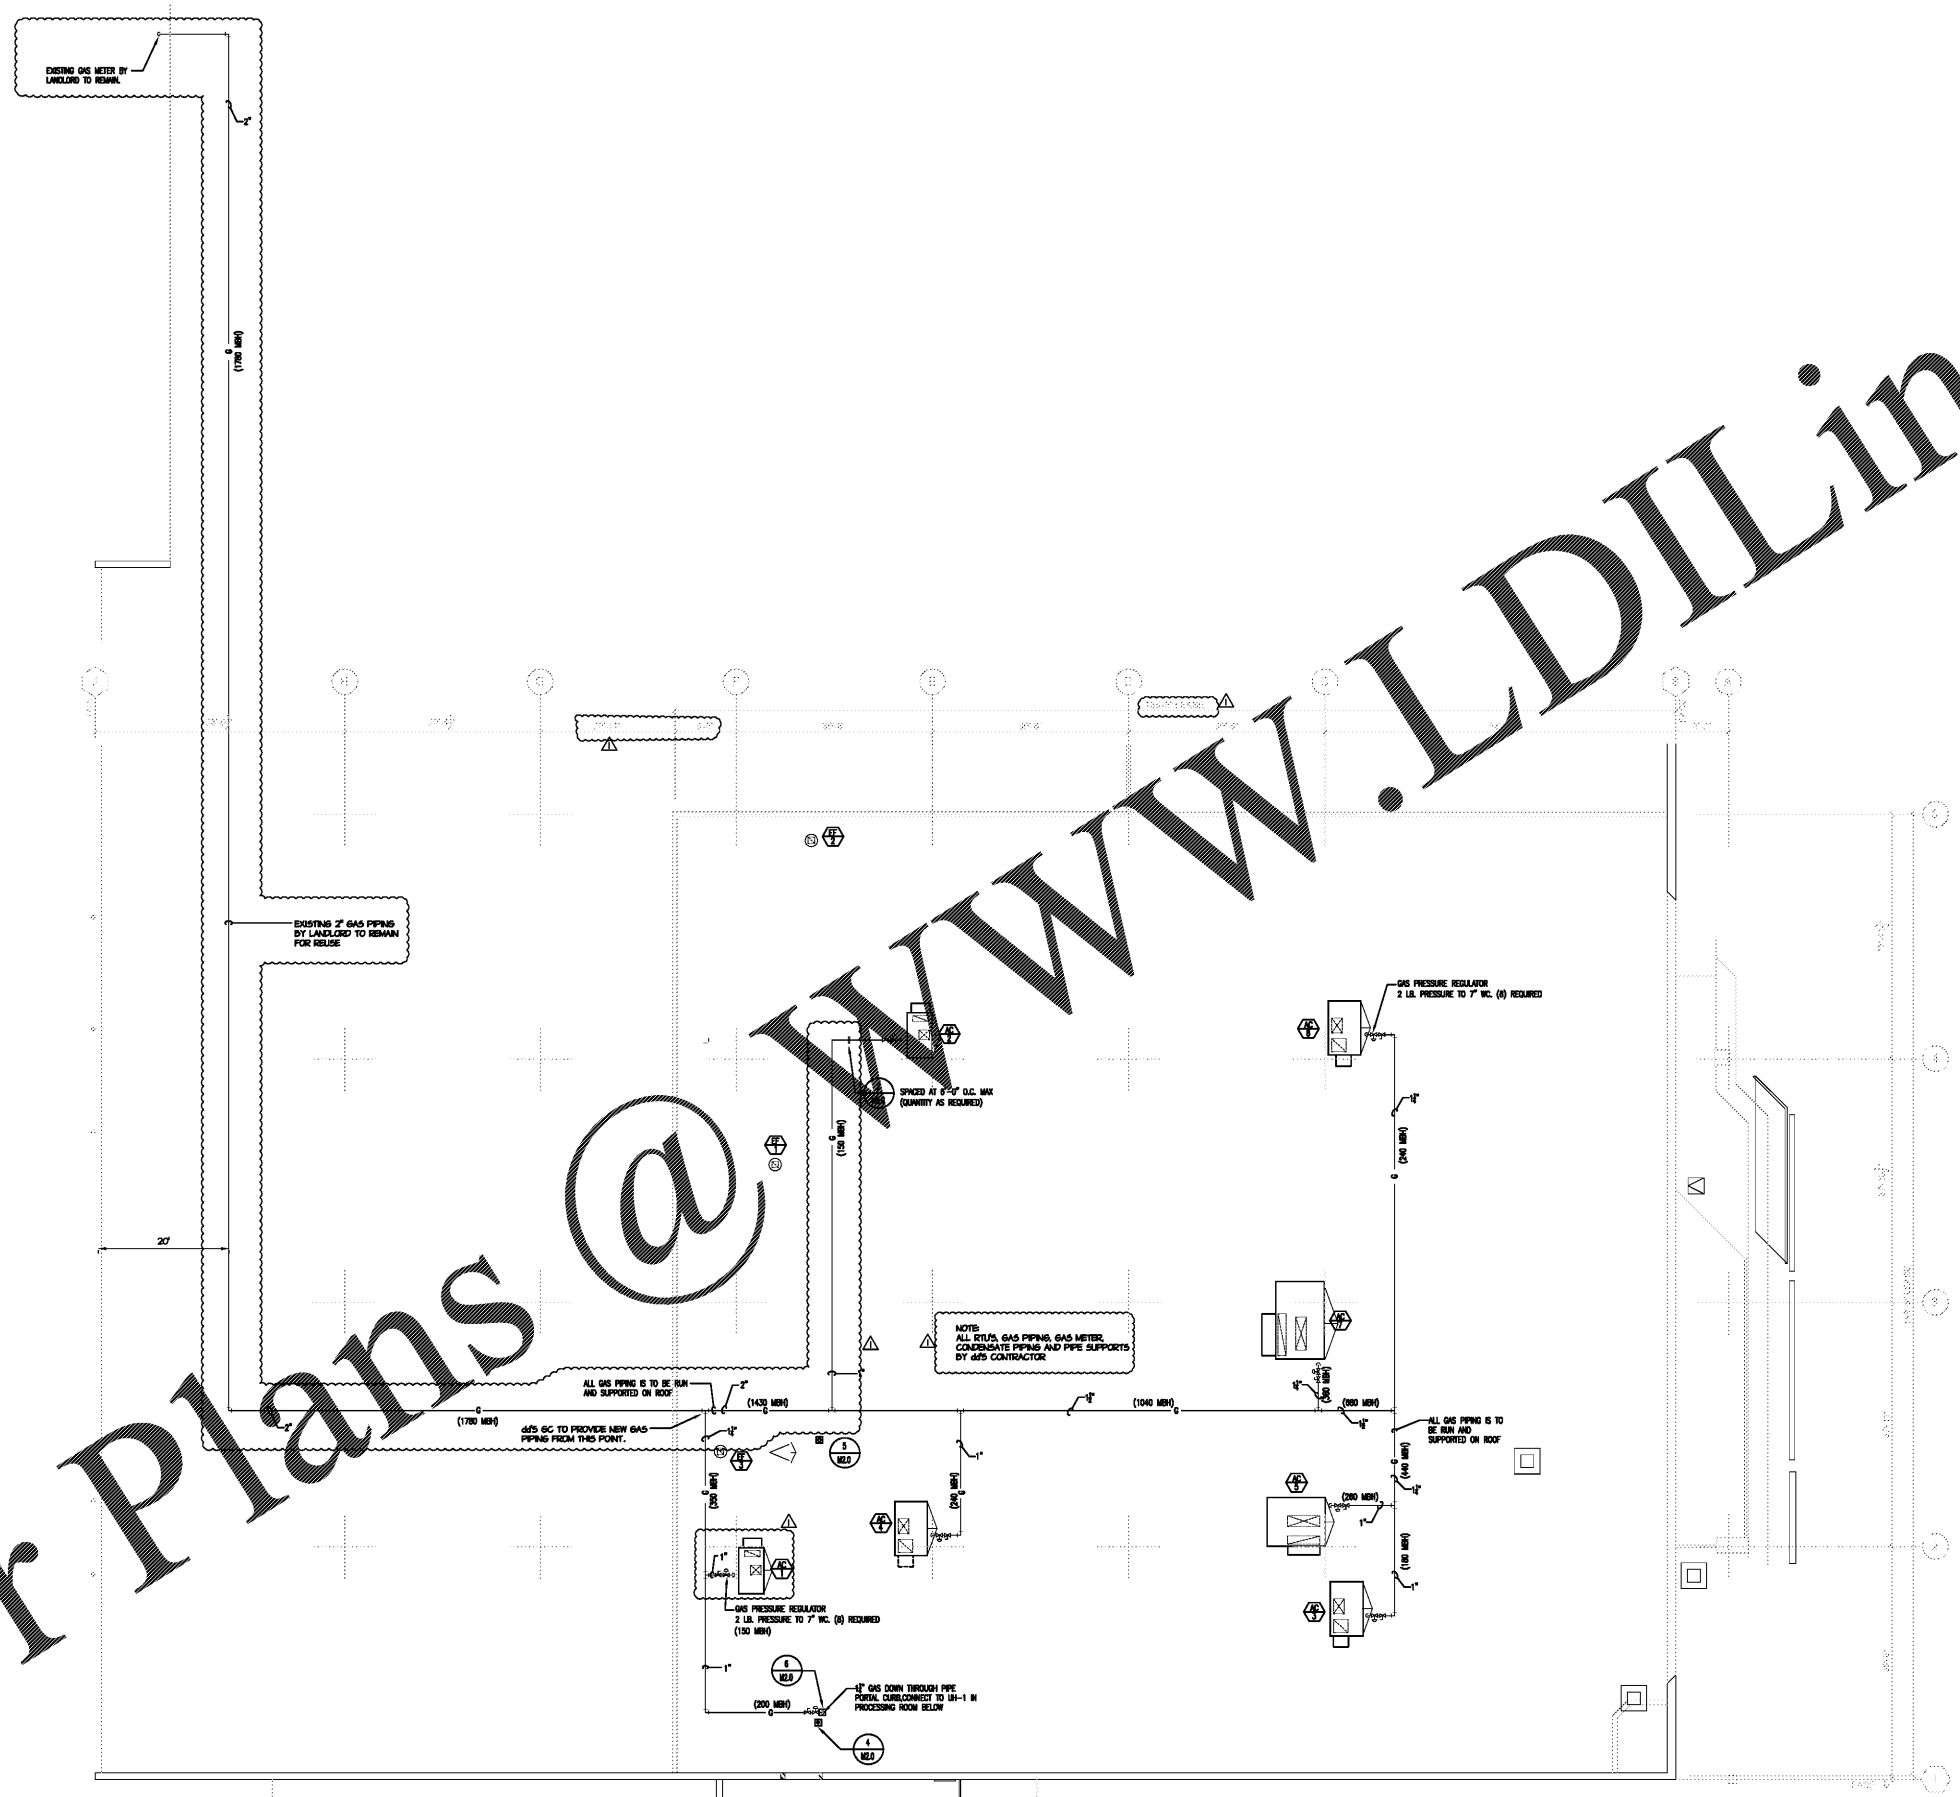

1 ROOF PLAN  
M1.1 SCALE: 3/32" = 1'-0"

Order Plans @ WWW.LDILine.com