

ANTHONY CASSATA ARCHITECT
2805 WATTFIELD ROAD SUITE 340
CHICAGO, ILL. 60652
TEL: (312) 464-1245
FAX: (312) 795-6123


dd's DISCOUNTS

OWNER:
ROSS STORES
5130 HACIENDA DRIVE
DUBLIN, CA 94568

PROJECT:
dd's DISCOUNTS STORE #5352 (GREENVILLE, SC)
WHITE HORSE PLAZA
6119 WHITE HORSE ROAD
GREENVILLE, SC 29611

BASED ON DD'S 22K TURNKEY - EXISTING PROTOTYPE DATED MARCH, 2016

REV. NO.	DATE	DESCRIPTION
1	02/07/18	FOR ROSS REVIEW
2	03/12/18	FOR ROSS MARK-UPS

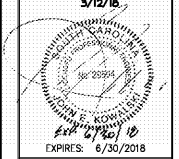


DRAWING TITLE:
POWER PLAN
3/12/18
COPYRIGHT: ALL DRAWN AND WRITTEN INFO, APPEARING HEREIN SHALL NOT BE DUPLICATED, DISCLOSED OR OTHERWISE REPRODUCED WITHOUT WRITTEN CONSENT.
PFDA JOB: #16027
SCALE: AS NOTED
DRAWN BY: CHECKED BY:
SHEET NUMBER: E3.0

SYMBOL	DESCRIPTION
[S]	PULL STATION @ +4" A.F.F.
[D]35	HEAT DETECTOR @ 135deg. RISE
[D]	DUCT DETECTOR W/ ADDRESSABLE INPUT MDS ON SUPPLY AND RETURN DUCTS
[AV]	AUDIO VISUAL SIGNAL VISUAL SIGNAL
[SD]	SMOKE DETECTOR
[FAS]	FIRE ALARM CONTROL PANEL W/ BATT BACK UP BOSCH 07024 PANEL
[FS]	FIRE ALARM FLOW SWITCH ON INCOMING SPRINKLER MAIN
[FA]	FIRE ALARM ANNUNCIATOR PANEL @ +42" AFF
[F]	FIRE ALARM FLOW TAMPER SWITCH ON INCOMING SPRINKLER MAIN
[K]	FAN SHUT DOWN RELAY
[KS]	KEY SWITCH @ +84" FOR FAN SHUT DOWN RELAY (UNIT AS NOTED)
[KB]	FIRE DEPT. KNOX BOX (VERIFY LOCATION)

ELECTRICAL ROOM
ALL 60'S ELECTRICAL PANELS AND SWITCH GEAR MUST BE LOCATED IN THE ELECTRICAL ROOM. SEE PROTOTYPE SHEET E2.0/DETAIL 5.
600 AMP 277/480V, 3PH, 4W SERVICE. NOTE: ROSS STORES NOT ACCEPT SPLIT-UP TRANSFORMERS.
PHONE: 25 PAIR CABLE.
ROOF HATCH AND LADDER MUST BE IN ELECTRICAL ROOM ARCHITECT TO MODIFY STRUCTURE TO ACCOMMODATE

NOTE: TEMPERATURE SENSOR NOT SHOWN ON MECHANICAL OR ELECTRICAL PLANS. SEE EMS PLANS FOR EXACT LOCATION. CONTACT: CAC BUILDING AUTOMATION (650) 292-7450.

4" DIA OPEN CONDUIT W/ PULL STRING & NYLON BUSINESS, STUBBED FROM BACKBOARD TO TELEPHONE DYNAMIC LANDLORD (VERIFY LOCATION)

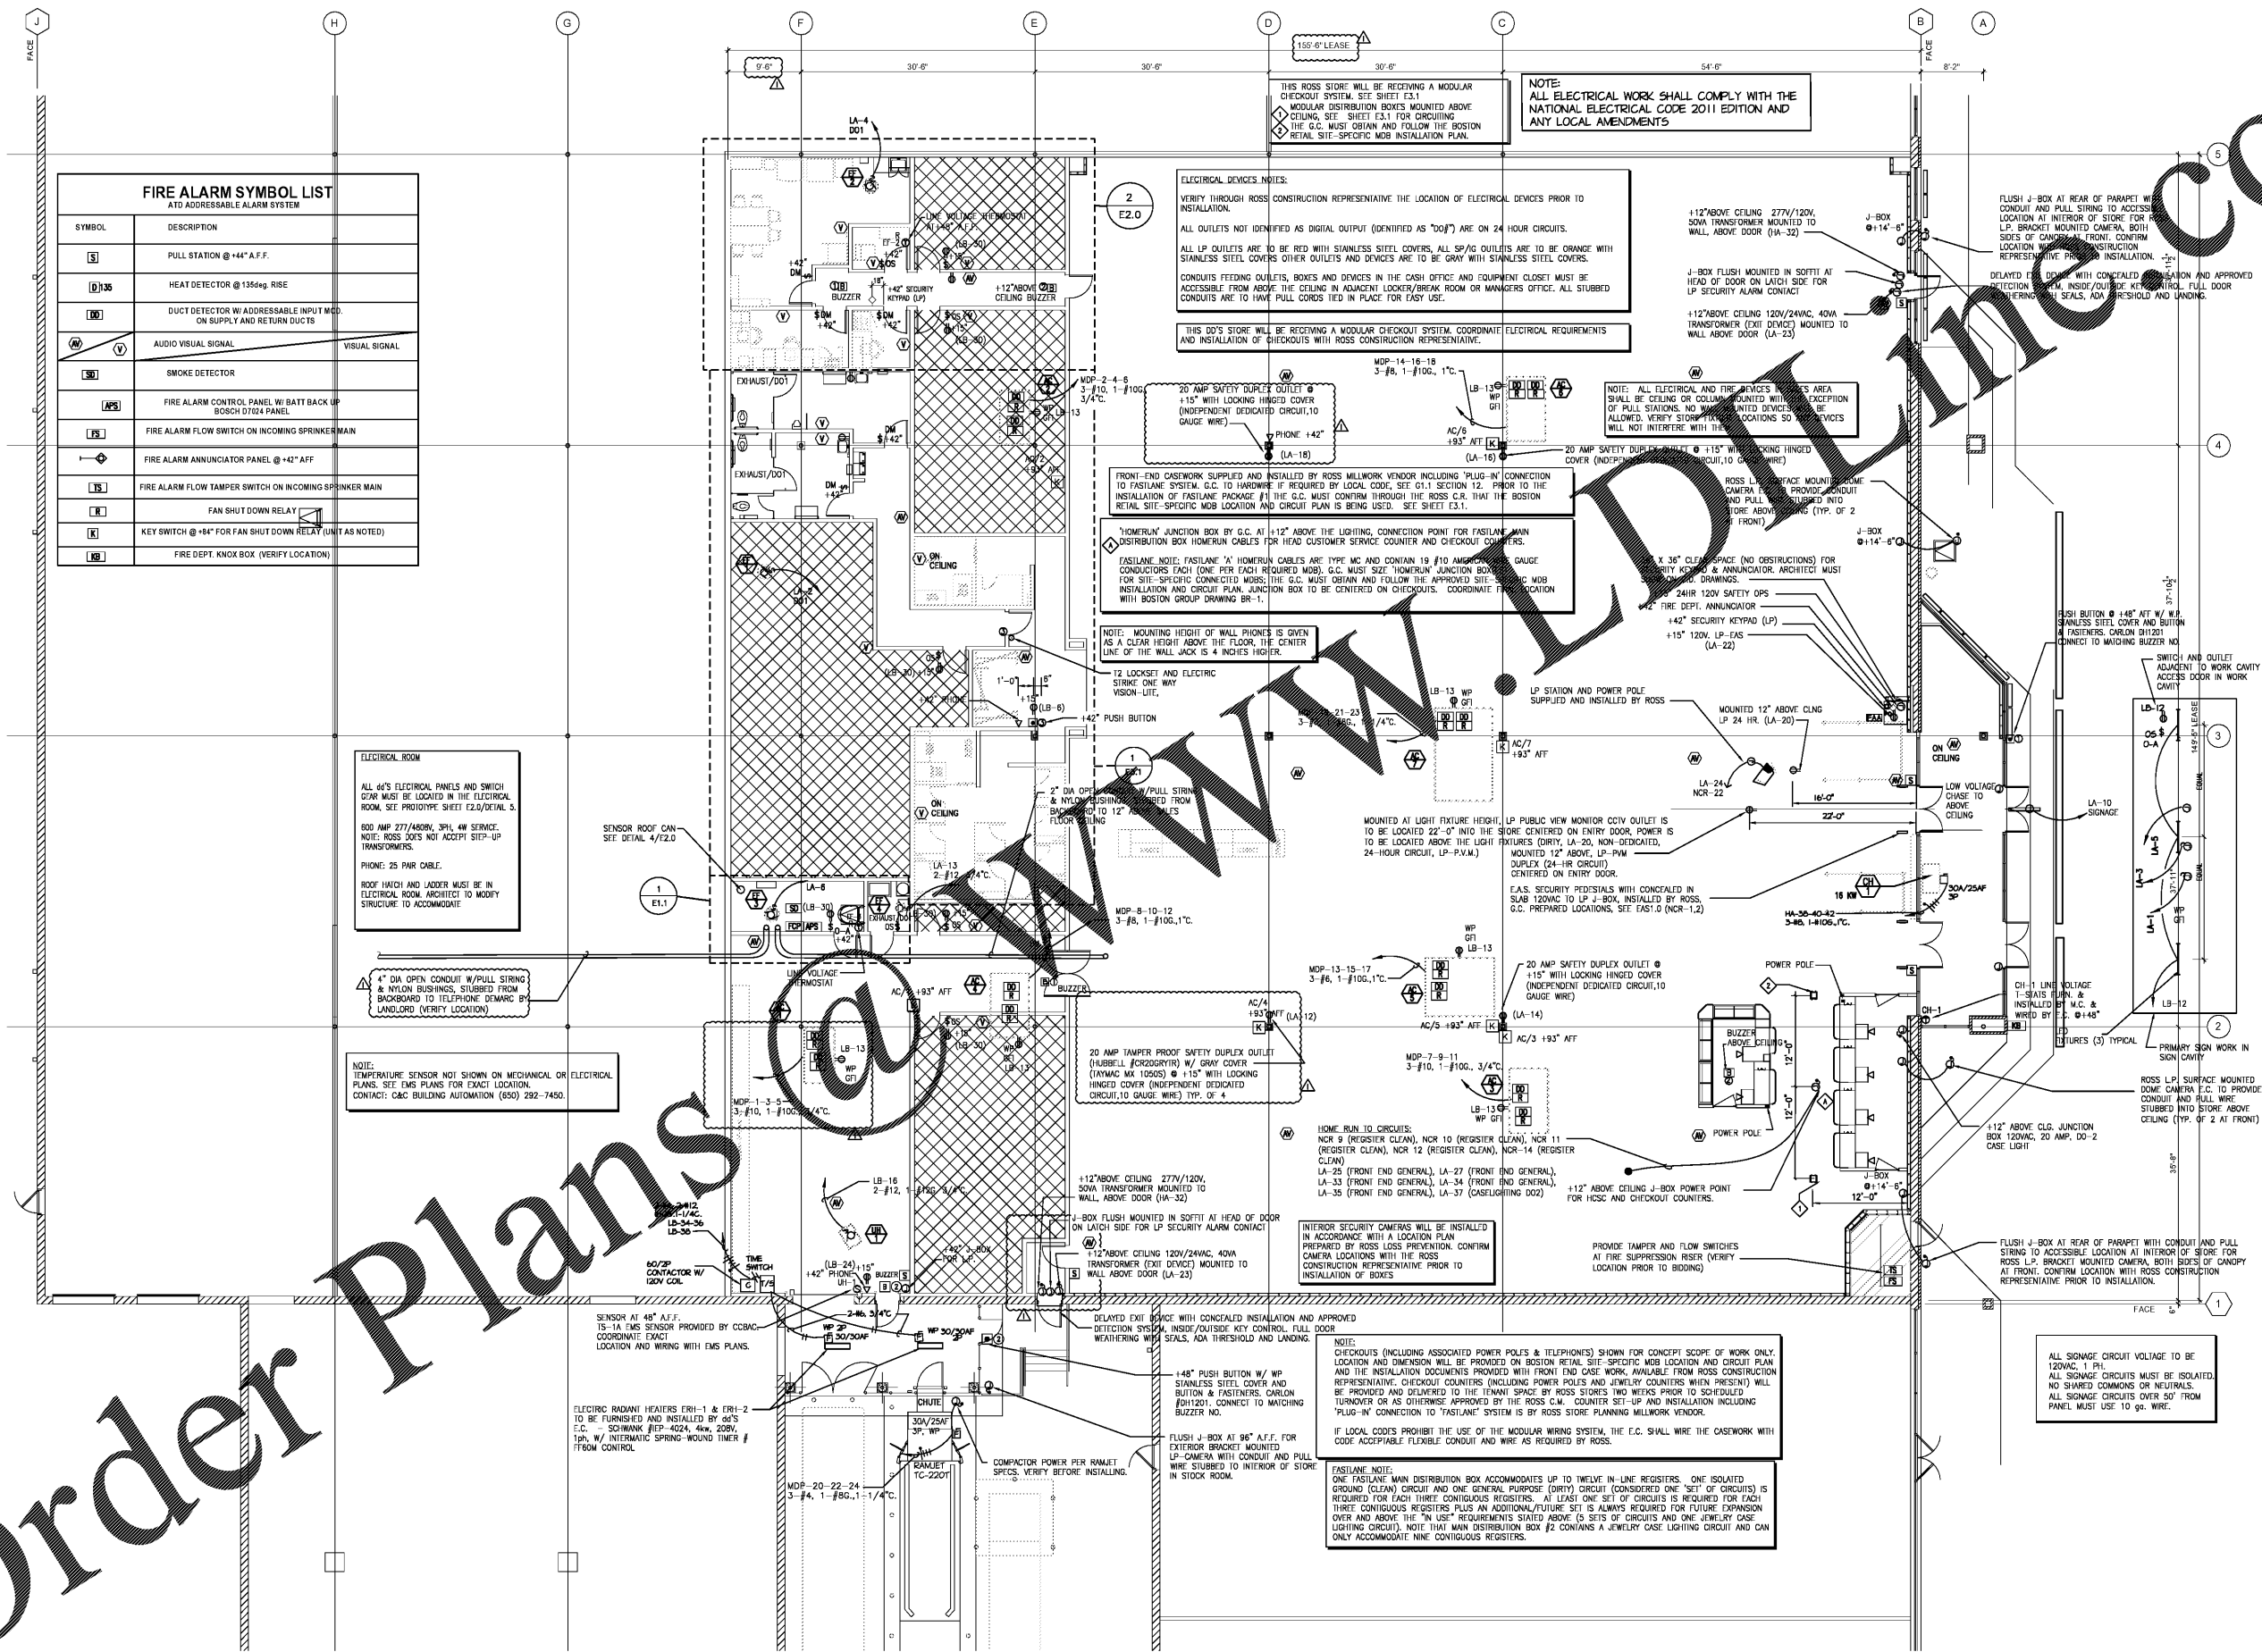

POWER PLAN
SCALE 1/8" = 1'-0"

Order Plans