

Owner:
Georgetown County
716 Prince Street
Georgetown, SC 29442

SGA ARCHITECTURE
ARCHITECTURE AND INTERIORS
LANDSCAPE ARCHITECTURE


Pawleys Island / Charleston / GREENVILLE
8263 Ocean Hwy. / PO Box 1859
Fowling Island, SC 29555
Phone: 843.237.3421 / Fax: 843.237.1992
www.SGAarchitecture.com

Civil Consultant:
ETS
ENGINEERING AND TECHNICAL
SERVICES, INC.
CONSTRUCTION PROFESSIONALS
88 Carolina Lane
P.O. Box 200
Fountain Inn, SC 29643
Phone: (803) 281-2822 Fax: (803) 281-2823

MEP Consultant:
Charleston Engineering
1219 Wappoo Creek Dr.
Charleston, SC 29412
843-752-4012
Mechanical, Plumbing & Control

Structural Consultant:
WEATHERLY STRUCTURAL ENGINEERS
24 The Wood Way • Columbia, SC 29204
703-739-7000

Irrigation Consultant:

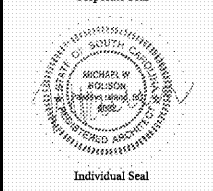


MEMBERS OF
THE AMERICAN INSTITUTE OF ARCHITECTS
COPYRIGHT 2018 ALL RIGHTS RESERVED
PRINTED OR ELECTRONIC DRAWINGS AND
DOCUMENTATION MAY NOT BE REPRODUCED
IN ANY FORM WITHOUT WRITTEN PERMISSION
FROM SGA ARCHITECTURE.

Job Number: 17070
Date: 02/16/18
Drawn by: PW, MR
Checked by: MR

Notes:
BIDDING DOCUMENTS
Not for Construction

Revisions:

Reflected Ceiling
Plan
A121
3 of 43
Bidding Documents

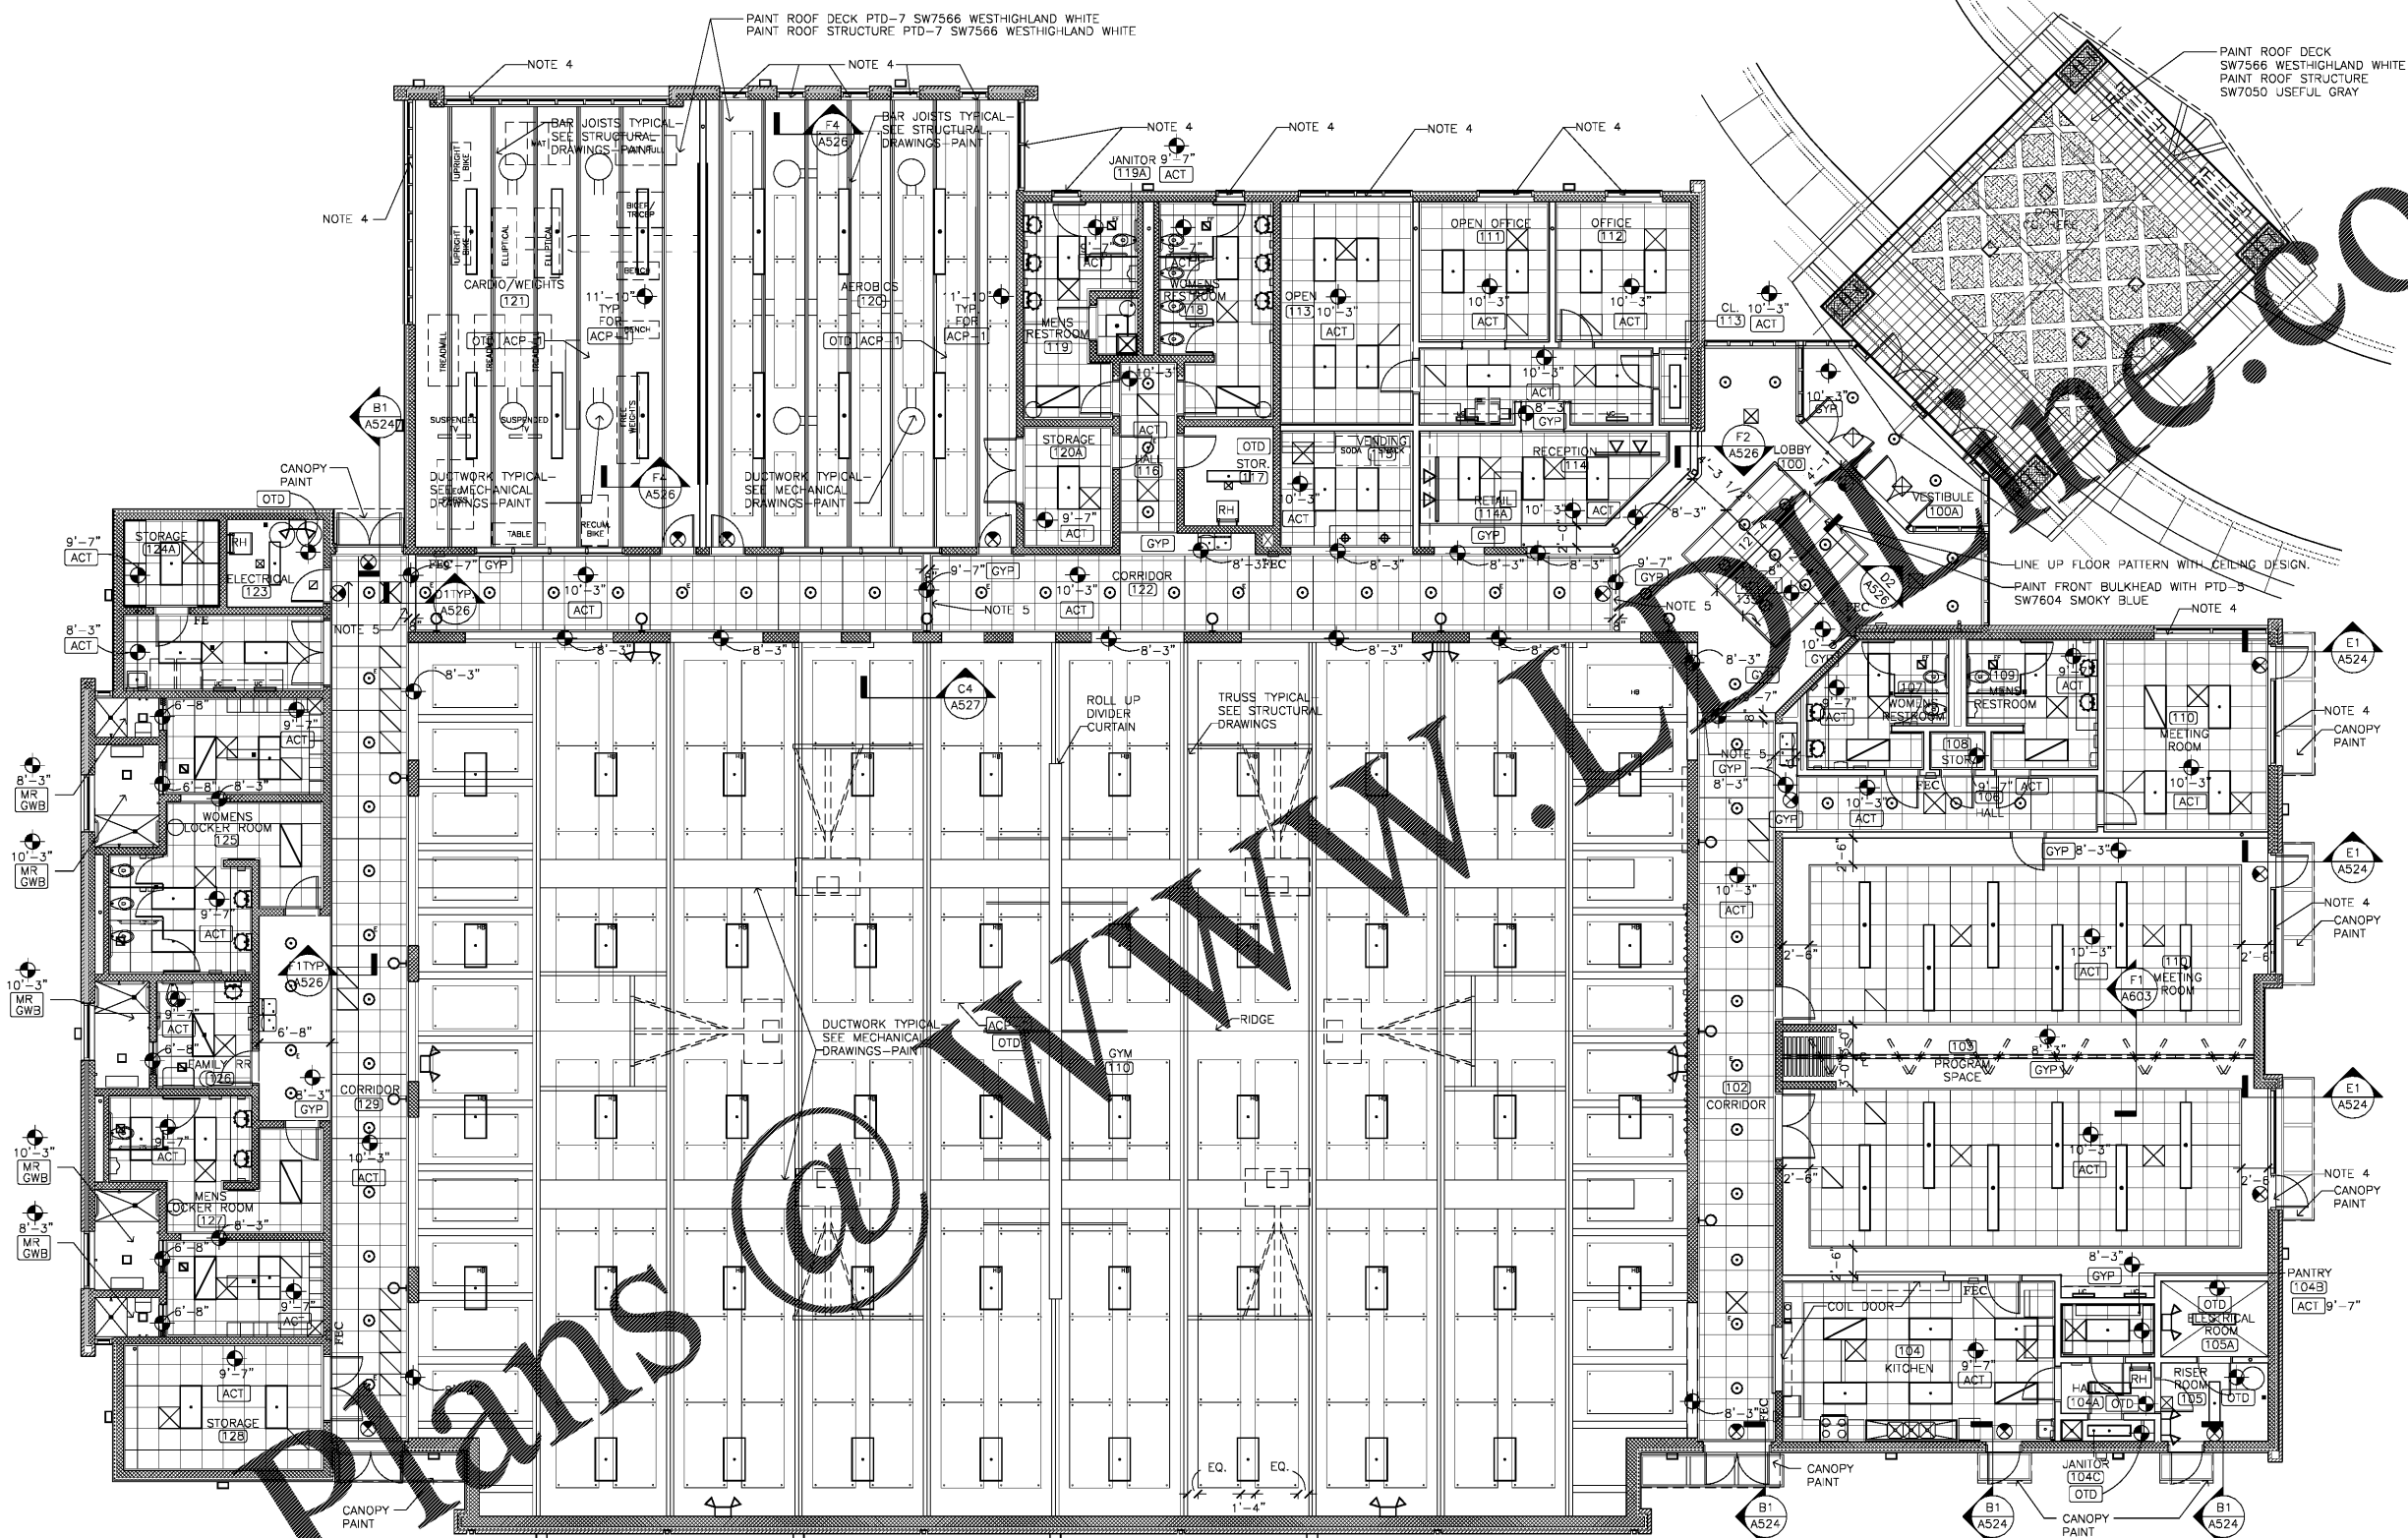

F1 REFLECTED CEILING PLAN
1/8"=1'-0"

LEGEND

- 4 FLUORESCENT U-I-TROFFER
- 24" FLUORESCENT U-I-TROFFER
- EMERGENCY FIXTURE
- PENAN DIRECT/INDIRECT LIGHTING FIXTURE
- FLUORESCENT LIGHTING FIXTURE SURFACE MOUNT
- TRACK LIGHTING
- DOWNLIGHT
- WALL WASHER/SCONCE
- 2 HEAD EMERGENCY BATTERY PACK
- ⊕ PENDANT FIXTURE
- ⊙ RECESSED CAN
- ⊠ SUPPLY AIR GRILL
- ⊡ EXHAUST AIR GRILL
- ⊞ RETURN AIR GRILL
- ⊕ EXIT SIGN
- WALL MOUNTED VANITY FIXTURE
- ⊞ UNDERCABINET FIXTURE
- EXTERIOR SCONCE
- ⊕-0'-0" HEIGHT (FEET & INCHES) ABOVE FINISHED FLOOR
- MR GWB MOISTURE RESISTANT GYPSUM WALL BOARD
- GWB GYPSUM WALL BOARD
- OTD OPEN TO DECK
- ACT ACOUSTICAL CEILING TILE
- RH ROOF HATCH
- HB FLUORESCENT HIBAY
- ACP-1 WBI SPECTRUM PVC SERIES 2900PS-2065-W ACOUSTIC CEILING PANEL COLOR: (TO MATCH PTD. CEILING AS SCHED.) 2X6-ALTERNATE #1
- ACP-2 WBI SPECTRUM PVC SERIES 2900PS-2065-W ACOUSTIC CEILING PANEL COLOR: (TO MATCH PTD. CEILING AS SCHED.) 4X8- ALTERNATE #1

NOTES:

1. ALL DIMENSIONS ARE TO/FROM FACE OF FINISHED SURFACE UNLESS NOTED OTHERWISE.
2. REFER TO ELECTRICAL DRAWINGS LIGHTING FIXTURE SCHEDULE.
3. REFER TO SHEETS A605 & A606 ROOM FINISH SCHEDULE & LEGEND.
4. WALL MOUNTED ROLLER SHADE WITH FASCHIA. SEE SPECIFICATIONS.
5. TYP. PAINT BULKHEADS WITH PTD-6 SW9152 LET IT RAIN IN CORRIDORS.
6. REFER TO ELEVATIONS ON SHEETS A401-A406 AND A701-A704 FOR PAINT LOCATIONS.
7. PAINT ROOF DECK PTD-7 SW7566 WEST-HIGHLAND WHITE, PAINT ROOF STRUCTURE PTD-6 SW9152 LET IT RAIN AT GYM.
8. METAL ROOF DECK TO BE PAINTED PTD-7 SW8566 WEST-HIGHLAND WHITE U.O.N.
9. ALL MOISTURE-RESISTANT GYPSUM WALLBOARD CEILINGS TO BE PAINTED PTD-8 SW8566 WEST-HIGHLAND WHITE U.O.N.

Order Plans