

Owner:
Georgetown County
716 Prince Street
Georgetown, SC 29442


SGA ARCHITECTURE
SOUTHVILLE ENGINEERING
LANDSCAPE ARCHITECTURE
Pawleys Island / Charleston / GREENVILLE
8243 Ocean Hwy. / PO Box 1859
Pawleys Island, SC 29585
Phone: 843.237.2421 / Fax: 843.237.1992
www.sgaarchitecture.com

Civil Consultant:
ETS
ENGINEERING AND TECHNICAL
SERVICES, INC.
CONSULTING ENGINEER
58 Commonwealth Lane
P.O. Box 292
Georgetown, SC 29442
Phone: (843) 237-3002 Fax: (843) 237-2269

MEP Consultant:
Charleston Engineering
125 B. Wagon Creek Dr.
Charleston, SC 29412
843-762-4242
Mechanical, Plumbing & Electrical

Structural Consultant:
WEATHERLY STRUCTURAL ENGINEERS
100 Main Street, Suite 100, Charleston, SC 29401

Irrigation Consultant:

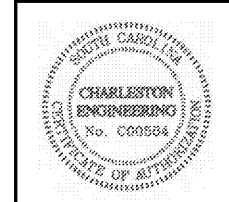


MEMBERS OF
THE AMERICAN INSTITUTE OF ARCHITECTS
COPYRIGHT 2018. ALL RIGHTS RESERVED.
PRINTED OR ELECTRONIC DRAWINGS AND
DOCUMENTATION MAY NOT BE REPRODUCED
IN ANY FORM WITHOUT WRITTEN PERMISSION
FROM SGA ARCHITECTURE

Job Number: 1788
Date: 2/6/18
Drawn by: TURNER
Checked by: TURNER

Notes:
BIDDING DOCUMENTS
Not for Construction

Revisions:

HIGH LEVEL
HVAC PLAN
M121

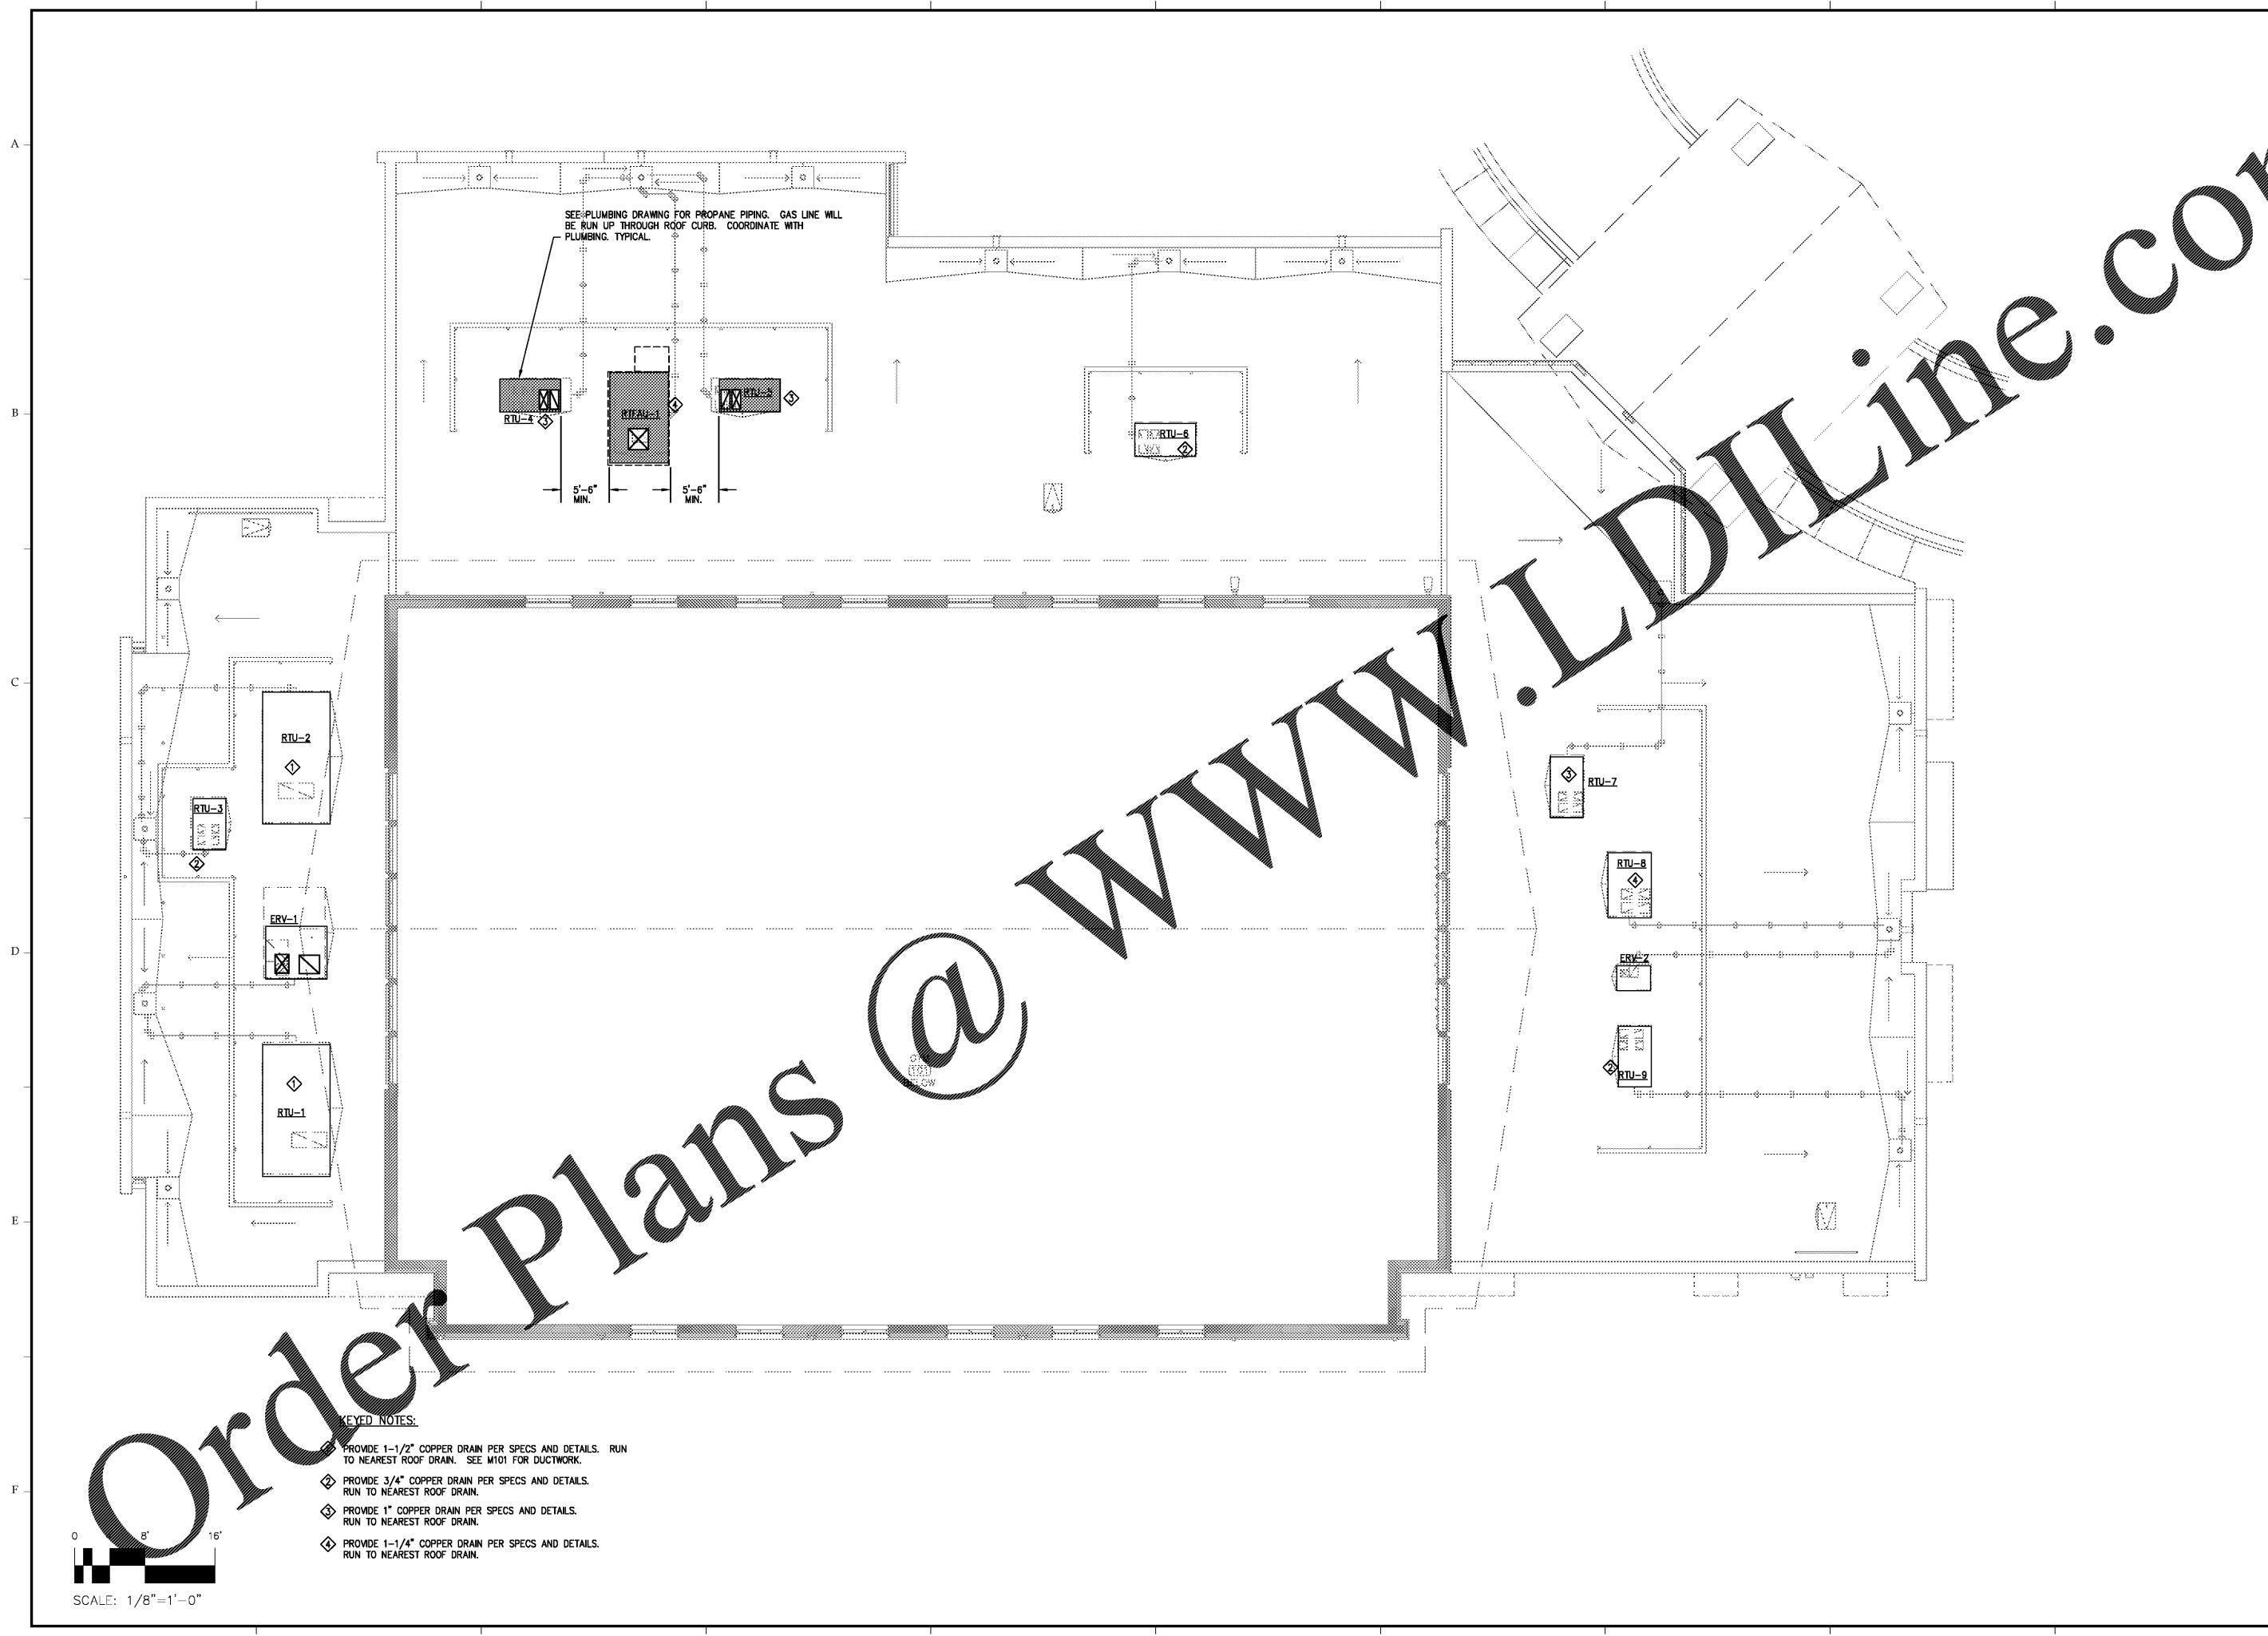

Order Plans @

WWW.LDLine.com