


SYMBOL	DESCRIPTION
	RECESSED DOWNLIGHT
	TRACK w/ TRACK HEADS - WBC TU TRACK BBW TU TRACK
	FLUORESCENT STRIPS - SURFACE MOUNTED
	FLUORESCENT STRIPS - CHAIN-HUNG FROM STRUCTURE 12'-0" (3658mm) A.F.F.
	MULTI-LAMP RECESSED DOWNLIGHT
	EGRESS SIGNAGE - WBC CEILING MOUNTED (UNLESS INDICATED OTHERWISE) BBW WALL MOUNTED (UNLESS INDICATED OTHERWISE)
	EMERGENCY LIGHT
	SPEAKER
	SUPPLY DIFFUSER - ORDERED PRIMED FOR GYP. BD. CEILINGS. REFER TO CEILING ACCESSORIES FINISH NOTE FOR PAINT FINISH, WHEN APPLICABLE - WBC (GR), BBW (BU)
	RETURN AIR GRILLE - ORDERED PRIMED FOR GYP. BD. CEILINGS. REFER TO CEILING ACCESSORIES FINISH NOTE FOR PAINT FINISH, WHEN APPLICABLE - WBC (GR), BBW (BU)
	CEILING ACCESS PANEL
	EXHAUST AIR REGISTER
	PENDANT LIGHT - MOUNTED 7'-6" (2286mm) A.F.F.
	PENDANT LIGHT - MOUNTED 7'-6" (2286mm) A.F.F.
	PULLEY PENDANT LIGHT - MOUNTED 6'-3" (1905mm) A.F.F.
	WALL SCONCE
	LYAN CAMERA - SUPPLIED AND INSTALLED BY SECURITY VENDOR
	TRAFFIC COUNTER - -WH = WHITE (BBW) -BL = BLACK (BBW) -DG = DOYER GRAY (WBC)
	CABINET DISPLAY LIGHTING
	SCINT AIR: # = MOUNTING STYLE (1, 2 OR 3) C = COLOR (B OR W)
	TABLE LAMP - POTTERY BARN - WARREN PULLEY TASK
	DISPLAY LIGHTING DRIVER WATTAGE

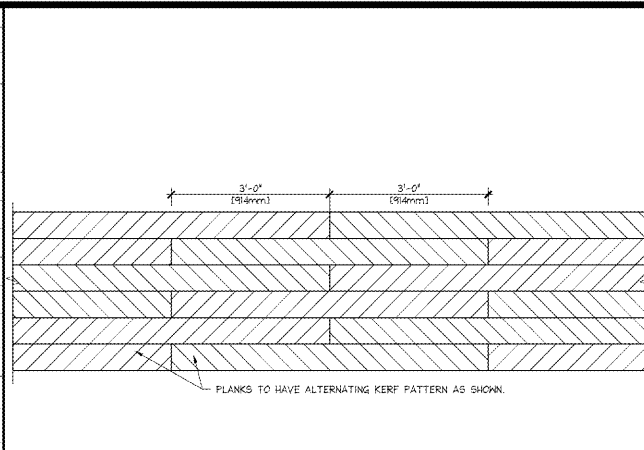

**PATTERN OF PLANKING
SF-90 @ CEILING**


3/4" = 1'-0"
42D-A041-M00-DETL
M
25.10.18

- NOTES:**
- ALL CEILING HEIGHTS ARE FROM THE TOP OF FINISH FLOOR TO UNDERSIDE OF FINISH CEILING.
 - PROVIDE ADEQUATE CLEARANCES FOR FIXTURES, DUCTS, CEILINGS, AND RELATED PERTINENT ITEMS NECESSARY TO MAINTAIN THE SPECIFIED HEIGHTS ABOVE FINISH FLOOR.
 - ADDITIONAL HANGER AND SAFETY WIRES FOR LIGHT FIXTURES, SPEAKERS AND DUCTWORK, AS REQUIRED BY LOCAL CODES, TO BE THE RESPONSIBILITY OF THE CEILING SUBCONTRACTOR.
 - SPEAKER HEAD LAYOUT TO CONFORM TO LOCAL CODE, TAKING IN ACCOUNT LOCATIONS OF DUCTWORK, LIGHTING AND LOCATION OF TENANT'S CABINET, FIXTURE AND SWELING UNITS. SPRINKLER HEAD COLOR TO MATCH CEILING FINISH AT SALES AREAS. REFER TO P02.01 FOR MORE FINISH LOCATIONS.
 - ARCHITECTURAL DRAWINGS DETERMINE LOCATION OF DOWNLIGHTS AND SUPPRESSED ALL OTHERS, U.G.N.
 - AFTER INSTALLATION, ELECTRICAL CONTRACTOR IS TO TILT THE LAMP IN ALL "T" FIXTURES @ A 45 DEGREE ANGLE TOWARD WALL OR CABINETS.
 - SEE LIGHT FIXTURE SCHEDULE ON ELECTRICAL DRAWINGS FOR FIXTURE MODEL NUMBERS KEYS TO THE LIGHTING AND CEILING LEGEND.
 - NO EMERGENCY LIGHTS, EXIT LIGHTS OR SENSORS ARE TO BE PLACED ON THE PERIMETER SALES WALLS.
 - PAINT CEILING EQUIPMENT WITH CORRESPONDING CEILING PAINT AS ALLOWABLE PER CODE. INCLUDED BY NOT LPTED TO, SPEAKERS, LIGHT TRIMS, EMERGENCY LIGHTS, ETC., COORDINATE WITH PM PRIOR TO PAINTING.
 - SEE FIXTURE DETAILS FOR LIGHTING LAYOUTS OF CASHWRAP, WALL CABINETS, AND WALL TOWER.

CEILING AND LIGHTING LEGEND

1/4" = 1'-0"
42L-A041-L01-LGND
R
12.13.17

CEILING ACCESSORIES FINISH NOTE:
G.C. TO PAINT RECESSED LIGHTING TRIM (EXCEPT 'X' EMERGENCY FIXTURES), SPEAKER & SPEAKER TRIM, SECURITY DOME TRIM & ACCESSORIES, AND SUPPLY DIFFUSERS & RETURN AIR GRILLES TO MATCH CEILING (BBW-PT-20, WBC-PT-B3)
* DO NOT PAINT INTERIOR LIGHT HOUSING, ONLY BOTTOM TRIM RING

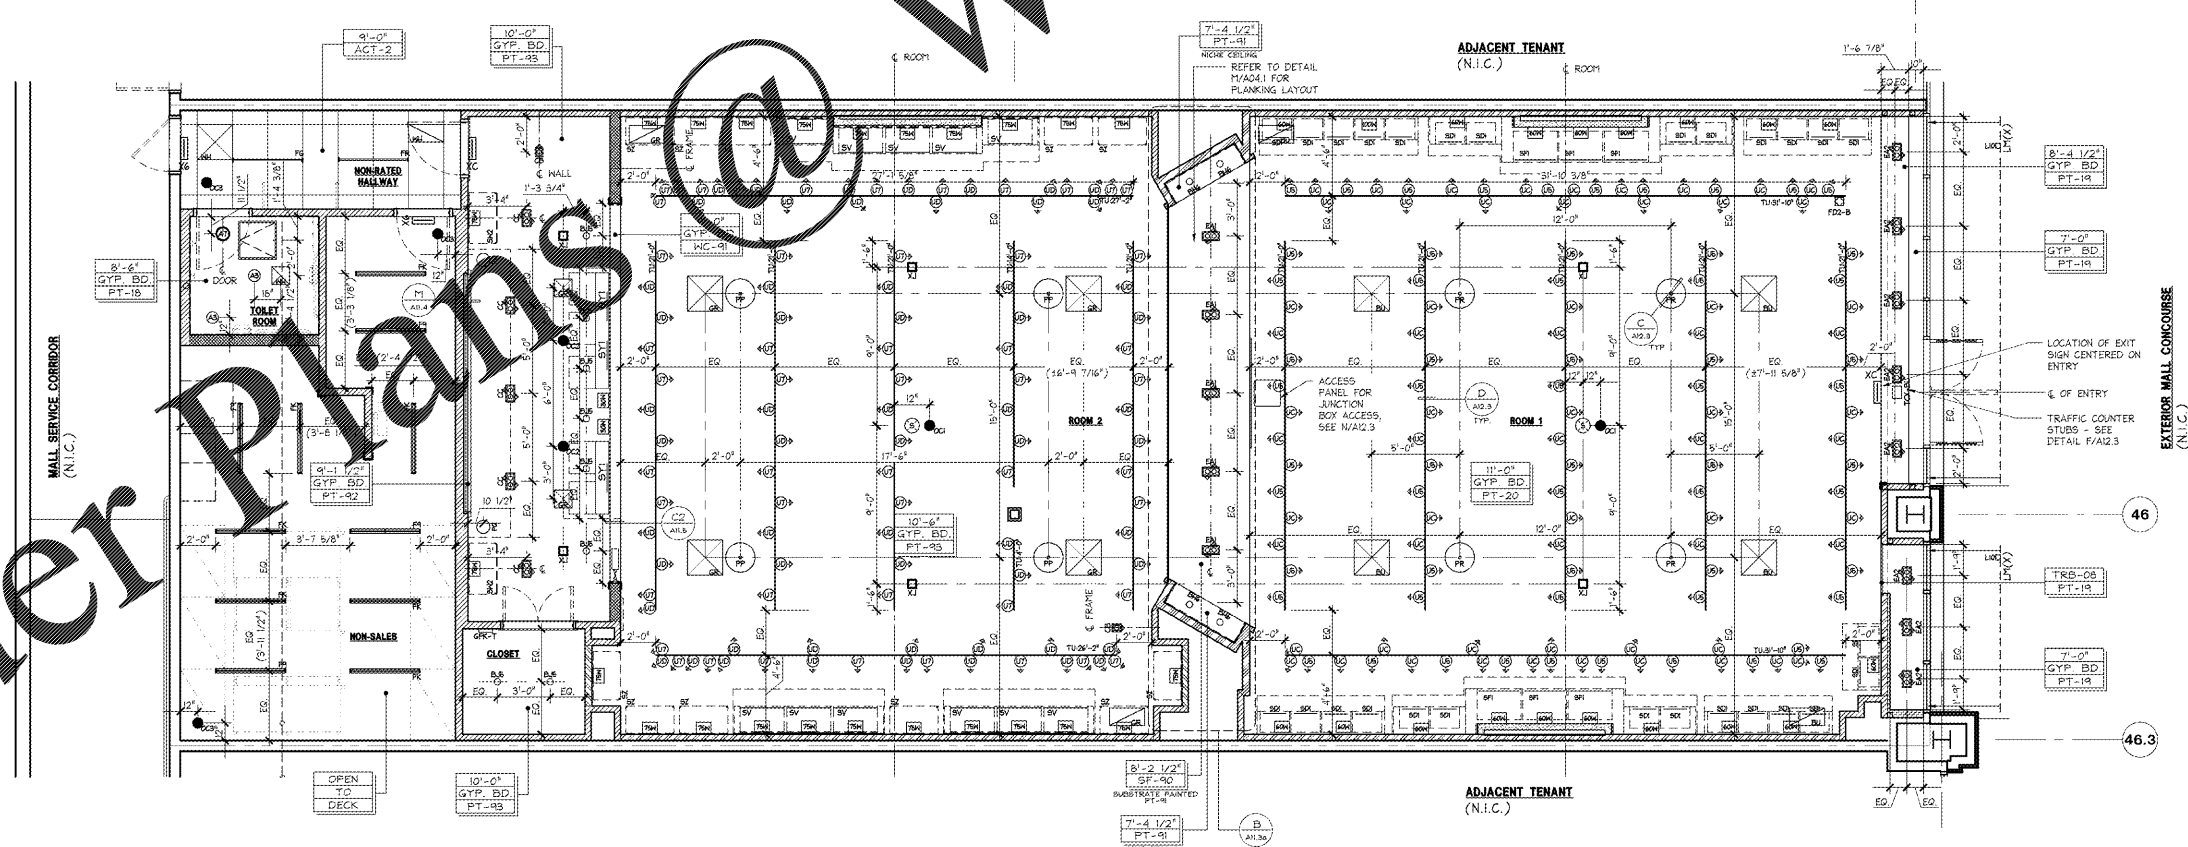

REFLECTED CEILING PLAN

1/4" = 1'-0"
42P-A041-A01-PLAN
A
03.04.18

PROJECT INFORMATION:
104.01.2445.01
BATH & BODY WORKS
CHARLOTTE PREMIUM OUTLETS
5404 NEW FASHION WAY
CHARLOTTE, NC 28278

SCOPE: TYPE: BBW ES / WBC 2018
NEW PACKAGE LOCATION: 0010107078 I/E PROJECT #:
USBC PROJECT #:

REVISIONS:

DATE ISSUED: 03/13/18
DESIGNED BY: SO
DRAWN BY: SP
CHECKED BY: JMH

REFLECTED CEILING PLAN

DRAWING NUMBER:
A04.1

Order Plans @

WWW.LDILine.com