



SEAL:  
 THIS DOCUMENT IS **NOT FOR CONSTRUCTION**  
 UNLESS THE ARCHITECT OR ENGINEER'S  
 SIGNATURE AND SEAL APPEAR BELOW.

NOT FOR  
 CONSTRUCTION

**BID SET**  
 04-10-18

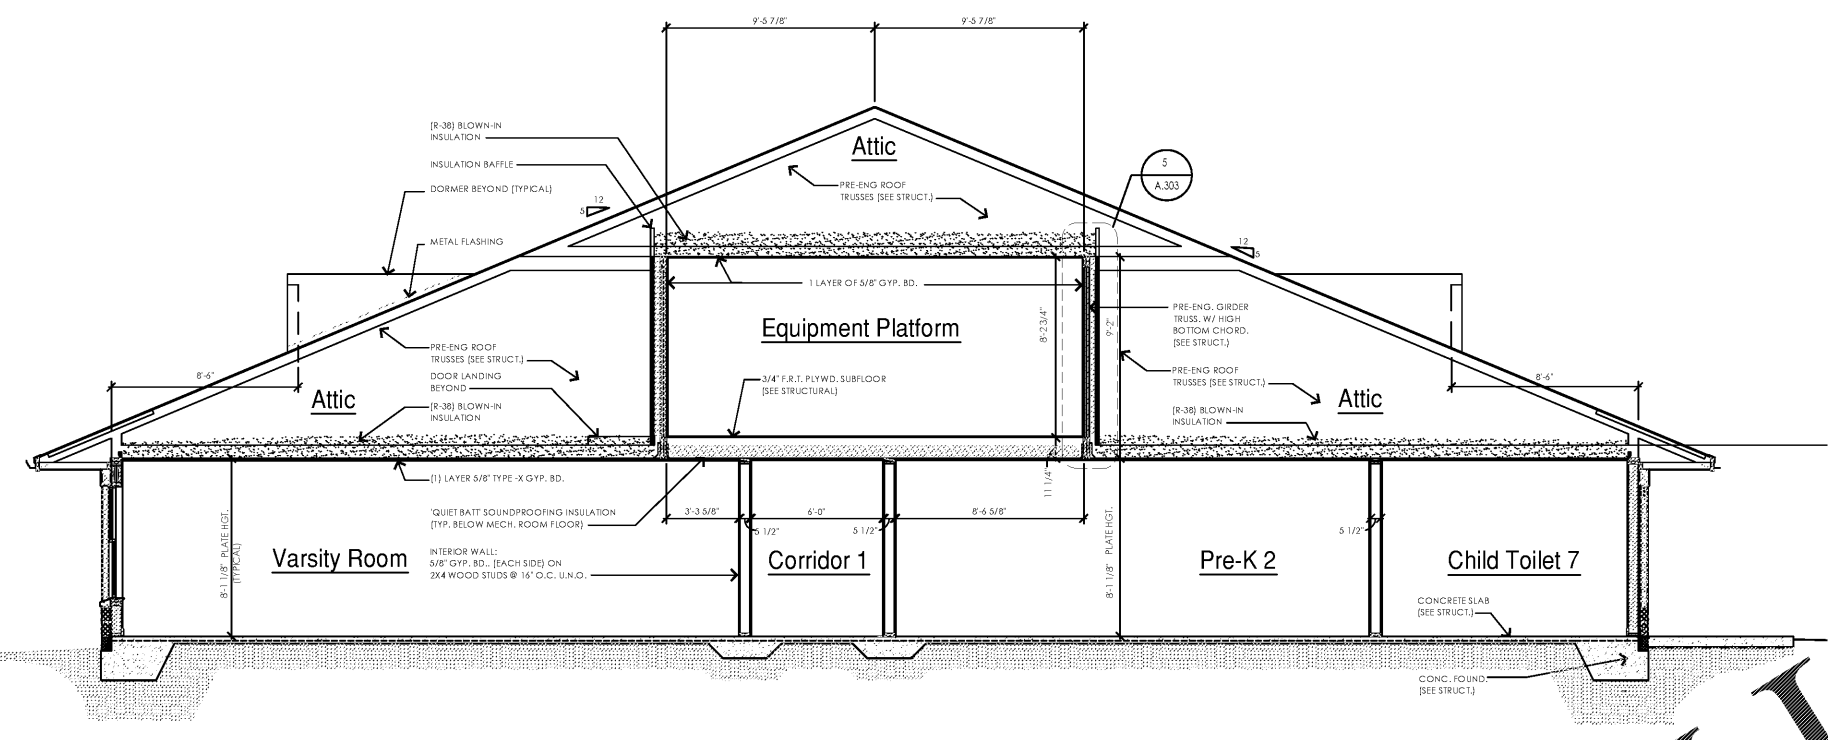


**A**  
 A.300 Building Section  
 Scale: 1/4" = 1'-0"

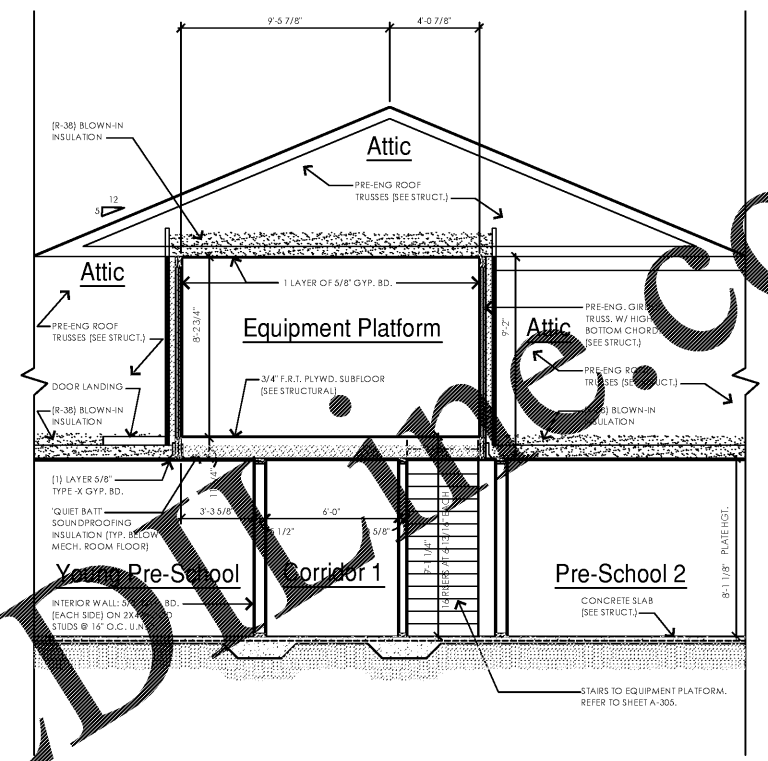

**B**  
 A.300 Partial Building Section  
 Scale: 1/4" = 1'-0"

**NOTE:**  
 1. PROVIDE DRAFTSTOPPING AS REQUIRED BY CODE IN ATTIC SPACE (SEE ROOF PLAN SHEET A-104 & DETAIL SHEET A-305).  
 2. FIRESTOPPING SHALL BE INSTALLED PER CODE  
 3. THE INTEGRITY OF ALL FIRESTOPPING AND DRAFTSTOPPING SHALL BE CONTINUOUSLY MAINTAINED.  
 4. FIRESTOPPING SHALL OCCUR AT ALL INTERSECTIONS BETWEEN VERTICAL AND HORIZONTAL SPACES PER CODE

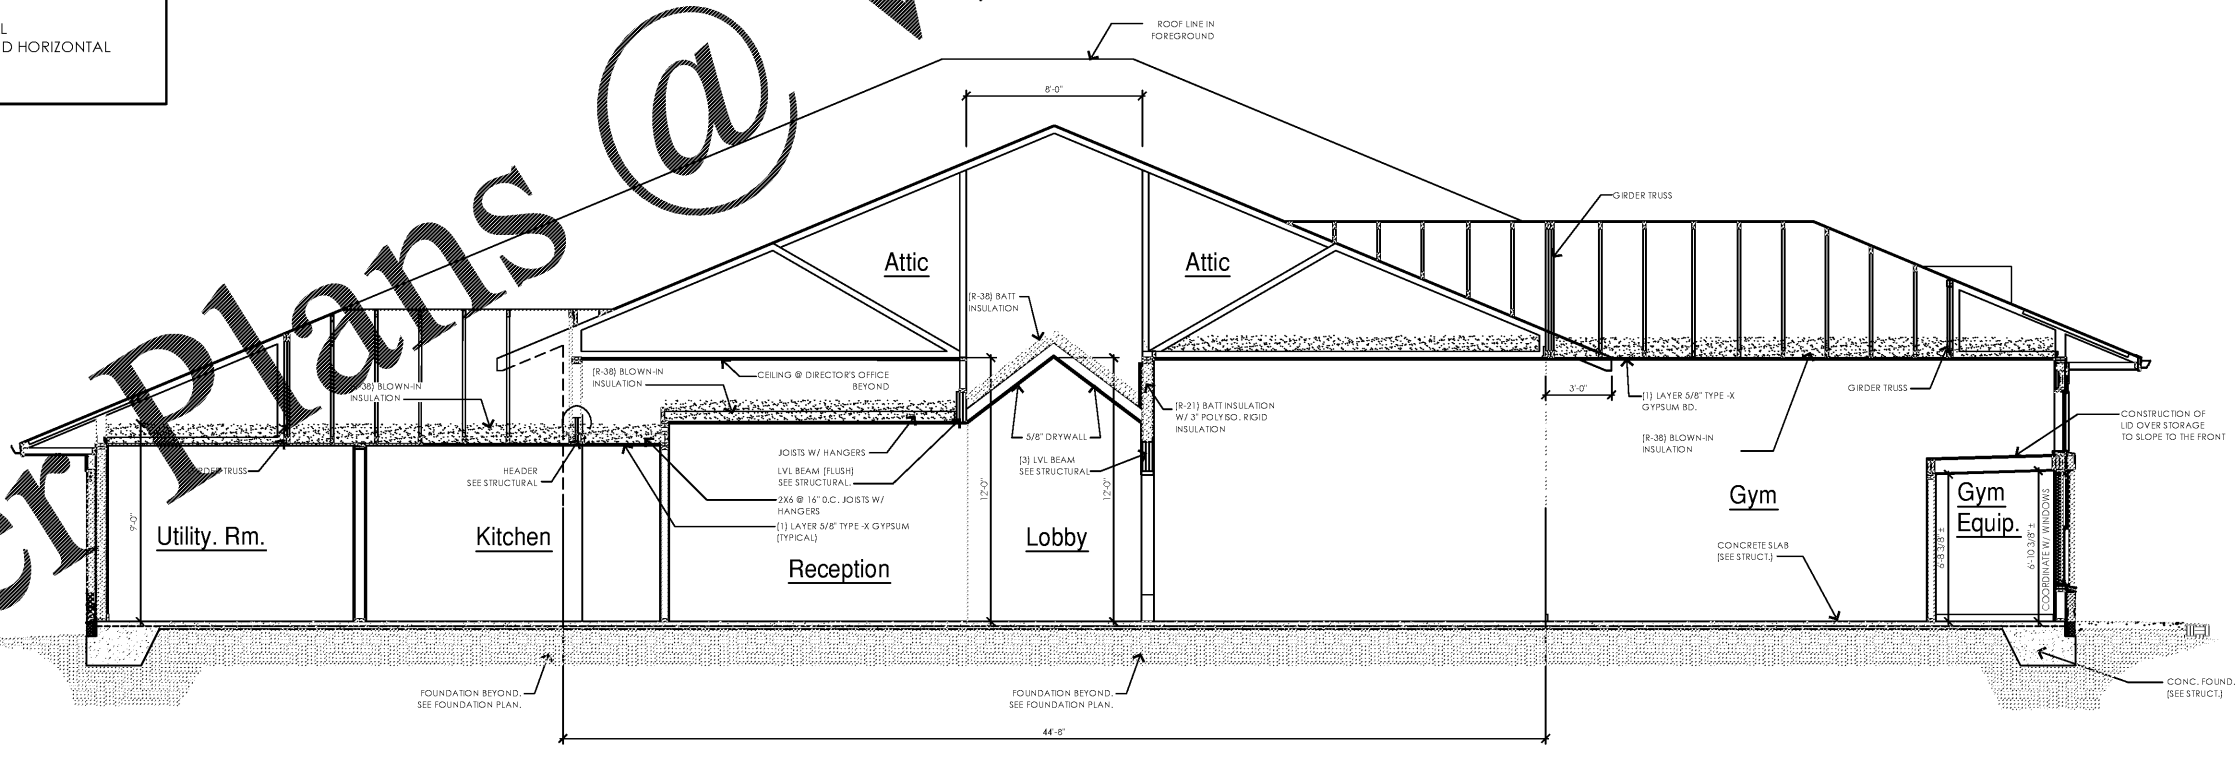

**C**  
 A.300 Partial Building Section  
 Scale: 1/4" = 1'-0"

NO.	DATE	REMARKS



**RAINBOW CHILD CARE CENTER**  
 C - PROTOTYPE  
 2609 W. LAKE MARY BLVD.  
 LAKE MARY, FL 32746

PROJECT NO: 2017.0250  
 DATE: 12.22.17

**A.300**  
 BUILDING SECTIONS

CHECKED: RC DRAWN: JC

Order Plans @ WWW.LDLINE.COM