

- NOTE:**
1. PROVIDE DRAFTSTOPPING AS REQUIRED BY CODE IN ATTIC SPACE (SEE ROOF PLAN SHEET A-104 & DETAIL SHEET A-305).
 2. FIRESTOPPING SHALL BE INSTALLED PER CODE
 3. THE INTEGRITY OF ALL FIRESTOPPING AND DRAFTSTOPPING SHALL BE CONTINUOUSLY MAINTAINED.
 4. FIRESTOPPING SHALL OCCUR AT ALL INTERSECTIONS BETWEEN VERTICAL AND HORIZONTAL SPACES PER CODE

NOT FOR CONSTRUCTION

BID SET
 04-10-18

NO.	DATE	REMARKS
REVISIONS		




RAINBOW CHILD CARE CENTER
 C - PROTOTYPE
 2609 W. LAKE MARY BLVD.
 LAKE MARY, FL 32746


PROJECT NO: 2017.0250
 DATE: 12.22.17

A.301
 BUILDING SECTIONS


CHECKED: RC DRAWN: JC

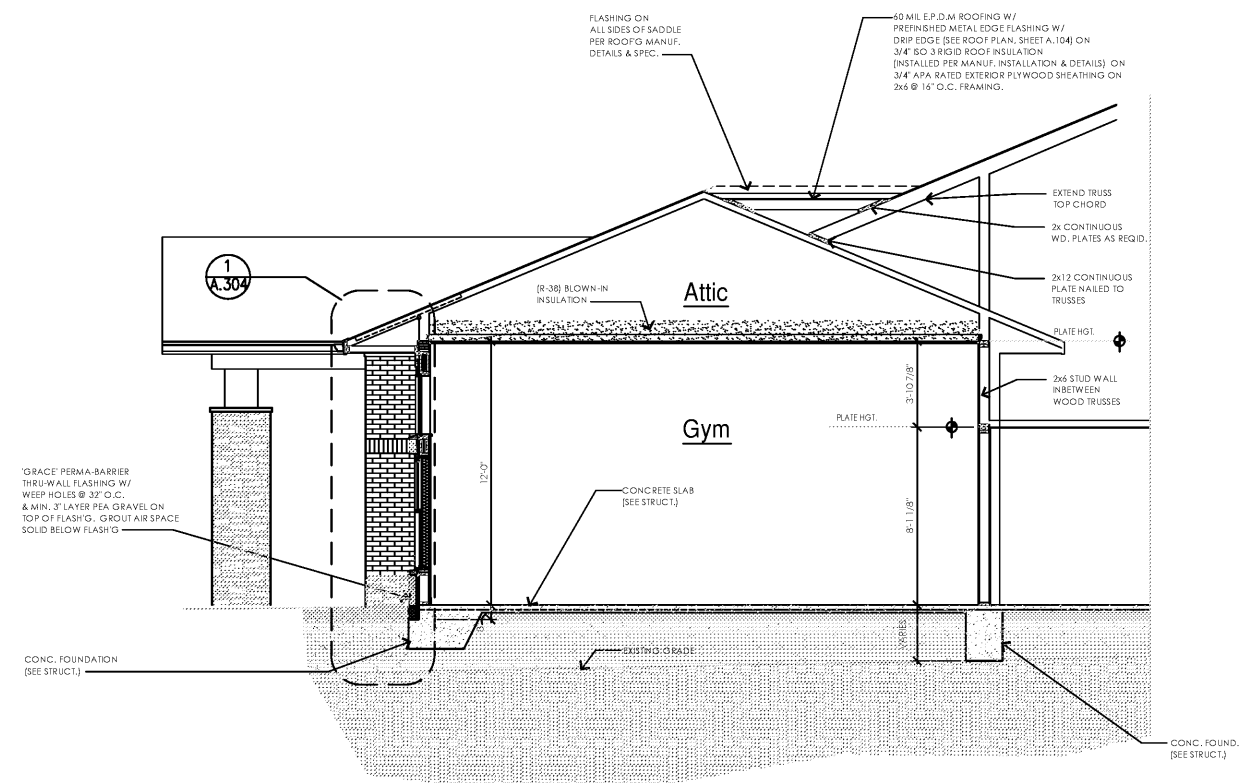


D
A.301
 Partial Building Section
 Scale: 1/4" = 1'-0"

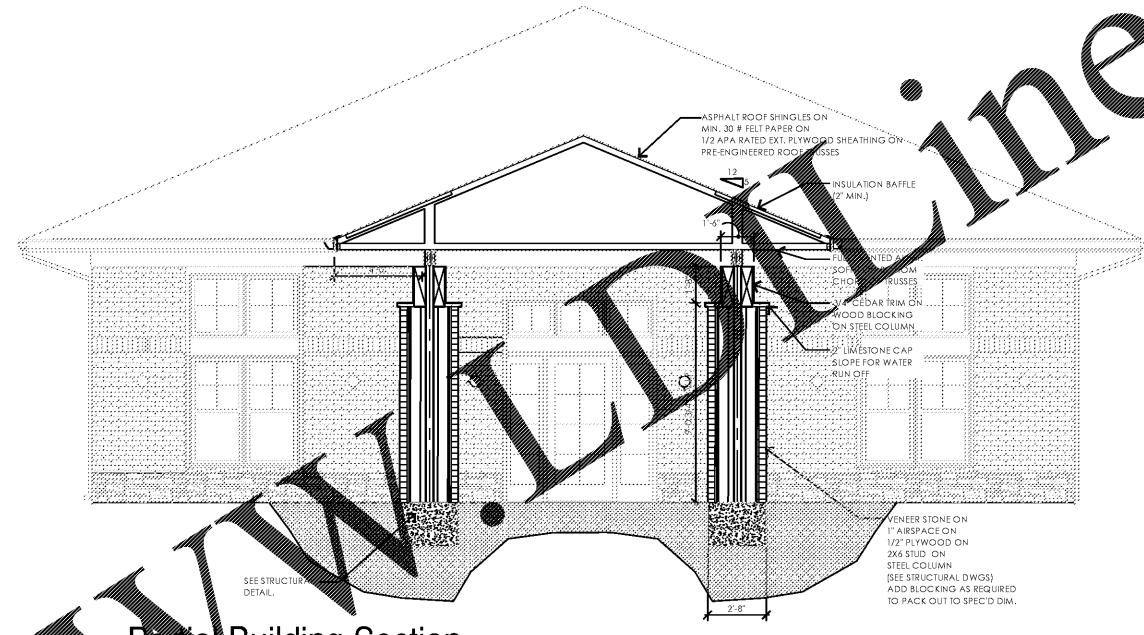

A.301
 Partial Building Section
 Scale: 1/4" = 1'-0"

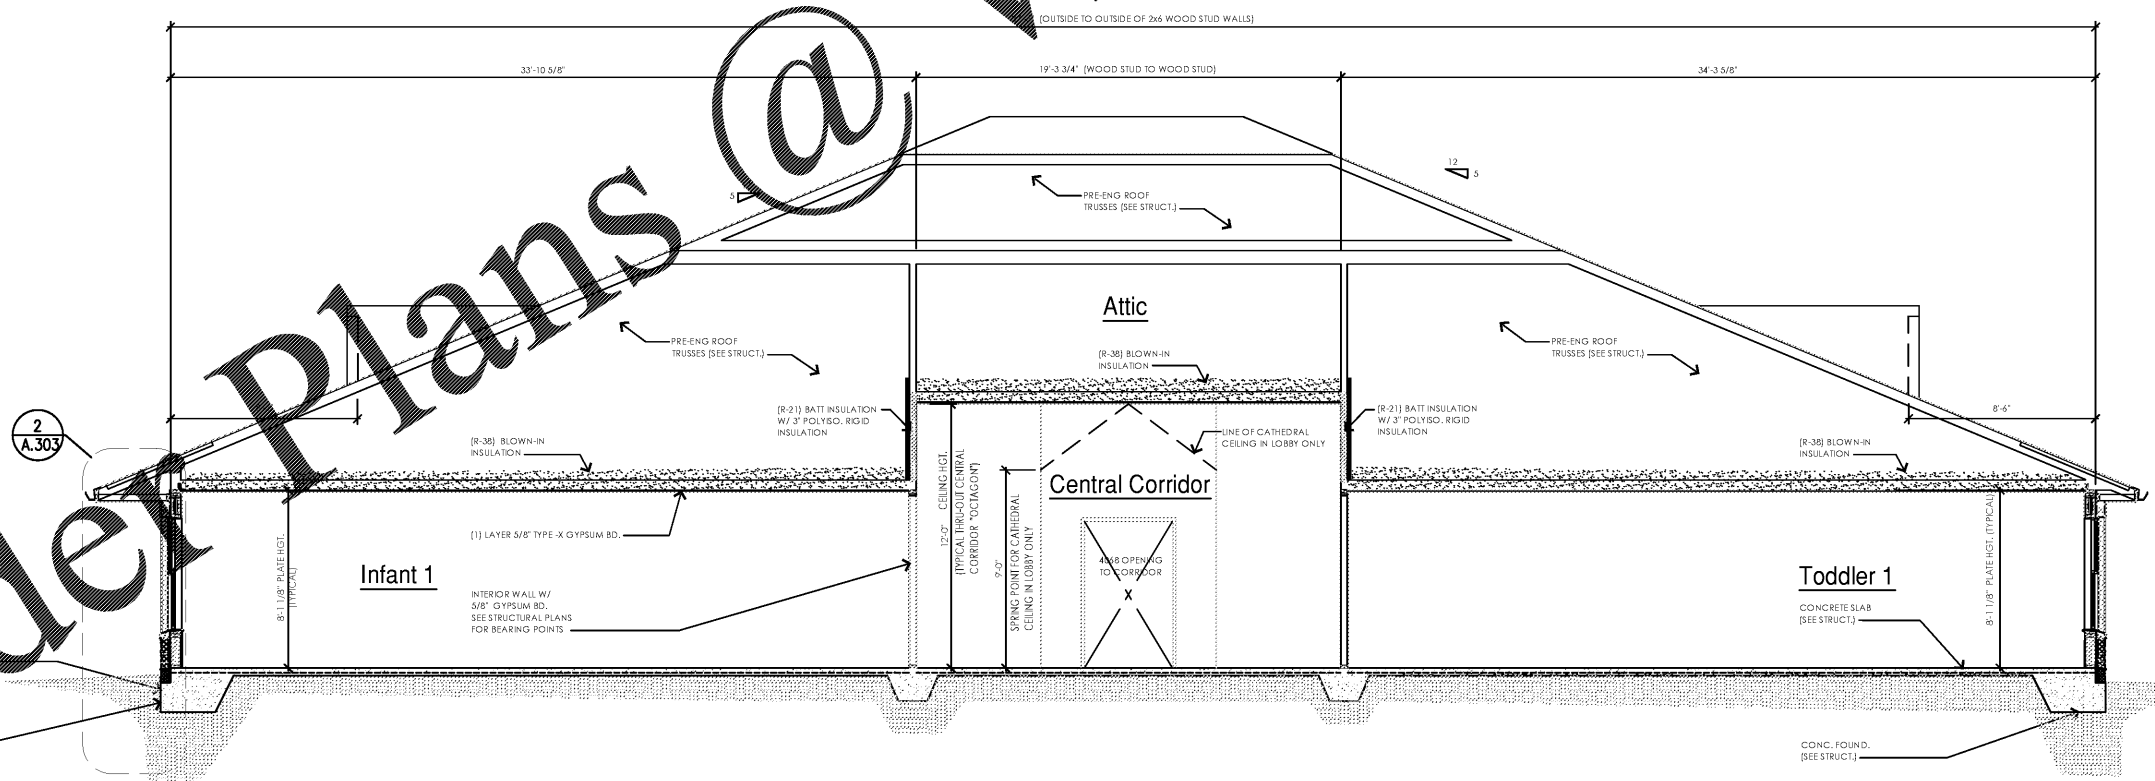

F
A.301
 Building Section
 Scale: 1/4" = 1'-0"

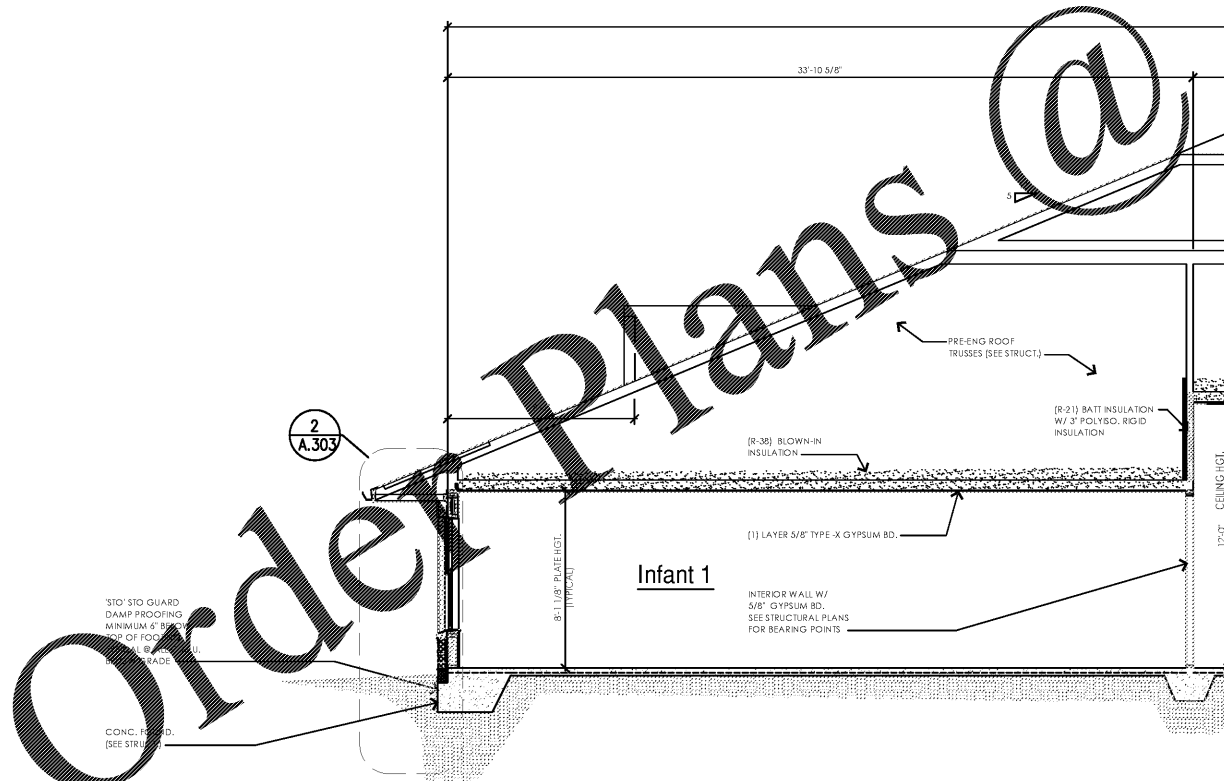

Order Plans @

WWW.LDOnline.com

INTERPLAN, LLC RESERVE COPYRIGHT & OTHER RIGHTS RESTRICTING REUSE OF THESE DOCUMENTS TO THE ORIGINAL SITE OR PURPOSE FOR WHICH THEY WERE PREPARED. REPRODUCTIONS, CHANGES OR ASSIGNMENTS ARE PROHIBITED.