


Building Section

Scale: 1/4" = 1'-0"

- NOTE:**
1. PROVIDE DRAFTSTOPPING AS REQUIRED BY CODE IN ATTIC SPACE (SEE ROOF PLAN SHEET A-104 & DETAIL SHEET A-305).
  2. FIRESTOPPING SHALL BE INSTALLED PER CODE
  3. THE INTEGRITY OF ALL FIRESTOPPING AND DRAFTSTOPPING SHALL BE CONTINUOUSLY MAINTAINED.
  4. FIRESTOPPING SHALL OCCUR AT ALL INTERSECTIONS BETWEEN VERTICAL AND HORIZONTAL SPACES PER CODE

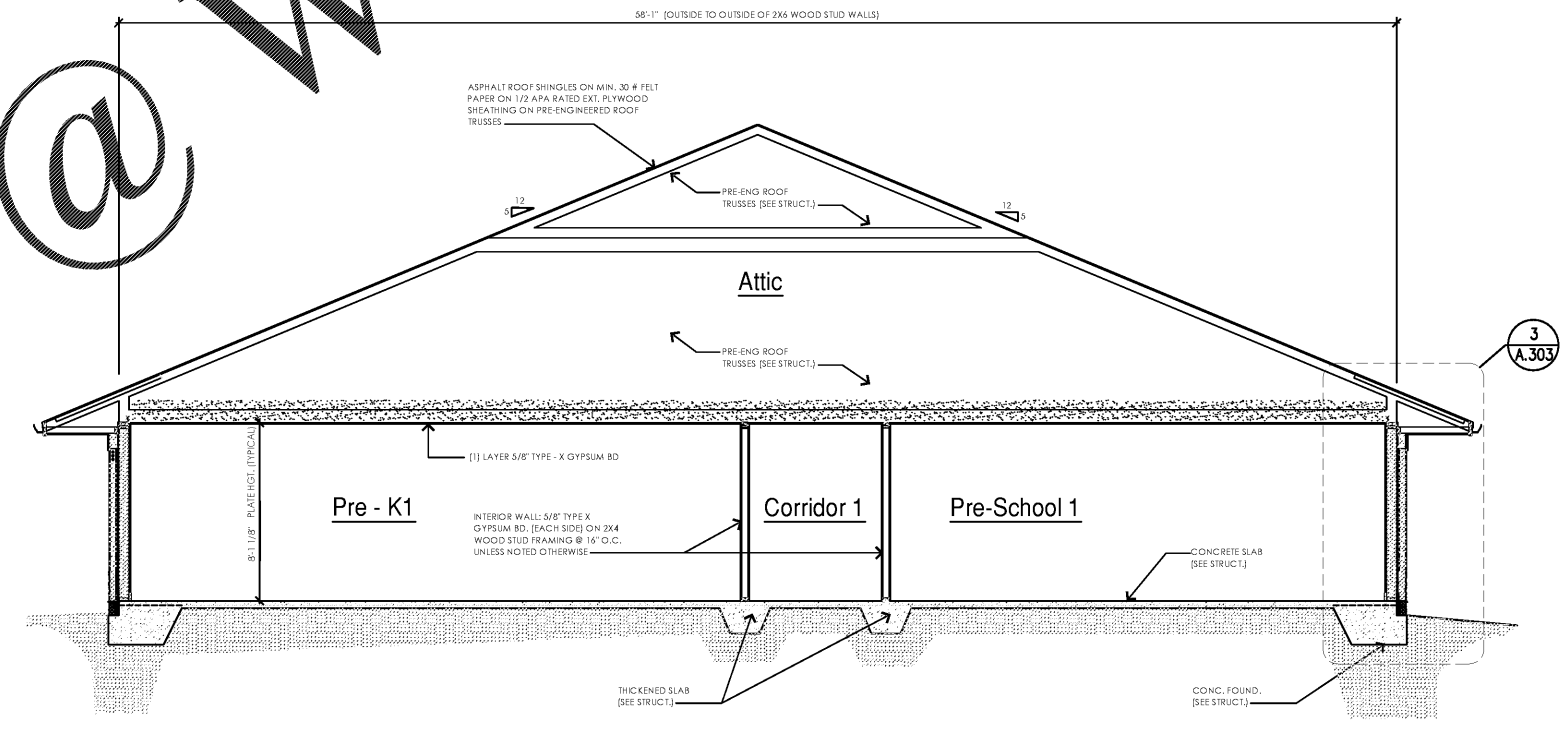

Building Section

Scale: 1/4" = 1'-0"

Order Plans @ WWW.LDOnline.com

NO.	DATE	REMARKS



**RAINBOW CHILD CARE CENTER**  
C - PROTOTYPE  
2609 W. LAKE MARY BLVD.  
LAKE MARY, FL 32746

PROJECT NO: 2017.0250  
DATE: 12.22.17

**A.302**  
BUILDING SECTIONS

CHECKED: RC DRAWN: JC

INTERPLAN, LLC. RESERVE COPYRIGHTS & OTHER RIGHTS RESTRICTING THESE DOCUMENTS TO THE ORIGINAL SITE OR PURPOSE FOR WHICH THEY WERE PREPARED. REPRODUCTIONS, CHANGES OR ASSIGNMENTS ARE PROHIBITED. COPYRIGHT © 2018