

NO.	DATE	REVISIONS
1	03.07.18	FIRE DEPT COMMENTS




RAINBOW CHILD CARE CENTER
C - PROTOTYPE
2609 W. LAKE MARY BLVD.
LAKE MARY, FL 32746

PROJECT NO: 2017.0250
DATE: 12.22.17

E.102
ELECTRICAL PLAN - FIRE ALARM


CHECKED: AG DRAWN: DMS

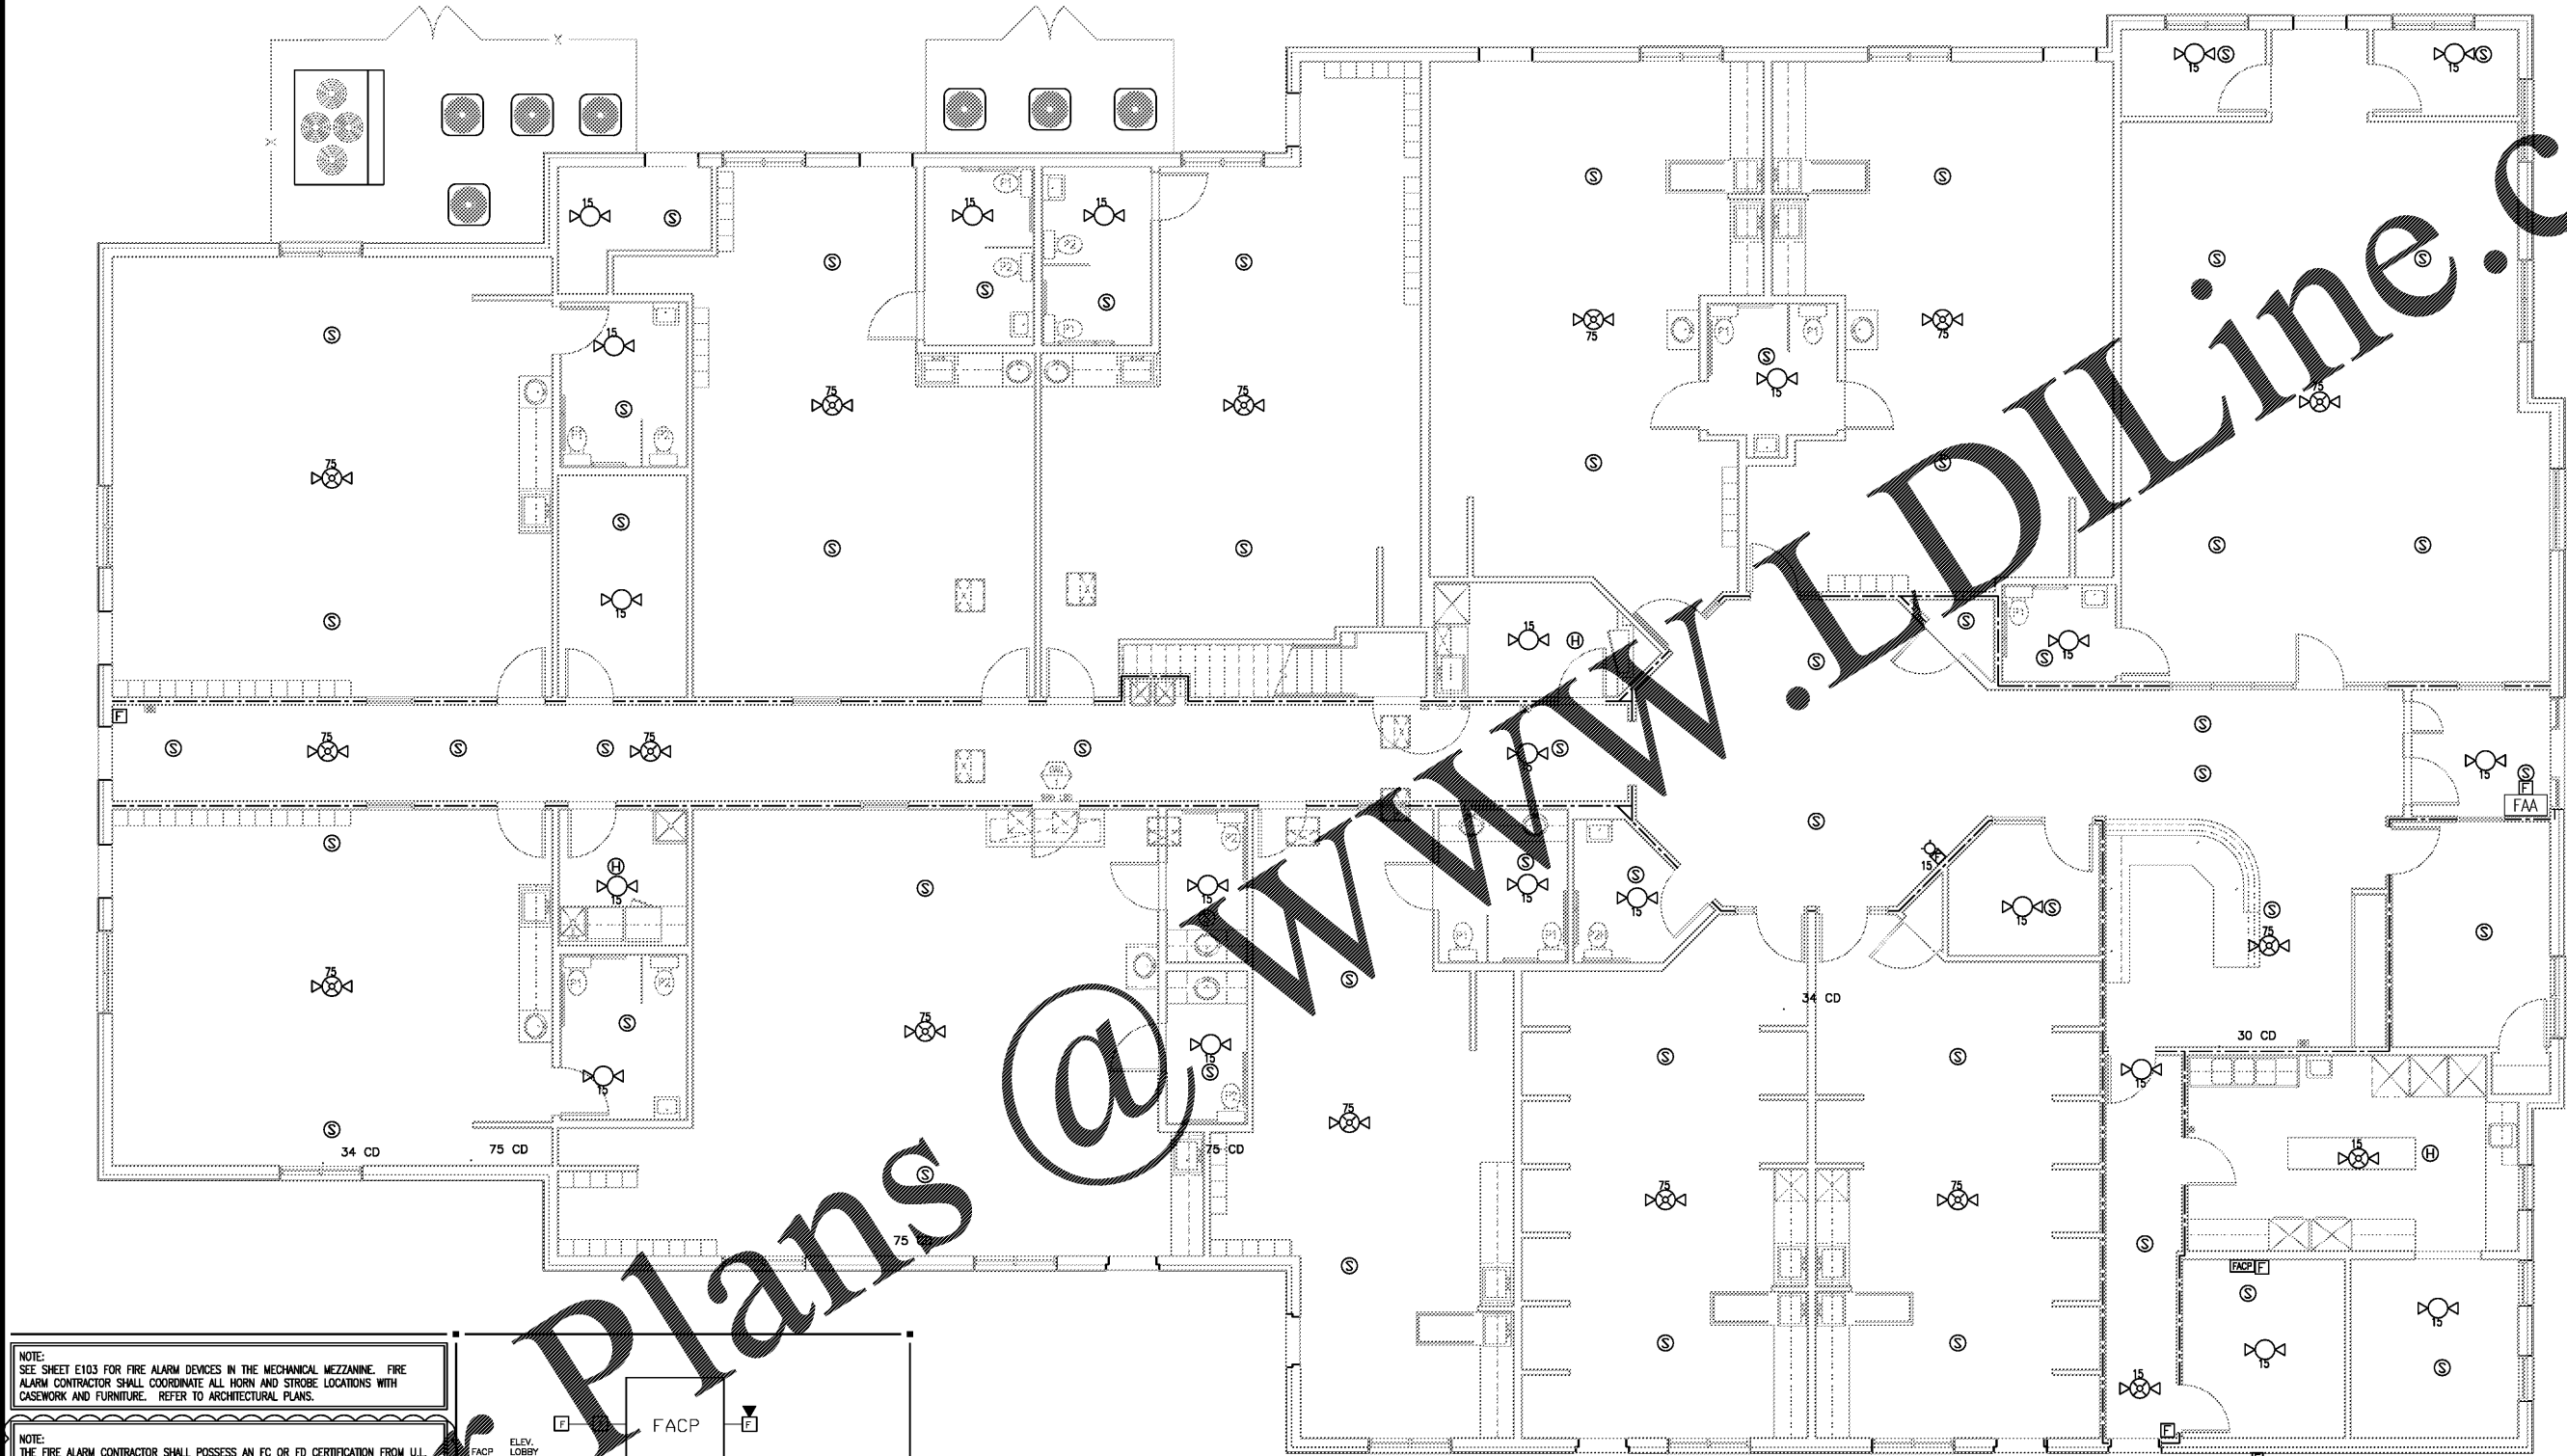

NOTE:
SEE SHEET E103 FOR FIRE ALARM DEVICES IN THE MECHANICAL MEZZANINE. FIRE ALARM CONTRACTOR SHALL COORDINATE ALL HORN AND STROBE LOCATIONS WITH CASEWORK AND FURNITURE. REFER TO ARCHITECTURAL PLANS.

NOTE:
THE FIRE ALARM CONTRACTOR SHALL POSSESS AN FC OR FD CERTIFICATION FROM U.L. OR E.T.L FOR CENTRAL STATION, AS REQUIRED BY CITY ORDINANCE 95.03(9).

NOTE:
THE CONTRACTOR'S FIRE ALARM ENGINEER, AS THE "DELEGATED ENGINEER" SHALL BE THE "ENGINEER OF RECORD" FOR THE FIRE ALARM SYSTEM AND SHALL PREPARE COMPLETE AND FINAL FIRE ALARM DESIGN DOCUMENTS WITH BATTERY CALCULATIONS, SIGNED AND SEALED, AS DEFINED BY THE F.P.C. 2016-12-2008 AND SHALL SUBMIT REQUIRED DOCUMENTATION TO THE ARCHITECT FOR REVIEW BY THEIR "PROFESSIONAL ENGINEER" OR STAFF TO REVIEW FOR DESIGN CRITERIA. UPON APPROVAL THE CONTRACTOR SHALL SUBMIT SIGNED AND SEALED DOCUMENTS TO THE AHU FOR REVIEW AND APPROVAL.

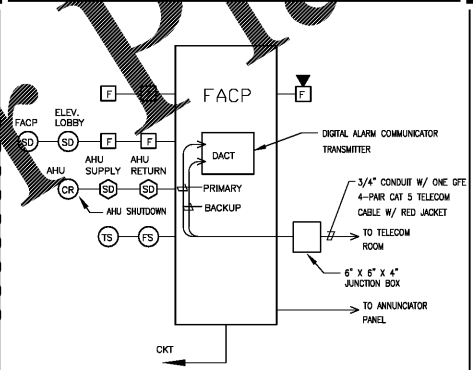

1 DETAIL - FIRE ALARM RISER NTS

ELECTRICAL PLAN - FIRE ALARM

3/16" = 1'-0"



www.LDLine.com

INTERPLAN LLC RESERVE COPYRIGHT & OTHER RIGHTS RESTRICTING THESE DOCUMENTS TO THE ORIGINAL SET OR PORTION FOR WHICH THEY WERE PREPARED. REPRODUCTIONS, CHANGES OR ASSIGNMENTS ARE PROHIBITED.

COPYRIGHT © 2018