


STANDARD INTERIOR ELEVATIONS

SCALE: 1/4" = 1'-0"

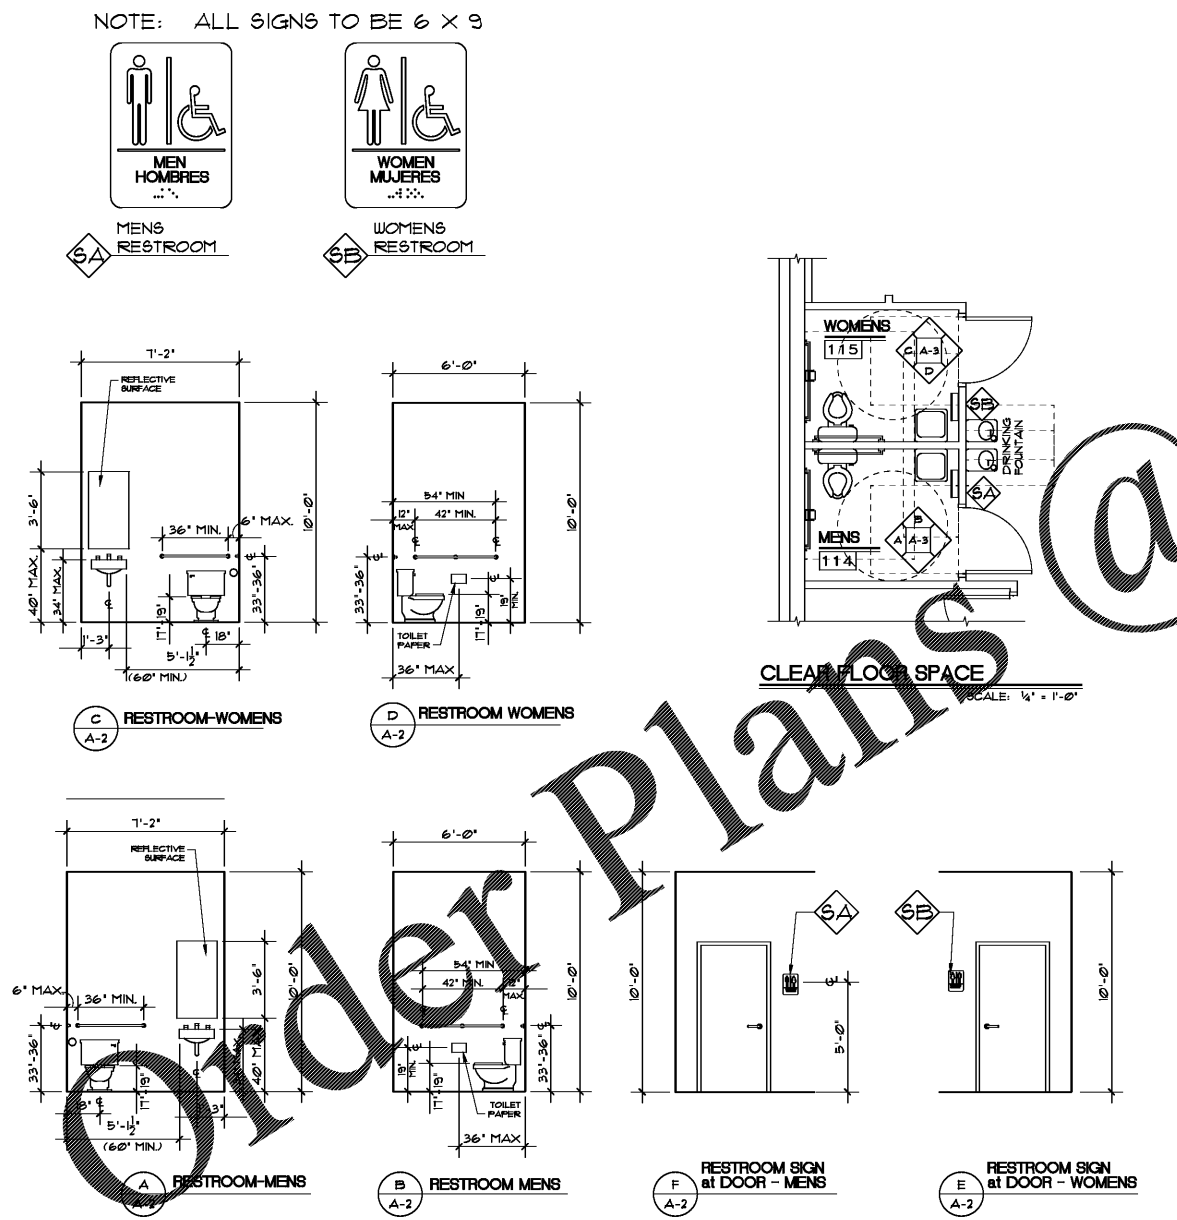

INTERIOR ELEVATIONS

SCALE: 1/4" = 1'-0"

REFLECTIVE CEILING SCHEDULE

TAG	TYPE	STYLE	HEIGHT	NOTES
A	A.C.T.	2X2 ACOUSTICAL	10'-0"	5" SOUND INSUL. A.B.V.
B	A.C.T.	2X2 ACOUSTICAL	10'-0"	
C	A.C.T.	2X2 ACOUSTICAL	10'-0"	NON-PORUS
D	DRY WALL	METAL DECK	8'-0"	
E	A.C.T.	2X2 ACOUSTICAL	12'-0"	
F	A.C.T.	2X2 ACOUSTICAL	Vault from 10' to 12'	


A.C.T. = ACOUSTICAL TEGULAR CEILING TILE
A.C.T. = ACOUSTICAL CEILING TILE
D-W = DRY WALL

REFLECTIVE CEILING LEGEND

EXIT	LIGHTED EXIT SIGN	W	WALL MOUNTED LIGHT FIXTURE
□	INCANDESCENT LIGHT RECEASED	○	WALL SCONCE
⚡	EMERGENCY LIGHT	⊕	CLG. OUTLET
⊕	TRACK LIGHTING (DIMMABLE) LIGHTOLIER 26000UH 4 26030UH 120V/35W	⊕	CLG. T.V. OUTLET
A	2X2 FLOURESCENT DROP-IN LIGHTOLIER G08221UNVH 2-TIU T-8 120V/34W (OPTION: DIMMABLE FOR SOME ROOMS - VERIFY WITH ELECTRICAL PLAN)	⊕	CLG. DATA OUTLET
⊕		⊕	EXHAUST FAN
⊕		⊕	HVAC SUPPLY
⊕		⊕	HVAC SUPPLY
⊕		⊕	HVAC RETURN

REFLECTIVE CEILING PLAN

SCALE: 1/4" = 1'-0"

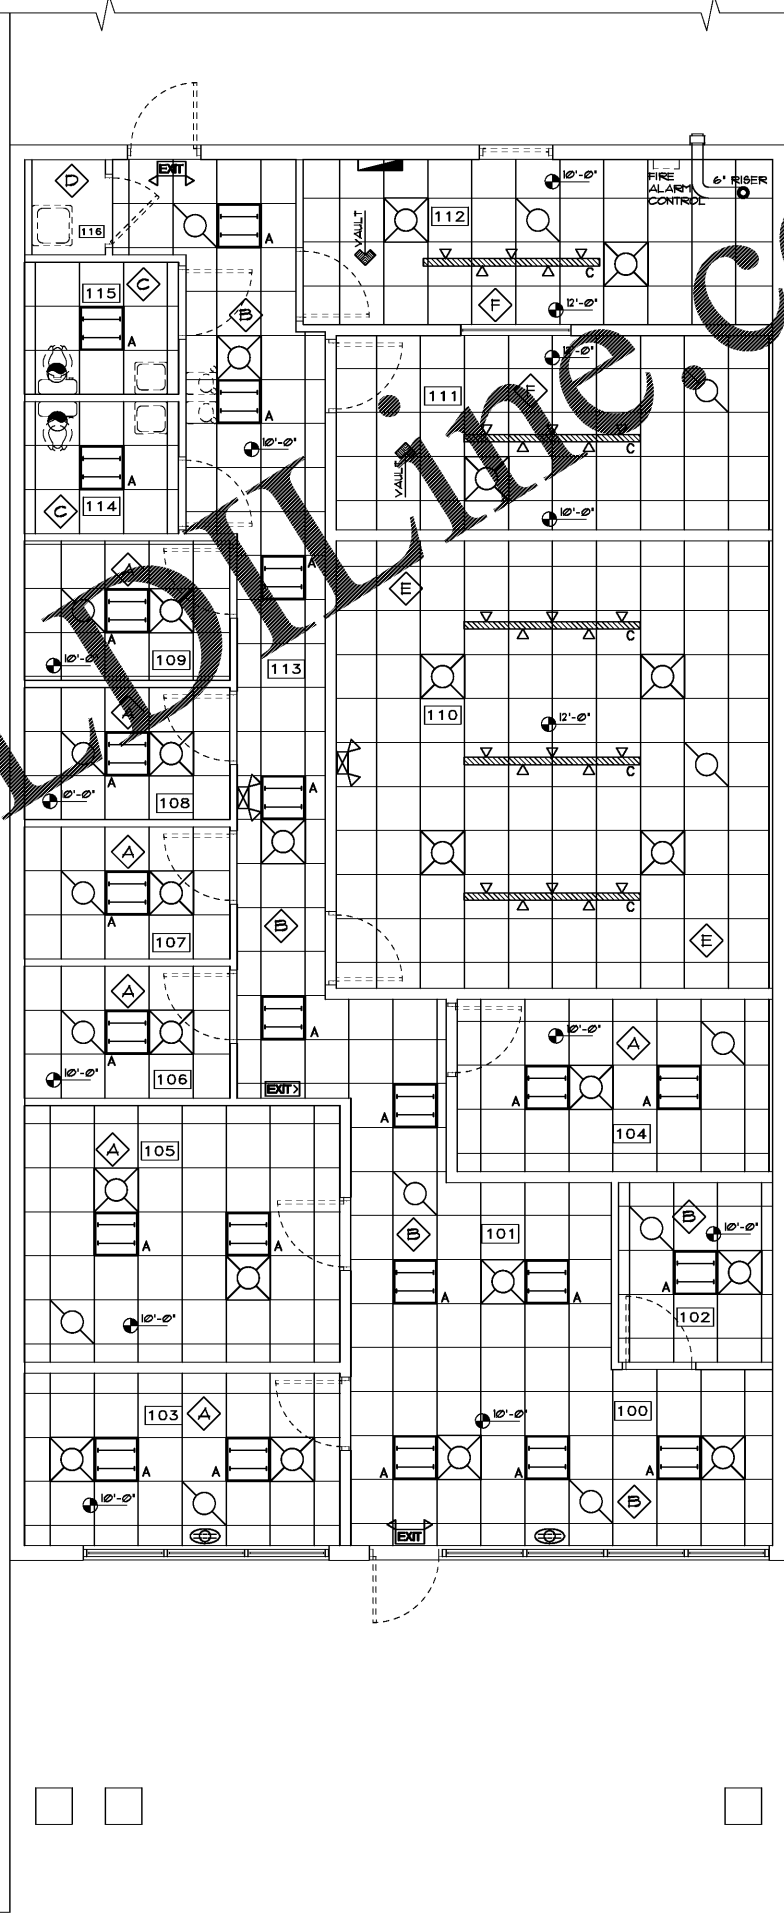

DESIGNER HEREBY EXPRESSLY RESERVES HIS COPYRIGHT AND OTHER PROPERTY RIGHTS IN THESE PLANS. THESE PLANS, DRAWINGS AND OTHER PROPERTY RIGHTS ARE NOT TO BE REPRODUCED, CHANGED OR COPIED IN ANY FORM OR MANNER WHATSOEVER, NOR ARE THEY TO BE ASSIGNED TO ANY PARTY WITHOUT FIRST OBTAINING THE EXPRESSED WRITTEN PERMISSION AND SIGNATURE OF GERALD R. GROSS ARCHITECT.

REVISIONS

VERSION - 5

REFLECTIVE CEILING

BACH TO ROCK

Lake Mary Florida

DIGITAL SIGNATURE

PROJECT NO.: 60005998

DATE: 2 FEB 2016

DRAWN BY: TFL

SHEET NO.: A-3

GERALD R. GROSS
 ALL. F.A.A.
 205T North Ibis Drive
 Bristle Breezes, Florida 33453
 386-574-9088
 FL REG. ARCHITECT
 NO. AR0005998

GERALD R. GROSS
 ALL. F.A.A.
 205T North Ibis Drive
 Bristle Breezes, Florida 33453
 386-574-9088
 FL REG. ARCHITECT
 NO. AR0005998