


SYM.	MANUFACTURER	CATALOG NUMBER	LAMPS	MTG.	REMARKS
BE	LITHONIA	F2018 20316 A12125 120 GEB EL	(2) F8032/741, T8	RECESSED	2 LAMP, 2'x2' TROFFER WITH 0.125" ACRYLIC LENS, ENERGY SAVING LAMPS, ELECTRONIC BALLAST, FLANGE KIT, AND 1100 LUMEN MINIMUM, 90 MIN. EMERGENCY BATTERY BALLAST. 120V.
B1	HALO	H1EF-CAT-110P	(2) 13W DOUBLE TUBE FLUORESCENT (741)	RECESSED	FLUORESCENT 9" SQUARE SHOWER LIGHT, WHITE TRIM WITH FROSTED LENS, ELECTRONIC BALLAST, WITH UL WET LABEL. 120V.
C	LITHONIA	C-232-120-GEB	(2) F032/741, T8	SURFACE OR CHAIN HUNG	2 LAMP 4" STRIP WITH ENERGY SAVING LAMPS, ELECTRONIC BALLAST. 120V.
CE	LITHONIA	C-232-120-GEB-EL	(2) F032/741, T8	SURFACE OR CHAIN HUNG	2 LAMP 4" STRIP WITH ENERGY SAVING LAMPS, ELECTRONIC BALLAST, AND 1100 LUMEN MINIMUM, 90 MIN. EMERGENCY BATTERY BALLAST. 120V.
D	ELITE	HVPL 1X32 E 120 6101 CL WH	(1) 32W TRIPLE TUBE FLUORESCENT (741)	RECESSED	6" VERTICAL MEDIUM BEAM COMPACT FLUORESCENT DOWNLIGHT WITH SPECULAR LOW IRIDESCENT REFLECTOR AND ELECTRONIC BALLAST. 120V.
DE	ELITE	HVPL 1X32 E 120 EMG1300 6101 CL WH	(1) 32W TRIPLE TUBE FLUORESCENT (741)	RECESSED	SAME AS TYPE "D" EXCEPT WITH 1300 LUMEN MINIMUM, 90 MIN. EMERGENCY BATTERY BALLAST. 120V.
D1	ELITE	HVPL 1X42 E 120 6101 CL WH	(1) 42W TRIPLE TUBE FLUORESCENT (741)	RECESSED	6" VERTICAL MEDIUM BEAM COMPACT FLUORESCENT DOWNLIGHT WITH SPECULAR LOW IRIDESCENT REFLECTOR AND ELECTRONIC BALLAST. UL DAMP LISTED. 120V.
D2	VOIGT LIGHTING	W740-4-51806 D1 WH SU GW 120	(5) F8032/741, T8	RECESSED	4" DIAMETER ROUND FLUORESCENT ACRYLIC LENS, WITH WHITE WHITE FINISH AND ELECTRONIC BALLAST. UL DAMP LISTED. 120V.
F	ALERA LIGHTING	CY-4-218-PERF-MM-E120-MM	(2) F032/741, T8	SURFACE ON WALL, REFER TO ARCHITECT FOR MOUNTING HEIGHT	DECORATIVE WALL MOUNTED FIXTURE. UL DAMP LISTED. 120V.
FE	ALERA LIGHTING	CY-4-218-PERF-MM-E120-MM-EL	(2) F032/741, T8	SURFACE ON WALL, REFER TO ARCHITECT FOR MOUNTING HEIGHT	SAME AS TYPE "F" EXCEPT WITH 1100 LUMEN MINIMUM, 90 MIN. EMERGENCY BATTERY BALLAST. 120V.
K	KEMALL	H12127D PP CC 50L35K 120	LED BY MFR.	SURFACE MTD UNDER CANOPY	50-WATT LED FIXTURE MOUNTED UNDER CANOPY WITH TAMPER RESISTANT SCREWS/SCREW DRIVER UL WET LISTED. VERIFY COLOR WITH ARCHITECT. 120V.
W4	OXYGEN LIGHTING	2-705-6	(2) 19W QUAD TUBE FLUORESCENT	SURFACE ON WALL, REFER TO ARCHITECT FOR MOUNTING HEIGHT	SQUARE DECORATIVE WALL MOUNTED FLUORESCENT FIXTURE. UL WET LISTED FOR WET LOCATION. 120V.
X	ELITE	ELX-606 R W 1 CL	LED BY MFR.	UNIVERSAL MOUNT	UNIVERSAL LED SINGLE FACE EXIT SIGN, EDGE LITE CLEAR PLASTIC WITH RED LETTERS AND 90 MINUTE EMERGENCY BATTERY PACK. 120V.

NOTE: EC SHALL PROVIDE ADD ALT. FOR LED OPTION OF LIGHT FIXTURES NOTED IN SCHEDULE.

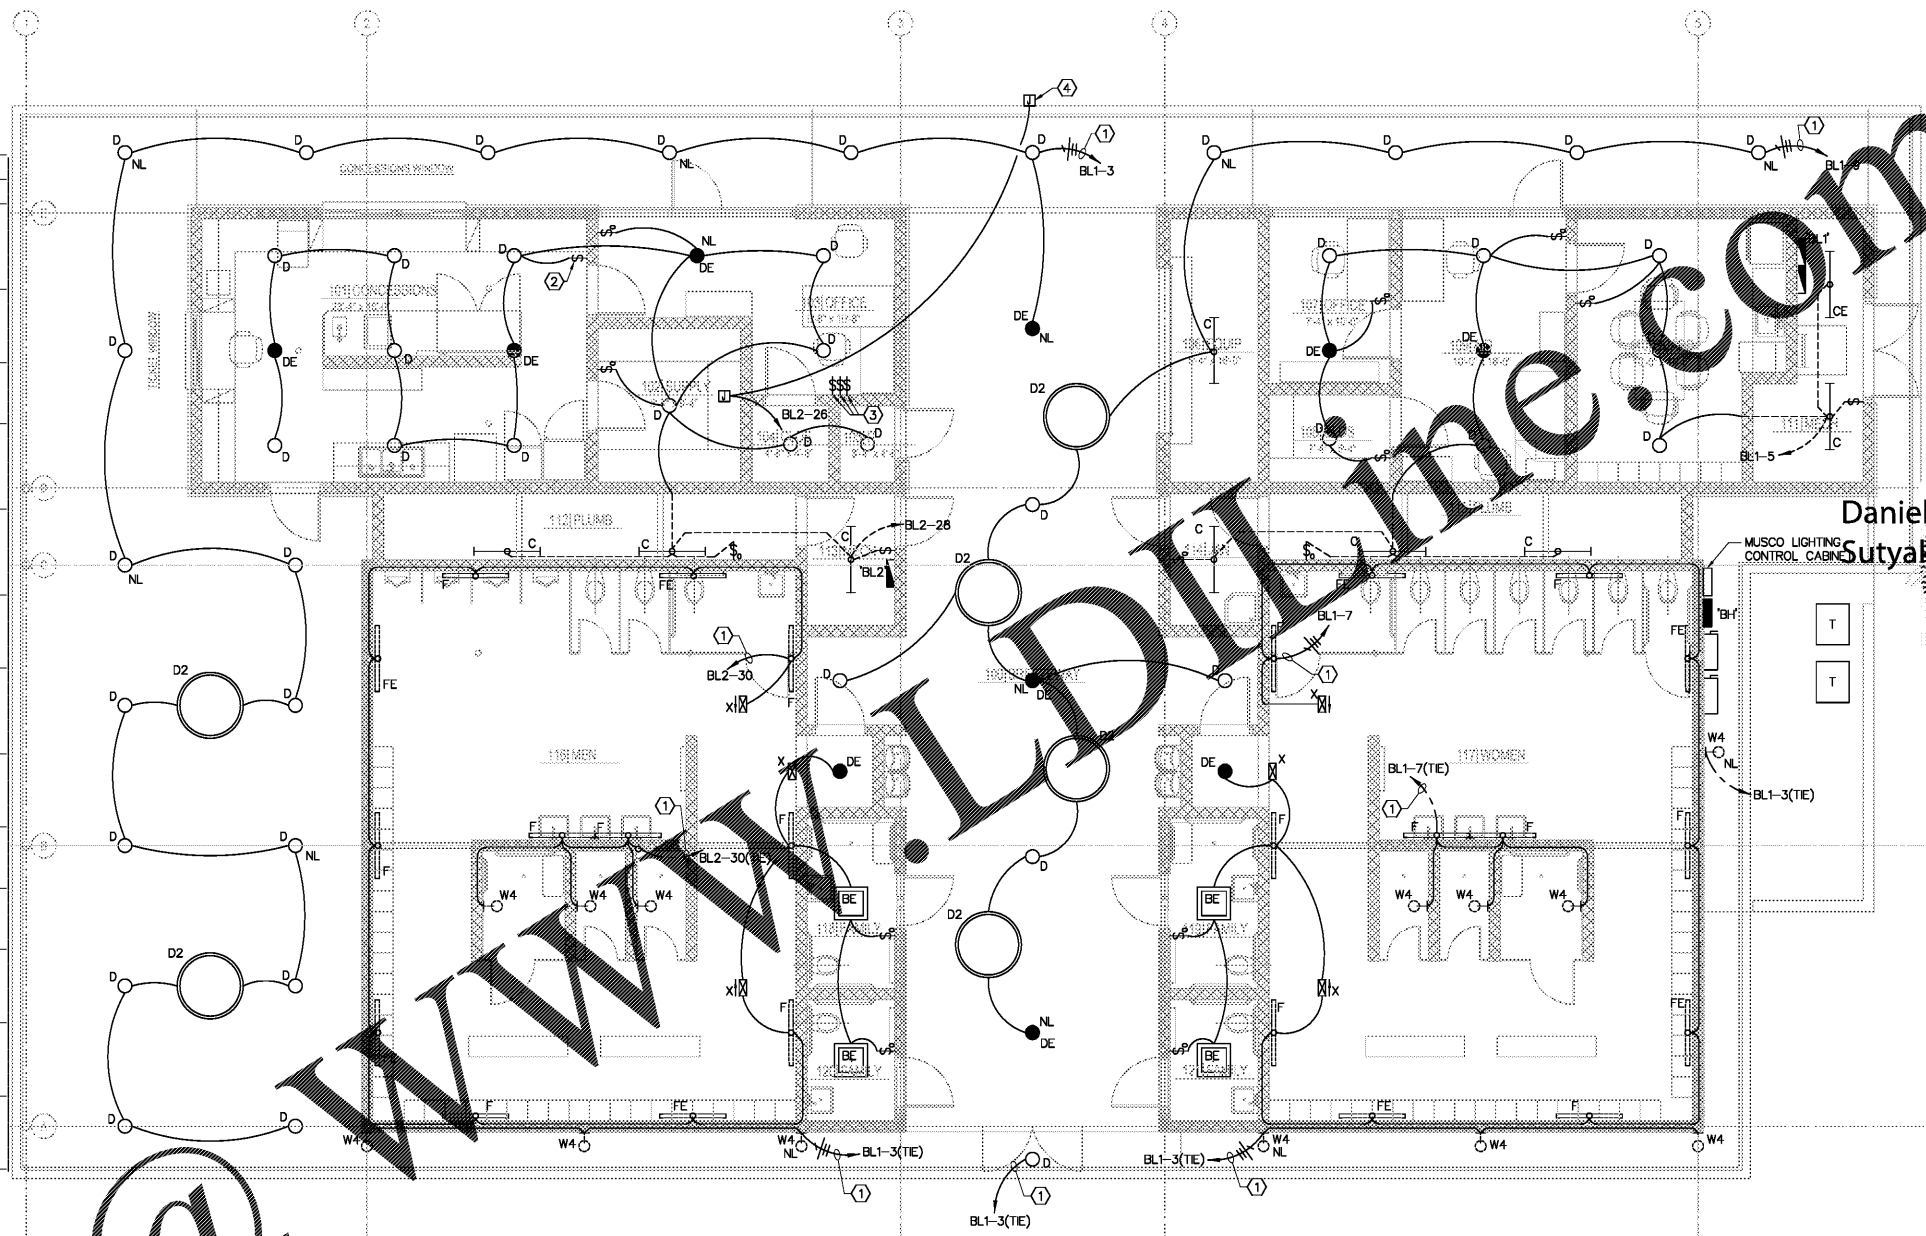

LIGHTING PLAN
SCALE: 3/16"=1'-0"

- NOTES
- ROUTE HOMERUN THROUGH LIGHTING CONTACTOR. REFER TO LIGHTING CONTACTOR SCHEDULE AND LIGHTING CONTROL DIAGRAM SHEET EB-4.0.
 - PROVIDE DIGITAL TIMER SWITCH (WATTSTOPPER TS-400 OR EQUIVALENT) FOR LIGHTING CONTROL THIS ROOM.
 - LOCATION OF DIGITAL TIMER SWITCHES FOR OVER-RIDE CONTROL OF EXTERIOR LIGHTING AND BOTH LOCKER ROOMS. REFER TO LIGHTING CONTACTOR SCHEDULE AND CONTROL DIAGRAM ON SHEET EB-4.0.
 - LOCATION OF CLOCK FACE, COORDINATE EXACT LOCATION WITH ARCHITECT PRIOR TO ROUGH-IN. CLOCK CONTROLLER TO BE LOCATED WITHIN IT ROOM.
- GENERAL NOTES
- WHERE MORE CONDUCTORS ARE SHOWN THAN CIRCUITS IN A CONTACTOR CONTROLLED HOMERUN, THE ADDITIONAL CONDUCTOR IS TO POWER NIGHT LIGHTS AND/OR EMERGENCY BATTERY BALLAST AND SHALL NOT BE SWITCHED.
 - EXTEND UNCONTROLLED "HOT" CONDUCTOR TO ALL EMERGENCY LIGHTS, EXIT LIGHTS, AND NIGHT LIGHTS.
 - ALL CONDUIT SHALL BE ROUTED CONCEALED EXCEPT WHERE NOTED ON DRAWINGS AS EXPOSED.

Order Plans @

Kimley-Horn
2201 West Royal Lane, Suite 275, Irving, Texas 75063
PH: 972-261-4141
FLORIDA REGISTERED ENGINEERING FIRM No. 898
FLORIDA REGISTERED LANDSCAPE ARCHITECTURE FIRM LC-C000219
© 2017 KIMLEY-HORN AND ASSOCIATES, INC.

Daniel A. Sutyak
Professional Engineer
State of Florida
No. 120921
Date: 2017.02.15 12:09:21
Daniel Anthony Sutyak
P.E. No. 74042

BUTLER PARK AQUATIC CENTER
CITY OF NORTHPORT, FL

BATHHOUSE BUILDING
LIGHTING PLAN

Scale: AS SHOWN
Designed by: DAS
Drawn by: SW
Checked by: DAS
Date: DECEMBER 2017
Project No. 48285014

SHEET
EB-2.0

This item has been electronically signed and sealed by Daniel A. Sutyak, PE. On 12/15/2017 using a Digital Signature.
Printed copies of this document are not considered signed and sealed and the signature must be verified on any electronic copies.

Job Number: 84080
Colwill Engineering
Consulting Engineers, Inc.
Engineering Business No. 9021
4760 East Adamo Drive Tampa, Florida 33606
Tel: 813-241-2020 Fax: 813-241-2424
© 2017 ALL RIGHTS RESERVED