


Order Plans @

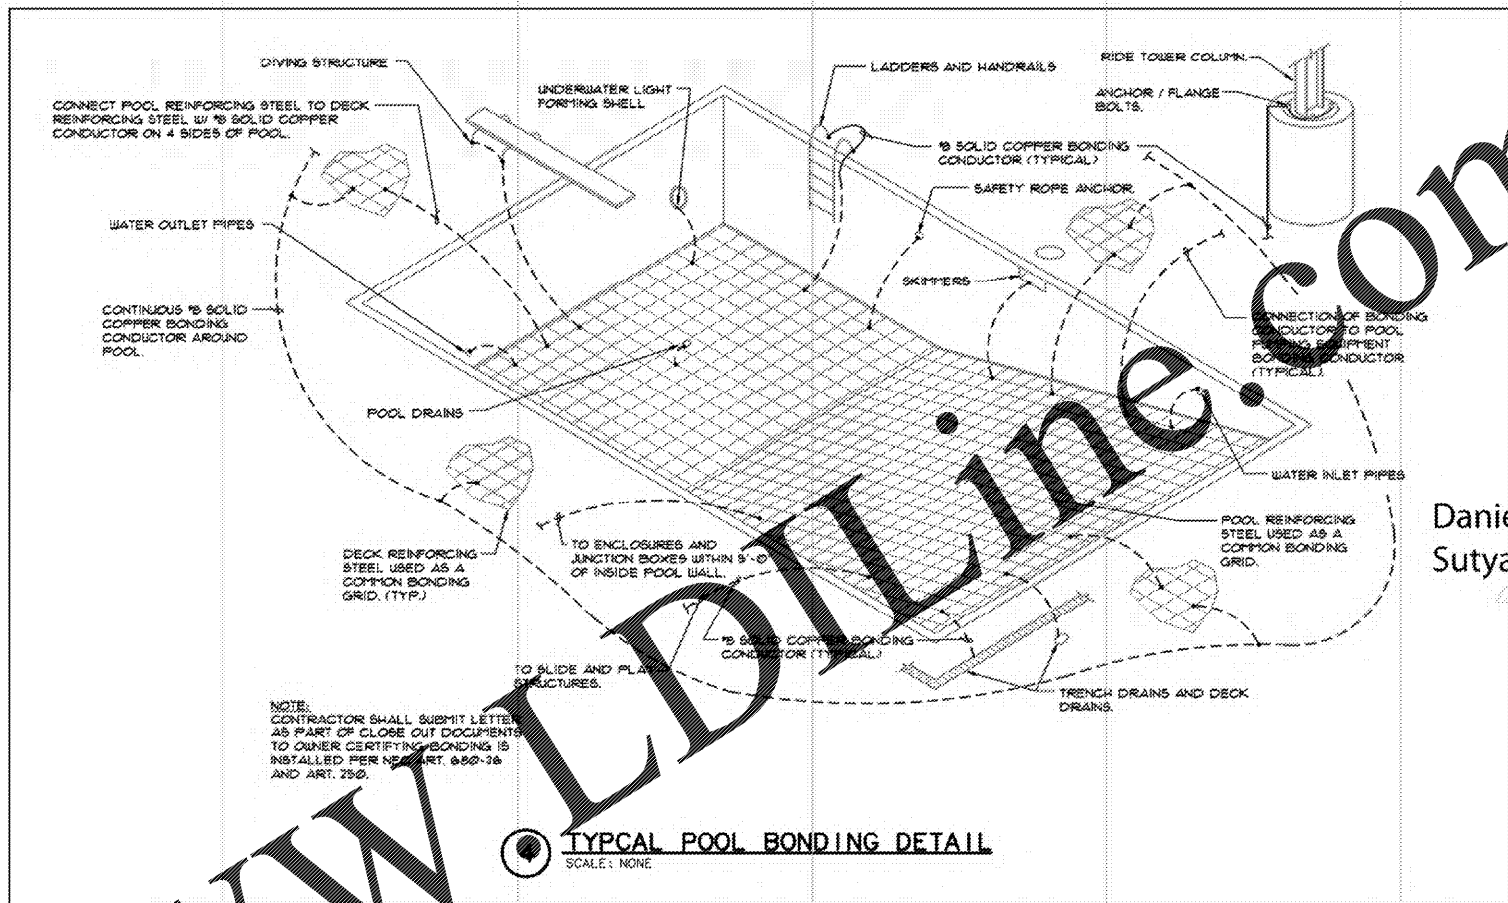




Daniel A. Sutyak



Daniel Anthony Sutyak
P.E. 367402

BUTLER PARK
AQUATIC CENTER
CITY OF NORTH PORT, FL

FILTRATION BUILDING
ELECTRICAL DETAILS

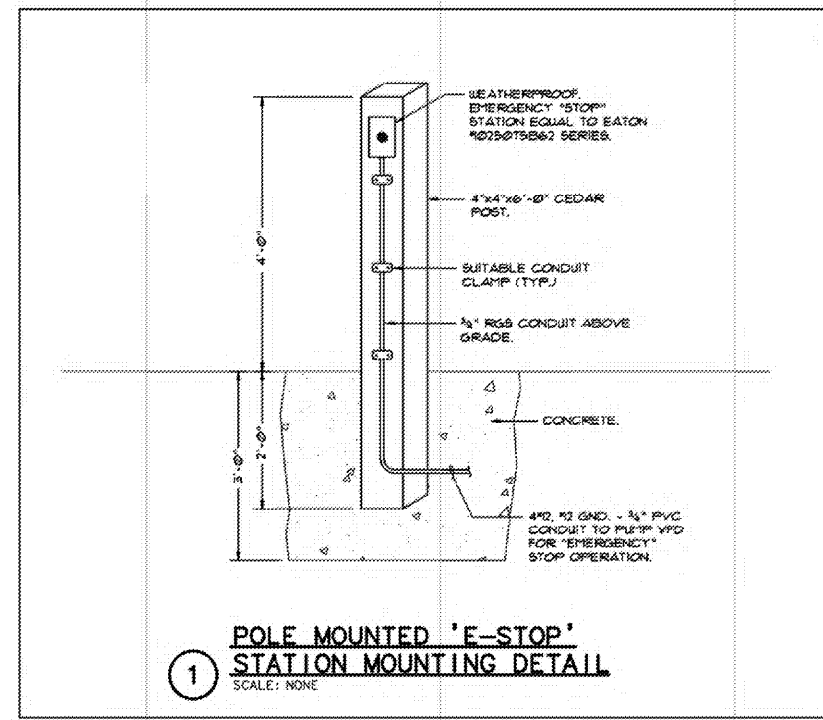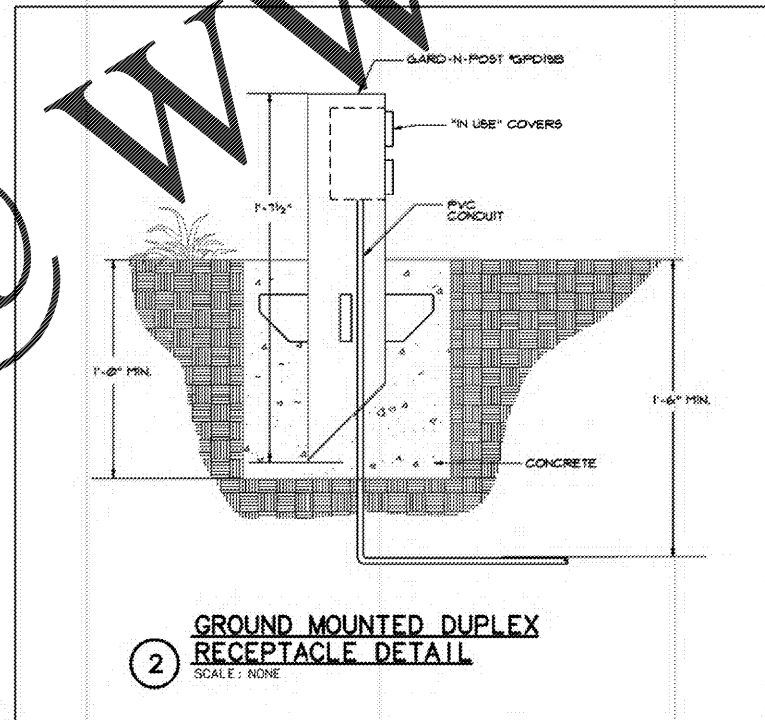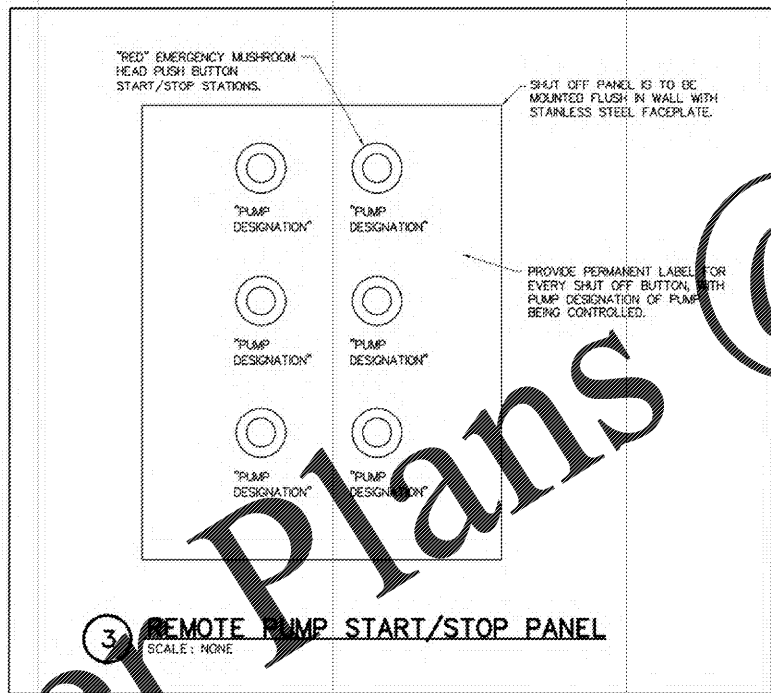

Scale:	AS SHOWN
Designed by:	DAS
Drawn by:	SW
Checked by:	DAS
Date:	DECEMBER 2017
Project No.:	48285014

This item has been electronically signed and sealed by Daniel A. Sutyak, PE, On 8/17/2016 using a Digital Signature. Printed copies of this document are not considered signed and sealed and the signature must be verified on any electronic copies.



SHEET
EF-3.2