


Order Plans @

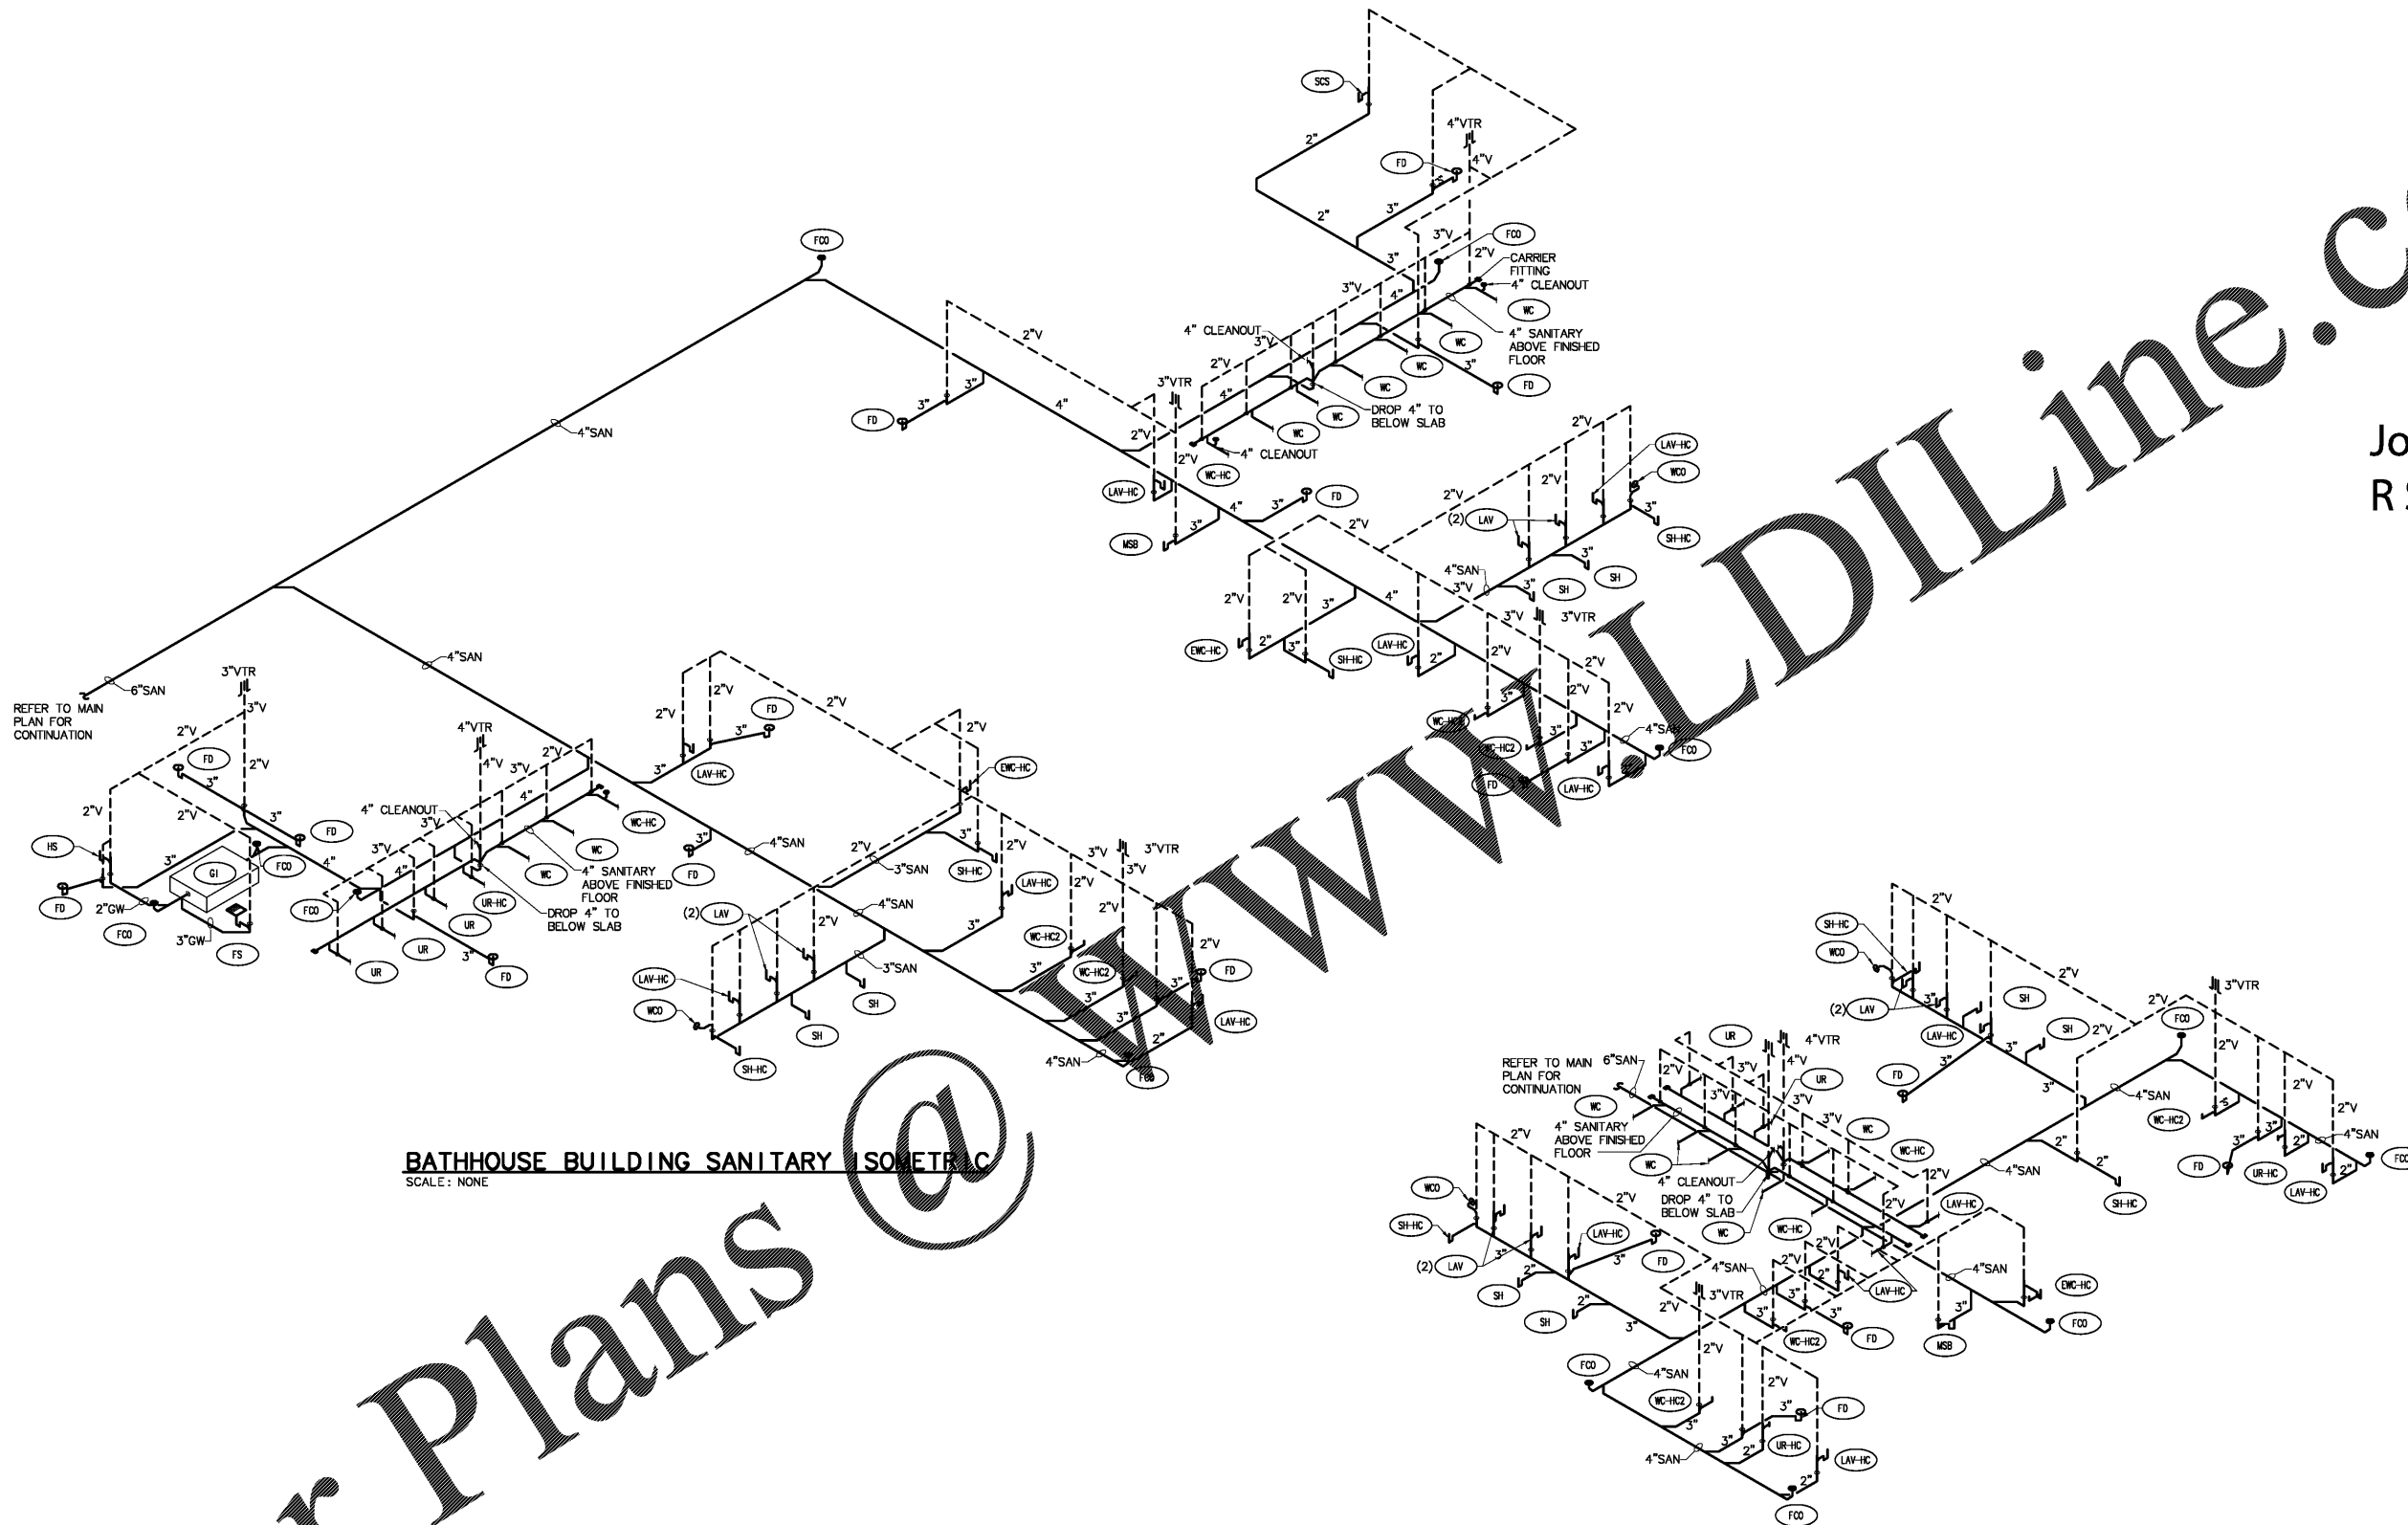

**BATHHOUSE BUILDING SANITARY ISOMETRIC**  
SCALE: NONE

**FILTRATION BUILDING SANITARY ISOMETRIC**  
SCALE: NONE

Joseph R Stolz

Digitally signed by Joseph R. Stolz  
DN: cn=J.R. Stolz, ou=Colwill Engineering, cn=Joseph R. Stolz, o=Colwill Engineering, cn=Joseph R. Stolz, email=jr.stolz@colwill.com, c=US  
Date: 2017.12.15 12:45:43 -0500

Scale:	AS SHOWN
Designed by:	LR
Drawn by:	LR
Checked by:	JS
Date:	DECEMBER 2017
Project No.:	48285014

BUTLER PARK  
AQUATIC CENTER  
CITY OF NORTHPORT, FL

BATHHOUSE BUILDING AND  
FILTRATION BUILDING  
SANITARY RISERS

SHEET  
PB-F4.0

This item has been electronically signed and sealed by Joseph R. Stolz, PE, On 12/15/2017 using a Digital Signature.  
Printed copies of this document are not considered signed and sealed and the signature must be verified on any electronic copies.



Kimley-Horn  
2201 West Royal Lane, Suite 275, Irving, Texas 75063  
PH: 972-261-0000 FAX: 972-261-0001  
FLORIDA REGISTERED ENGINEERING FIRM BR  
FLORIDA REGISTERED LANDSCAPE ARCHITECTURE FIRM LC-C000219  
© 2017 KIMLEY-HORN AND ASSOCIATES, INC.