



Order Plans

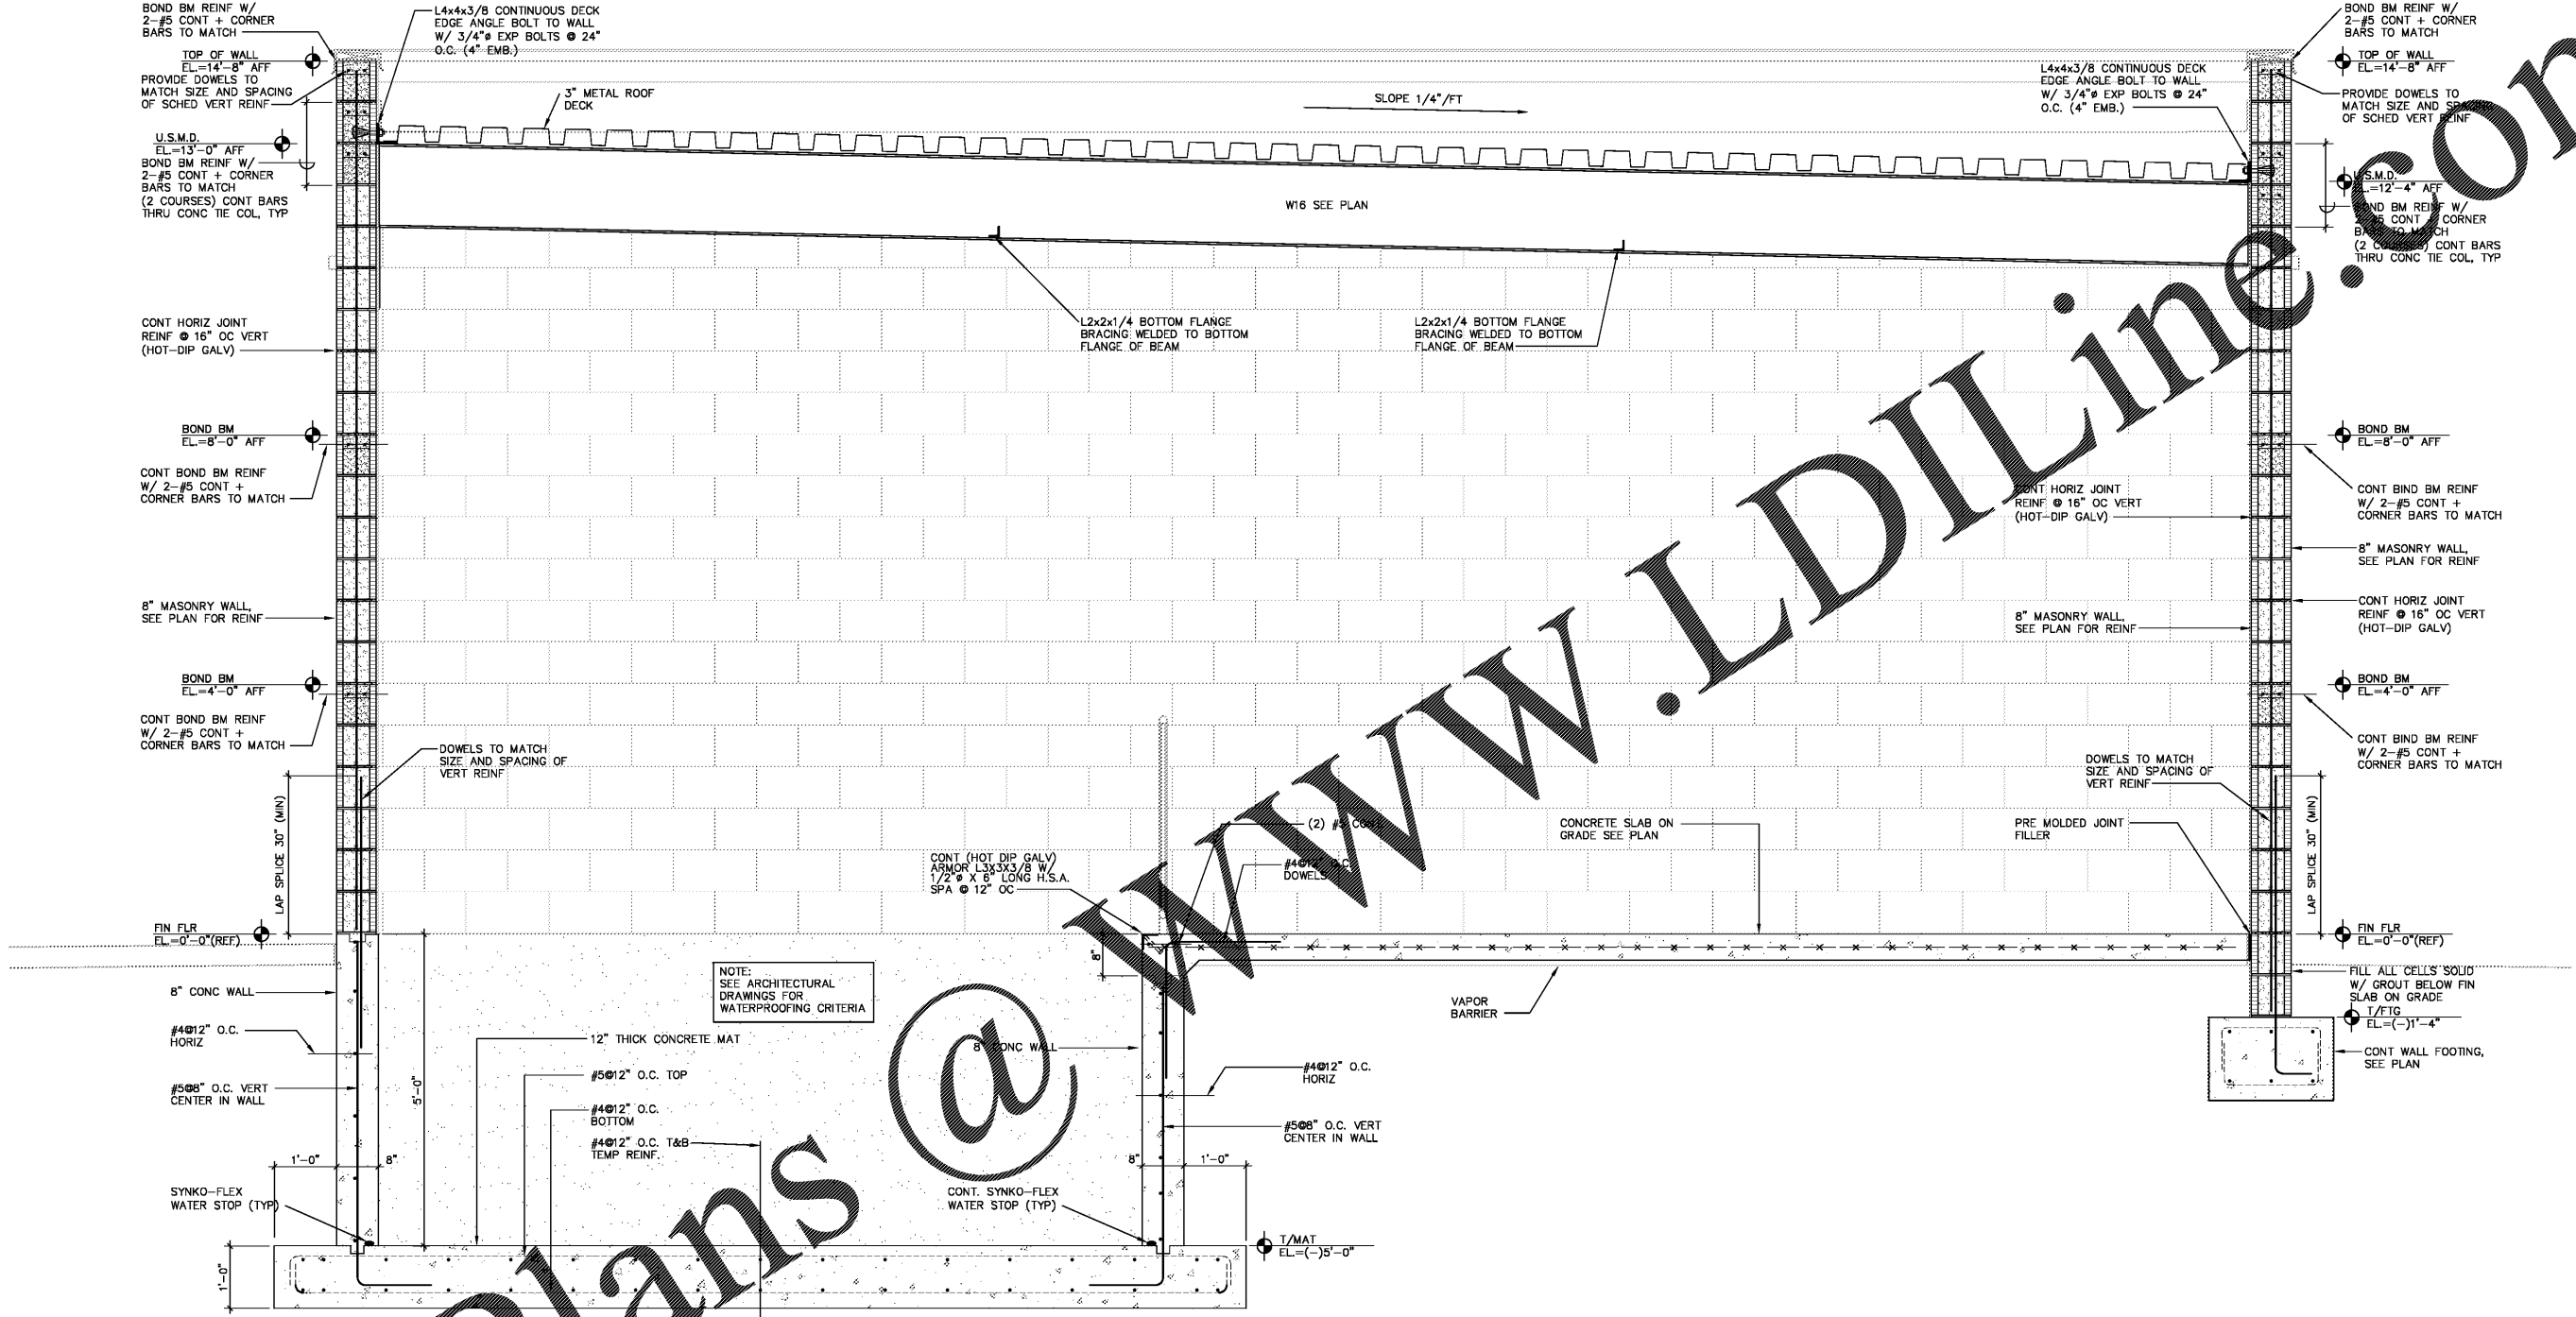

W7 WALL SECTION
SCALE: 3/4" = 1'-0"

Kimley-Horn
2201 West Royal Lane, Suite 275, Irving, Texas 75063
PH: 972.421.2200
FLORIDA REGISTERED ENGINEERING FIRM REG. NO. 33880
FLORIDA REGISTERED LANDSCAPE ARCHITECTURE FIRM LC-0000219
© 2017 KIMLEY-HORN AND ASSOCIATES, INC.

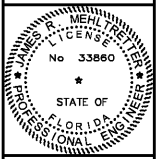


BUTLER PARK AQUATIC CENTER
CITY OF NORTHPORT, FL

FILTRATION BUILDING SECTIONS

Scale: AS SHOWN
Designed by: SL
Drawn by: JW
Checked by: JRM
Date: DECEMBER 2017
Project No. 48285014

SHEET
SF5.4

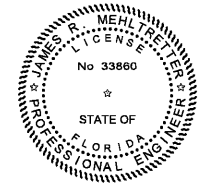

Digitally signed by JAMES R MEHLRETTER
DN: DN: 0.9.2342.19200300.100.1.1=A0109800000158F46F62F60000
0CB7,CN=JAMES R MEHLRETTER, O=IdenTrust ACES Unaffiliated Individual, C=US
Date: 2017.12.15 12:29:54-05'00'

MASTER CONSULTING ENGINEERS, INC.
STRUCTURAL CONSULTANTS
5523 WEST CYPRESS ST., #200
TAMPA, FLORIDA 33607
813.287.3600 FAX: 813.287.3622
www.mceinc.com
THIS DRAWING AND ALL INFORMATION CONTAINED HEREIN IS THE SOLE PROPERTY OF MASTER CONSULTING ENGINEERS, INC. AND IS NOT TO BE REPRODUCED, COPIED, OR TRANSMITTED IN ANY FORM OR BY ANY MEANS, ELECTRONIC OR MECHANICAL, INCLUDING PHOTOCOPYING, RECORDING, OR BY ANY INFORMATION STORAGE AND RETRIEVAL SYSTEM, WITHOUT THE WRITTEN PERMISSION OF MASTER CONSULTING ENGINEERS, INC.
CA: 8426 PROJ. NO. 3104-056
© COPYRIGHT 2014

FL0000 Project: 0104 - Water Treatment - Butler Park Pool North - Purification System Building - SF5.4 - 12/15/2017 8:52 AM - John