



Order Plans @

www

www

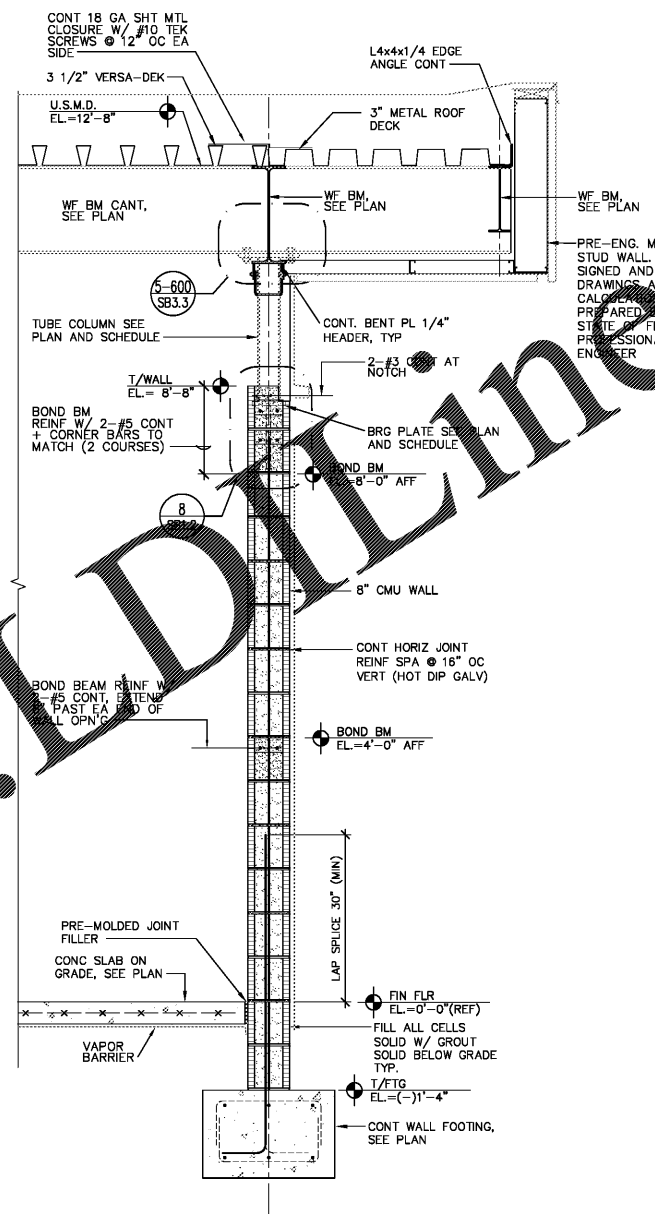

W8 WALL SECTION  
SCALE: 3/4" = 1'-0"

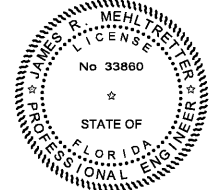

Digitally signed by JAMES R MEHLRETTER  
DN:  
OID.0.9.2342.19200300.100.1.1-A  
01098000000158F46F62F600000  
CB7,CN=JAMES R  
MEHLRETTER, O=IdenTrust  
ACES Unaffiliated Individual,  
C=US  
Date: 2017.12.15 12:30:23-05'00'


**MASTER CONSULTING ENGINEERS, INC.**  
STRUCTURAL CONSULTANTS  
5523 WEST CYPRESS ST., #200  
TAMPA, FLORIDA 33607  
813.287.3600 FAX: 813.287.3622  
www.mceengineers.com

Scale:	AS SHOWN
Designed by:	SL
Drawn by:	JW
Checked by:	JRM
Date:	DECEMBER 2017
Project No.:	48285014

SHEET  
SF5.5

FILTRATION BUILDING  
SECTIONS

BUTLER PARK  
AQUATIC CENTER  
CITY OF NORTHPORT, FL

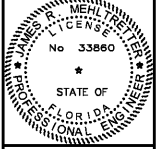

**Kimley-Horn**  
2201 West Royal Lane, Suite 275, Irving, Texas 75063  
PH: 972.261.4200  
FLORIDA REGISTERED ENGINEERING FIRM REG. NO. 1000000000000000  
FLORIDA REGISTERED LANDSCAPE ARCHITECTURE FIRM LC-0000219  
© 2017 KIMLEY-HORN AND ASSOCIATES, INC.