



Order Plans

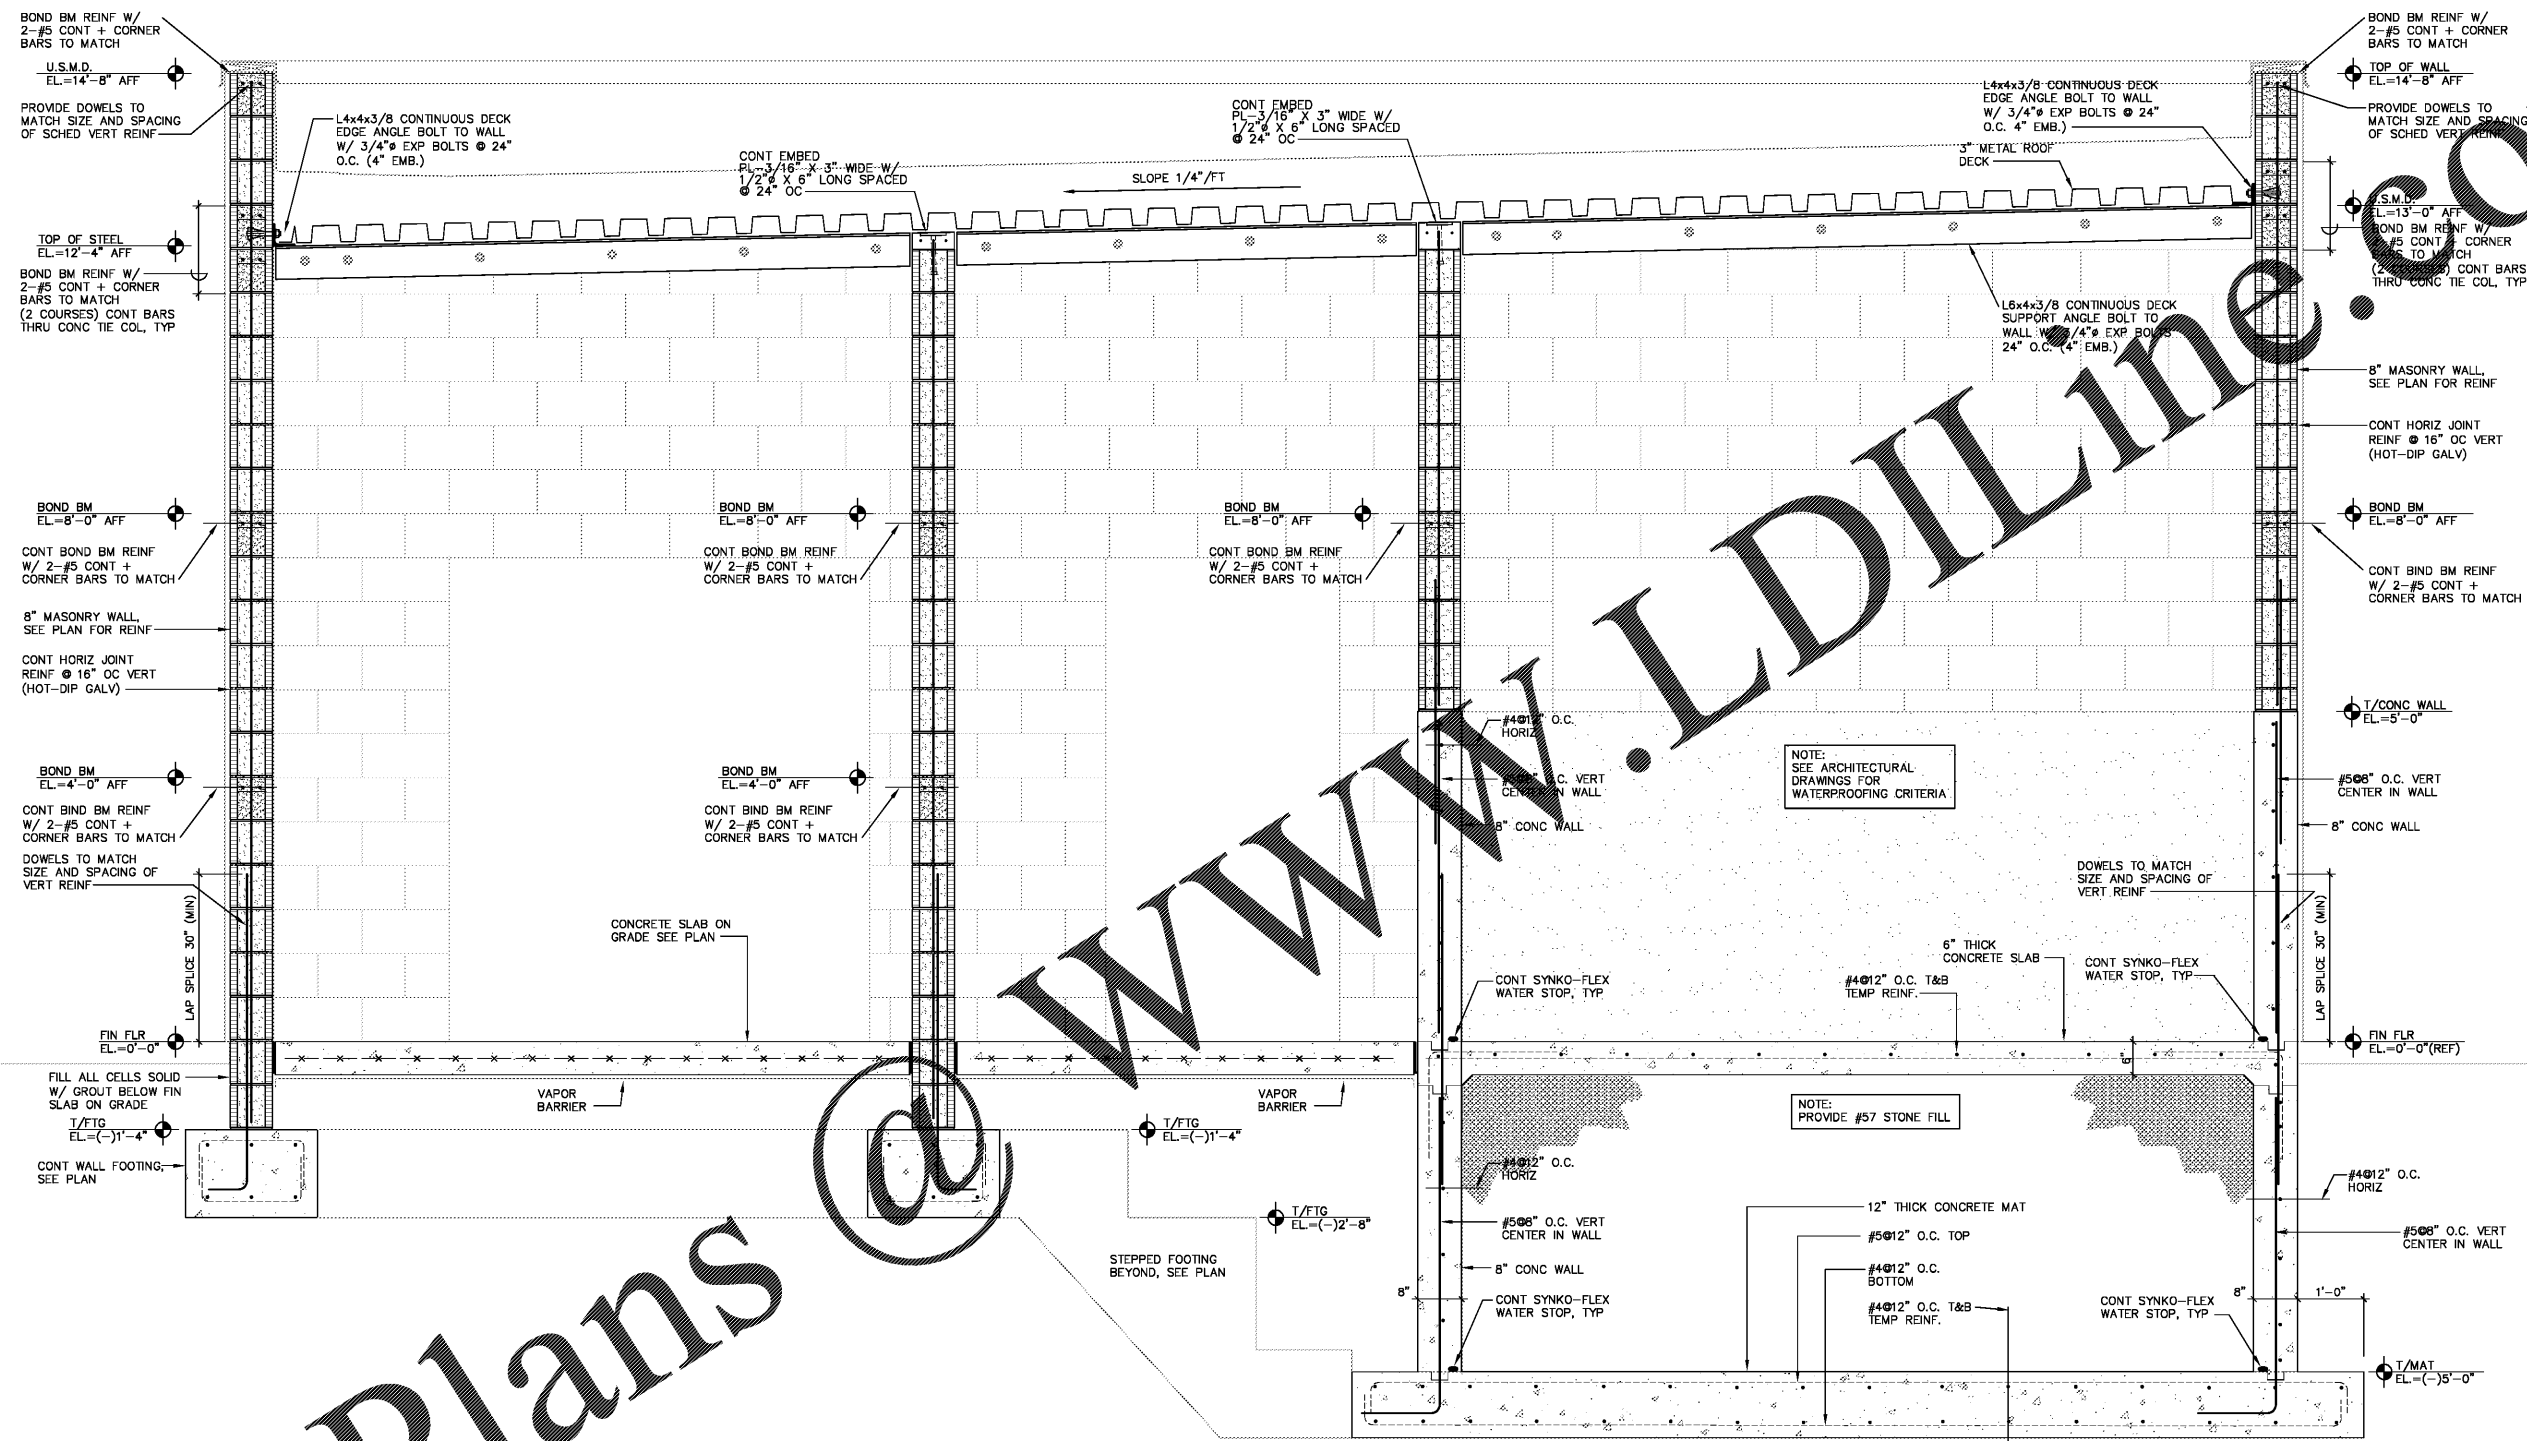

W9 WALL SECTION
SCALE: 3/4" = 1'-0"


Kimley-Horn
2201 West Royal Lane, Suite 275, Irving, Texas 75063
PH: 972.261.4200 FAX: 972.261.4201
FLORIDA REGISTERED ENGINEERING FIRM REG. NO. 12580
FLORIDA REGISTERED LANDSCAPE ARCHITECTURE FIRM LC-C000219
© 2017 KIMLEY-HORN AND ASSOCIATES, INC.

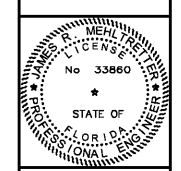

BUTLER PARK AQUATIC CENTER
CITY OF NORTHPORT, FL

FILTRATION BUILDING SECTIONS

Scale:	AS SHOWN
Designed by:	SL
Drawn by:	JW
Checked by:	JRM
Date:	DECEMBER 2017
Project No.:	48285014

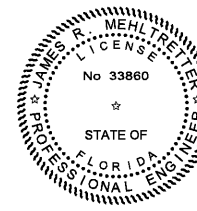

Digitally signed by JAMES R MEHLRETTER
DN:
OID.0.9.2342.19200300.100.1.1-A01
098000000158F46F62F800000CB7,
CN=JAMES R MEHLRETTER,
O=IdenTrust ACES Unaffiliated
Individual, C=US
Date: 2017.12.15 12:30:54-05'00'

MASTER CONSULTING ENGINEERS, INC.
STRUCTURAL CONSULTANTS
5523 WEST CYPRESS ST., #200
TAMPA, FLORIDA 33607
813.287.3600 FAX: 813.287.3622
www.mceengineers.com
THE SIGNATURE AND ALL INFORMATION CONTAINED HEREIN IS THE SOLE PROPERTY OF MASTER CONSULTING ENGINEERS, INC. AND IS NOT TO BE REPRODUCED, COPIED, OR TRANSMITTED IN ANY FORM OR BY ANY MEANS, ELECTRONIC OR MECHANICAL, INCLUDING PHOTOCOPYING, RECORDING, OR BY ANY INFORMATION STORAGE AND RETRIEVAL SYSTEM.
CA: 8426 PROJ NO. 3104-056
© COPYRIGHT 2014

SHEET
SF5.6

FL0000 Project:0104 Waterwall:JamesR3104-056 Butler Park Pool North Purification Building:SF5.1 TRBU:SP57 Area: 12/15/2017 8:51:47 AM John