



Order Plans @

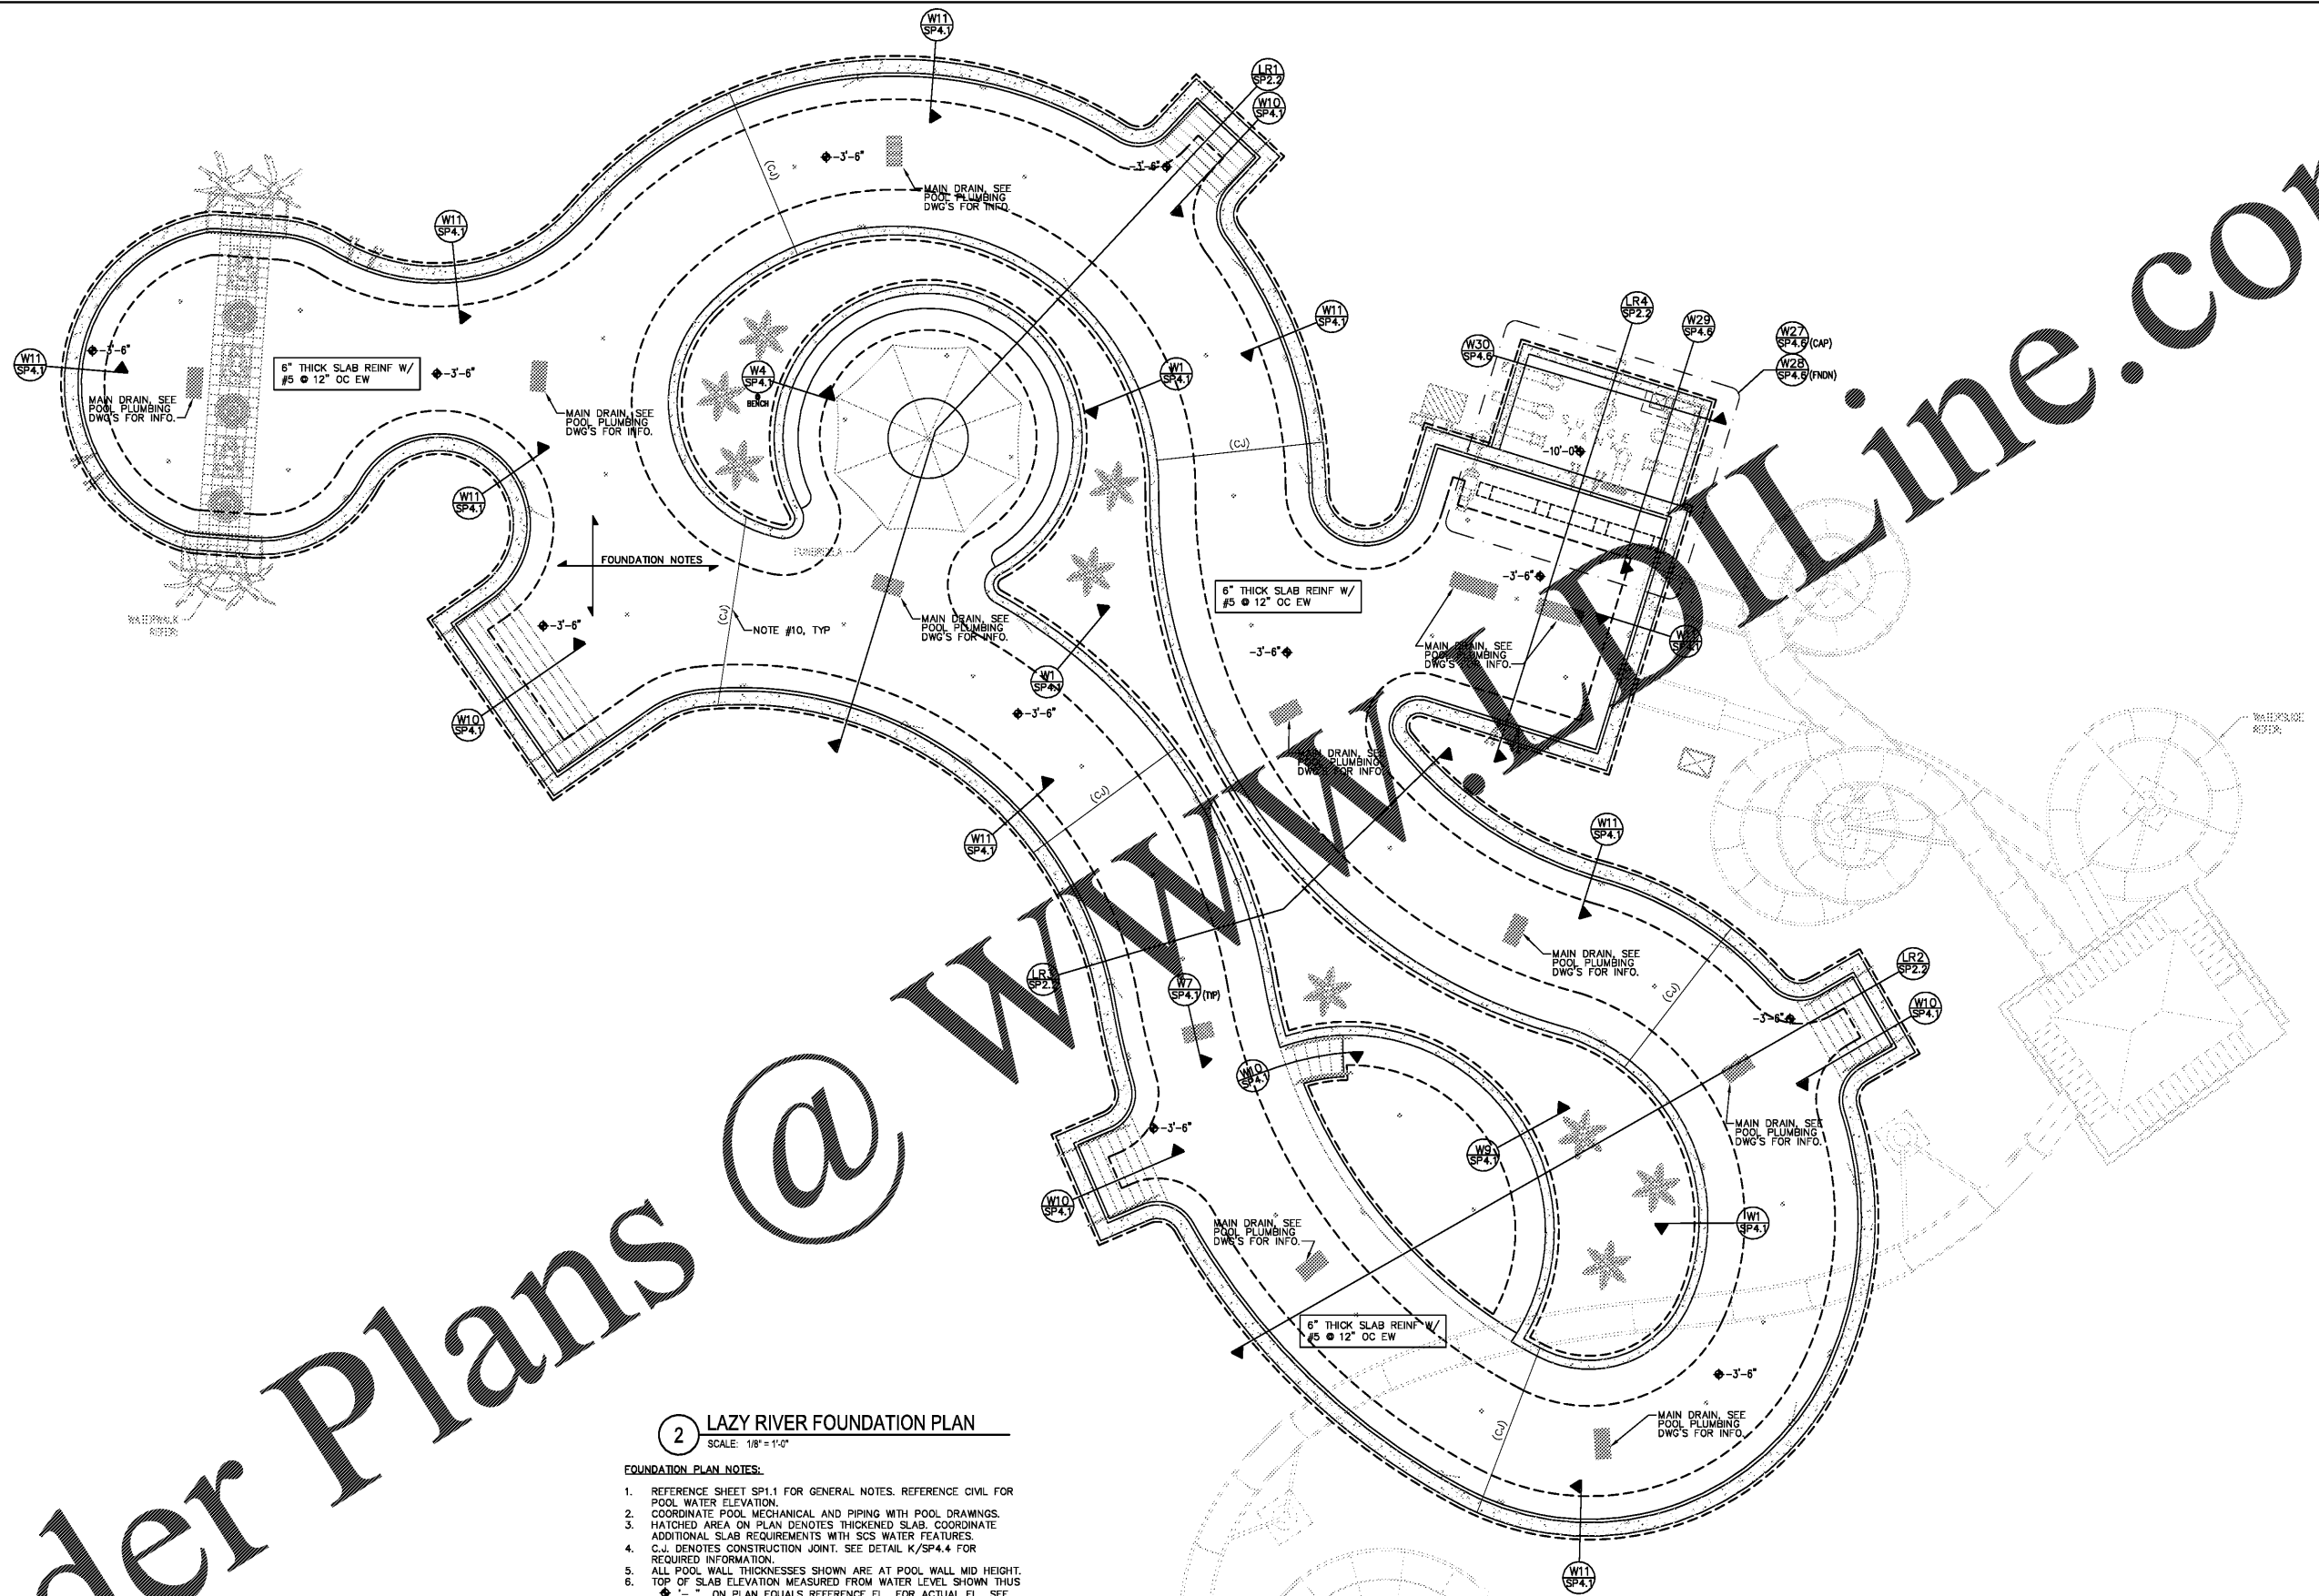

2 LAZY RIVER FOUNDATION PLAN
SCALE: 1/8" = 1'-0"

- FOUNDATION PLAN NOTES:**
1. REFERENCE SHEET SP1.1 FOR GENERAL NOTES. REFERENCE CIVIL FOR POOL WATER ELEVATION.
 2. COORDINATE POOL MECHANICAL AND PIPING WITH POOL DRAWINGS.
 3. HATCHED AREA ON PLAN DENOTES THICKENED SLAB. COORDINATE ADDITIONAL SLAB REQUIREMENTS WITH SCS WATER FEATURES.
 4. C.-J. DENOTES CONSTRUCTION JOINT. SEE DETAIL K/SP4.4 FOR REQUIRED INFORMATION.
 5. ALL POOL WALL THICKNESSES SHOWN ARE AT POOL WALL MID HEIGHT.
 6. TOP OF SLAB ELEVATION MEASURED FROM WATER LEVEL SHOWN THUS \diamond ON PLAN EQUALS REFERENCE EL. FOR ACTUAL EL., SEE CIVIL DRAWINGS.
 7. FOR TYPICAL FOUNDATION PLAN DETAILS, SEE DRAWINGS SP4.1 THRU SP4.4.
 8. FOR GENERAL STRUCTURAL NOTES, SEE DRAWING SB1.1. FOR FOOTING SIZE AND REINFORCING, SEE DRAWINGS SP4.1 THRU SP4.4.
 9. FOR PLAN DIMENSIONS NOT SHOWN, REFER TO POOL DRAWINGS.
 10. (CJ) CONTROL/CONSTRUCTION JOINT. FOR DETAILS SEE DRAWING SP4.4.
 11. PROVIDE HYDROSTATIC RELIEF VALVES IN ALL MAIN DRAIN SUMPS AT THE BOTTOMS OF POOLS TO RELIEVE HYDROSTATIC PRESSURE. POOL WATER CAN BE DRAINED PROVIDED THAT ALL HYDROSTATIC RELIEF VALVES ARE IN WORKING ORDER AND WELL POINT PLUGS ARE REMOVED. WATER SHOULD REMAIN IN POOL, EXCEPT FOR TEMPORARY MAINTENANCE.

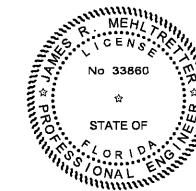

Digitally signed by JAMES R MEHLRETTER
DN:
OID.0.9.2342.19200300.100.1.1
-AO109800000168F46F82F80
0000CB7.CN=JAMES R
MEHLRETTER, O=IdenTrust
ACES Unaffiliated Individual,
C=US
Date: 2017.12.15
12:52:02-05'00'

MASTER CONSULTING ENGINEERS, INC.
STRUCTURAL CONSULTANTS
5523 WEST CYPRESS ST., #200
TAMPA, FLORIDA 33607
813.287.3600 FAX 813.287.3822
www.mtcengineers.com
THIS DRAWING AND ALL INFORMATION CONTAINED HEREIN IS THE SOLE PROPERTY OF MASTER CONSULTING ENGINEERS, INC. NO PART OF THIS DRAWING OR INFORMATION CONTAINED HEREIN IS TO BE REPRODUCED OR TRANSMITTED IN ANY FORM OR BY ANY MEANS, ELECTRONIC OR MECHANICAL, INCLUDING PHOTOCOPYING, RECORDING, OR BY ANY INFORMATION STORAGE AND RETRIEVAL SYSTEM, WITHOUT THE WRITTEN PERMISSION OF MASTER CONSULTING ENGINEERS, INC.
CA: 8426 PROJ NO. 3104-056
© COPYRIGHT 2017

Scale:	AS SHOWN
Designed by:	SL
Drawn by:	JW
Checked by:	JRM
Date:	DECEMBER 2017
Project No.:	48285014
SHEET	
SP1.3	

**BUTLER PARK
AQUATIC CENTER
CITY OF NORTHPORT, FL**

**LAZY RIVER POOL
FOUNDATION PLANS**



Kimley-Horn
2201 West Royal Lane, Suite 275, Irving, Texas 75063
PHOTOGRAPHY BY: JIMMY BOYD
FLORIDA REGISTERED ENGINEERING FIRM #99
FLORIDA REGISTERED LANDSCAPE ARCHITECTURE FIRM LC-C000219
© 2017 KIMLEY-HORN AND ASSOCIATES, INC.

PL18090 Project: 01/14 Watermain; 01/14 Butler Park Aquatic Center; 01/14 Sp1.3.dwg, 12/15/2017, 10:54:02 AM, 28w4