




W28 LAZY RIVER POOL SURGE TANK - FOUNDATION PLAN
SCALE: 1/2" = 1'-0"

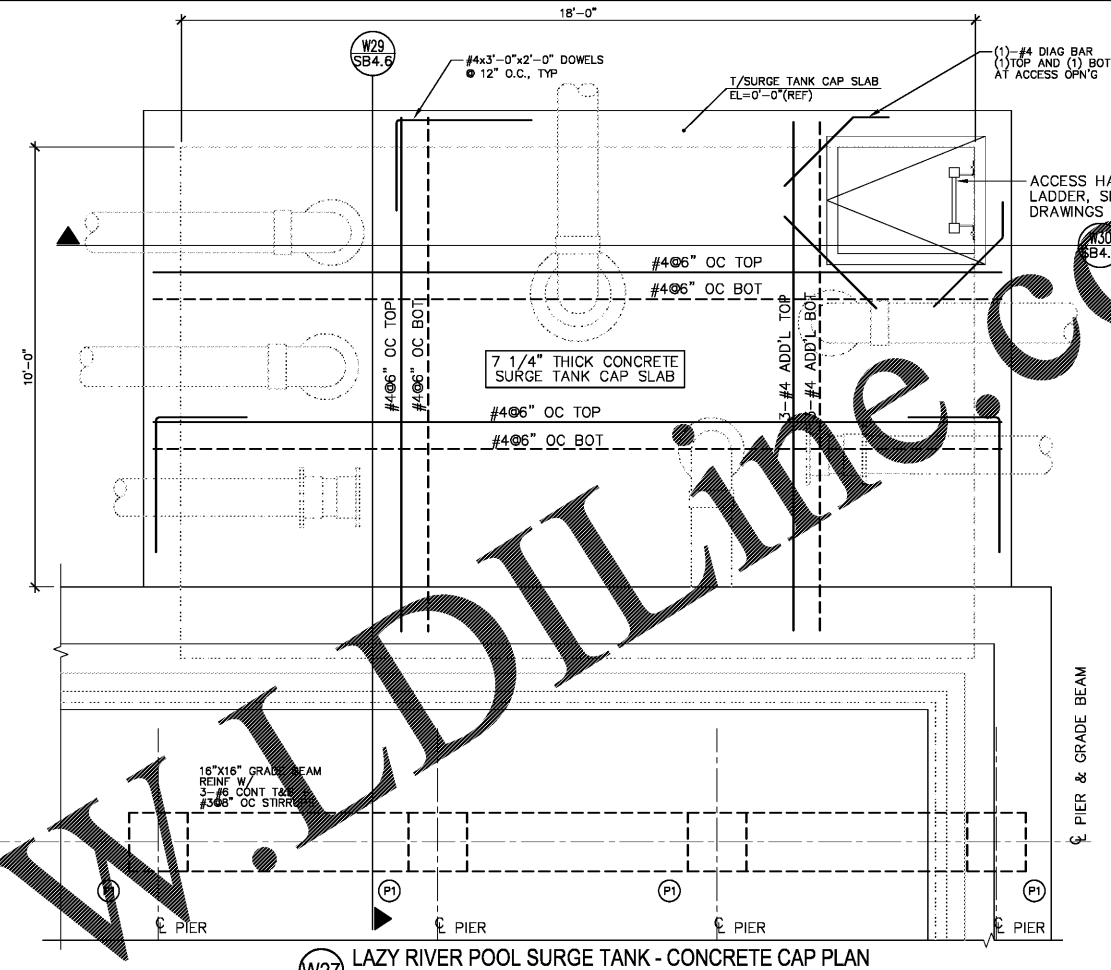

W27 LAZY RIVER POOL SURGE TANK - CONCRETE CAP PLAN
SCALE: 1/2" = 1'-0"

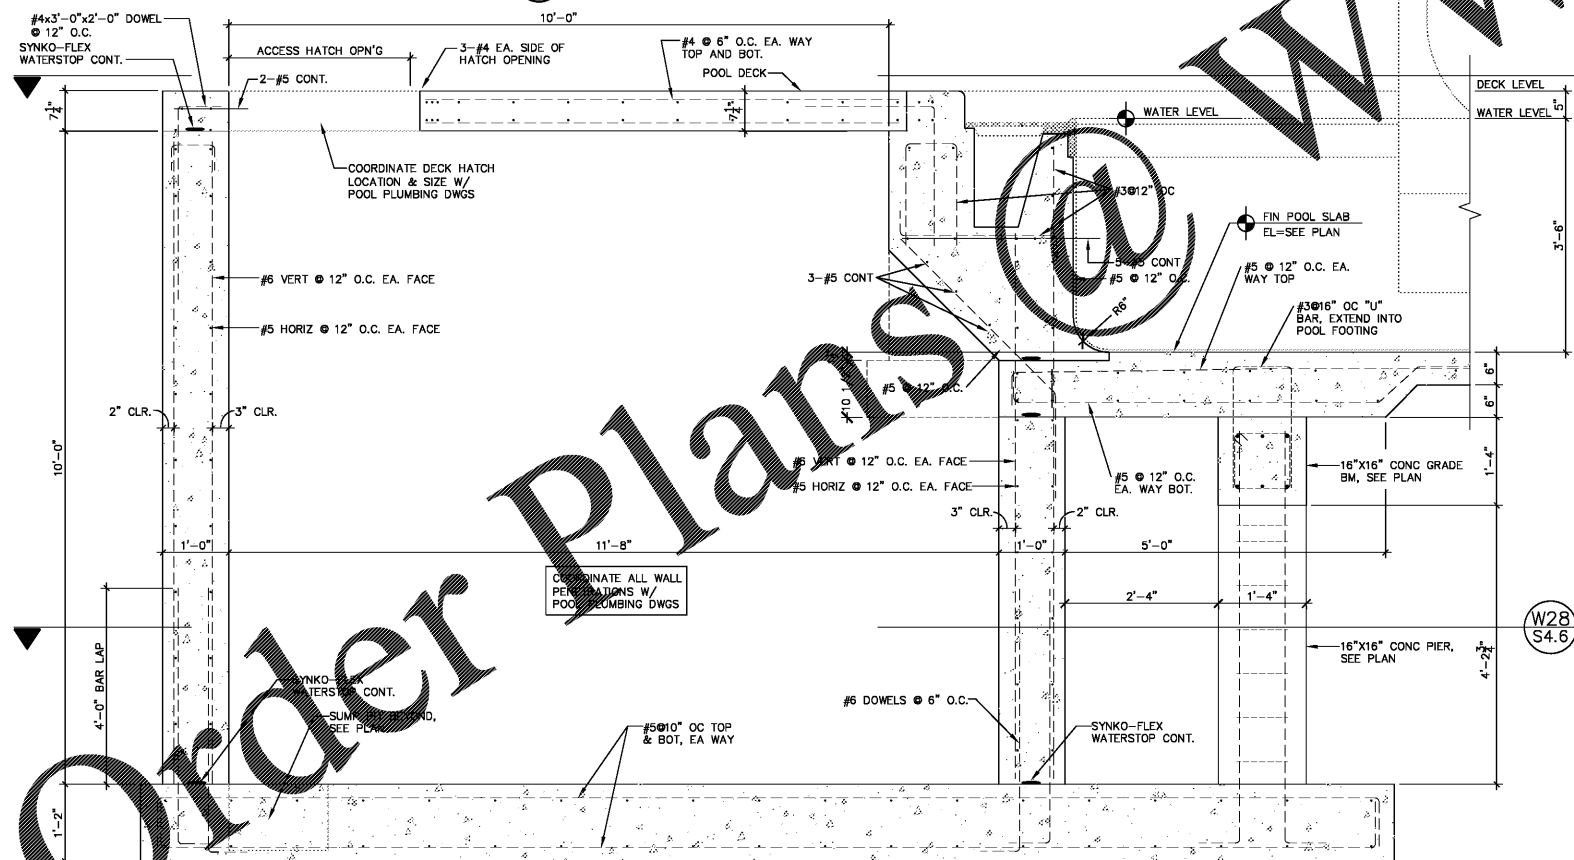

W29 LAZY RIVER POOL SURGE TANK - SECTION
SCALE: 3/4" = 1'-0"

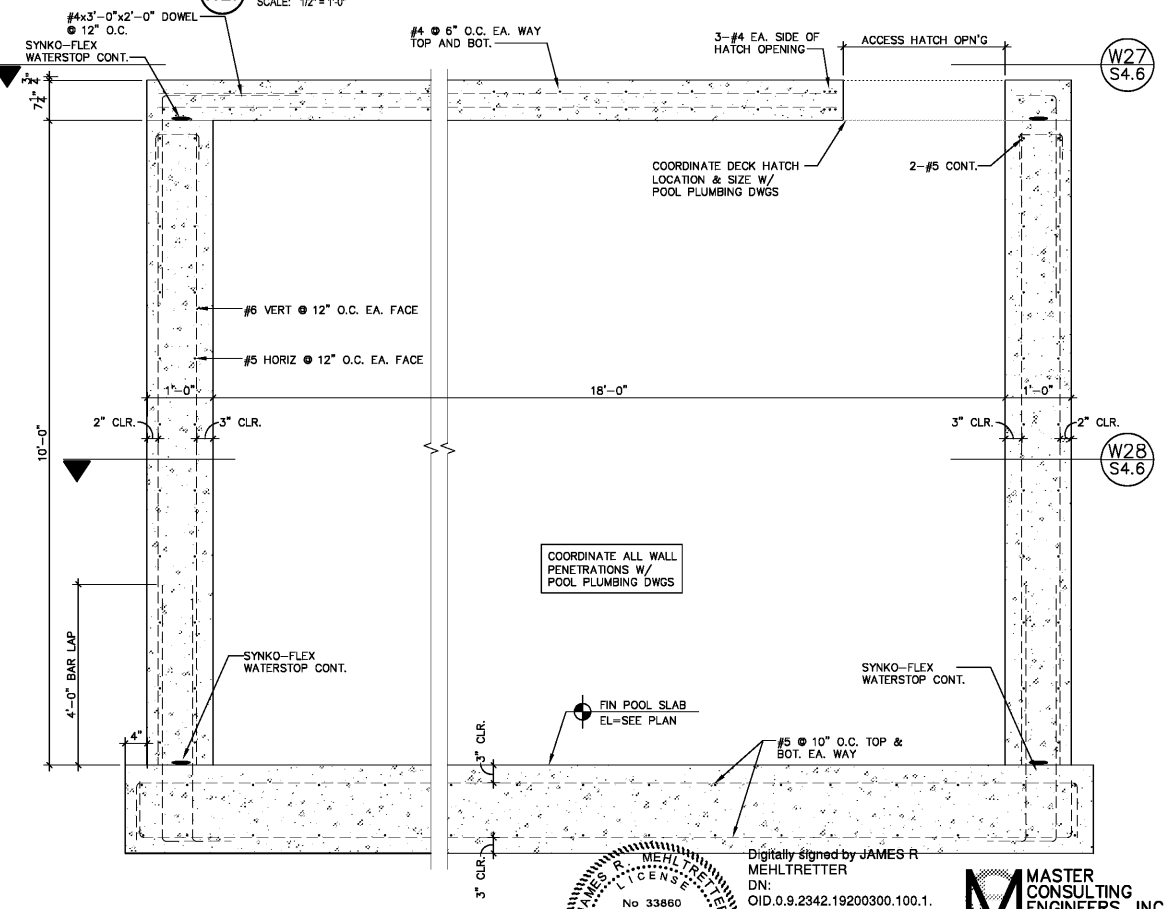

W30 LAZY RIVER POOL SURGE TANK - SECTION
SCALE: 3/4" = 1'-0"


Digitally signed by JAMES R MEHLTRETTER
DN: O=D.9.2342.19200300.100.1,
CN=JAMES R MEHLTRETTER, OU=JRM,
OU=ACES Unaffiliated Individual,
C=US
Date: 2017.12.15
12:56:13-05'00'

MASTER CONSULTING ENGINEERS, INC.
STRUCTURAL CONSULTANTS
5523 WEST CYPRESS ST., #200
TAMPA, FLORIDA 33607
813.287.3600 FAX 813.287.3822
www.mce-engineers.com

Scale: AS SHOWN
Designed by: SL
Drawn by: JW
Checked by: JRM
Date: DECEMBER 2017
Project No. 48285014

SHEET
SP4.6

Kimley-Horn
2201 West Royal Lane, Suite 275, Irving, Texas 75063
PH: 972.261.1400
FLORIDA REGISTERED ENGINEERING FIRM #890
FLORIDA REGISTERED LANDSCAPE ARCHITECTURE FIRM LC-0000219
© 2017 KIMLEY-HORN AND ASSOCIATES, INC.

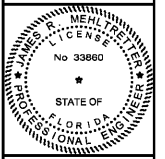

**BUTLER PARK
AQUATIC CENTER**
CITY OF NORTHPORT, FL

POOL WALL SECTIONS

FL00001 Project: 01/14/2017 11:54:03 AM