










**CEILING FINISH SCHEDULE**

**ACT-1** ACOUSTICAL TILE / GRID  
NEW CLASS 'A' NON-REGULAR A.C.T. LAY IN: 24x24x5/8"; IN NEW 24" x 24" SUSP. CLG GRID. CONFIRM WITH OWNER. PROVIDE (1) CARTON OF CEILING TILE AT END OF JOB.

**LIGHTING LEGEND**

-  RECESSED PRISMATIC LIGHT FIXTURE
-  SUSPENDED LIGHT FIXTURE
-  RECESSED CAN LIGHT FIXTURE (EXISTING)
-  EXTERIOR SCONCE (EXISTING)
-  Y1 LIGHT FIXTURE (EXISTING)
-  EMERGENCY LIGHT - SEE ELECTRICAL
-  RESTROOM EXHAUST FAN
-  RETURN AIR GRILL  
SEE MECHANICAL DRAWINGS
-  SUPPLY AIR GRILL  
SEE MECHANICAL DRAWINGS


**KEY NOTES**

- 1** EXISTING METAL CANOPY
- 2** EXISTING AWNING
- 3** EXISTING RECESSED CANOPY LIGHT
- 4** HEADER @ 8'-0" A.F.F. - REFERENCE DETAIL 2/A201
- 5** CENTER CEILING GRID IN ROOM AS SHOWN


**GENERAL NOTES**

FINISH CEILING HEIGHT SHALL BE AS NOTED  
UNLESS OTHERWISE NOTED OR CODED, ALL FIXTURES SHOWN ARE NEW  
THE CONTRACTOR SHALL CAREFULLY REVIEW ALL ATTACHMENT CONDITIONS FOR NEW FURRED OR SUSPENDED CEILING TO ASSUME PROPER CLEARANCES AND FIXMENT  
SEE ELECTRICAL PLAN FOR FIXTURES CIRCUITED TO EMERGENCY POWER  
SEE HVAC PLAN TO COORDINATE CEILING DIFFUSERS, GRILLES, AND FAN LOCATIONS (SHOWN ON THIS DRAWING FOR LOCATION ONLY)  
SPEAKER SYSTEM BY OWNER


----- - CEILING FINISH - SEE SCHEDULE  
#-# A.F.F. - CEILING HEIGHT ABOVE FINISHED FLOOR

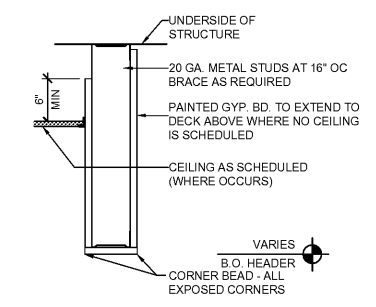

**2 SOFFIT SECTION**  
SCALE: N.T.S.

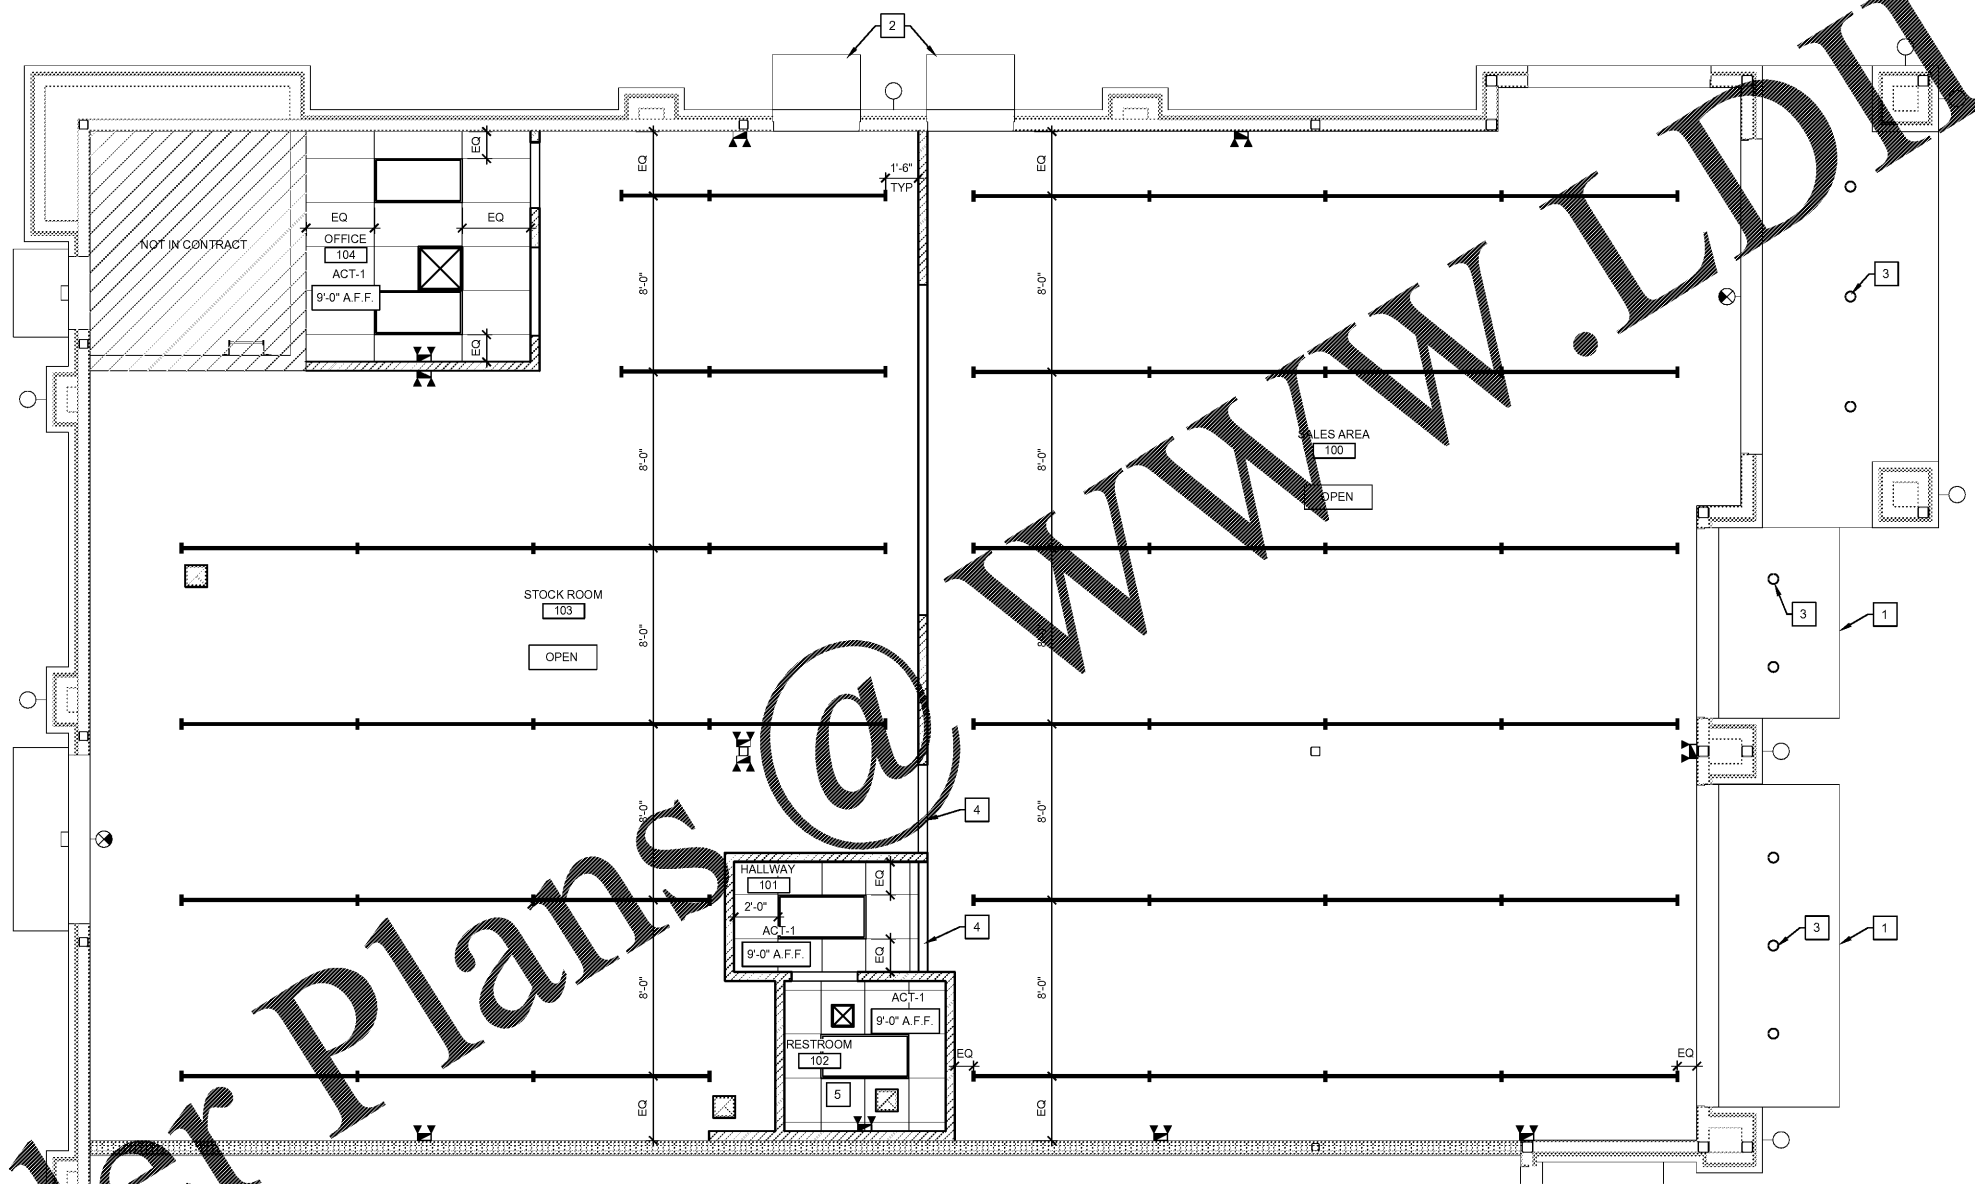

 **1 REFLECTED CEILING PLAN**  
SCALE: 1/4" = 1'-0"



Order Plans @

WWW.LDOnline.com

04.04.18 PERMIT SUBMIT  
03.26.18 OWNER REVIEW  
03.23.18 OWNER REVIEW

NO DATE REMARKS

REVISIONS

**SHERWIN WILLIAMS**

8909 IMMOKALEE ROAD  
NAPLES, FL 34120

PROJECT NO: 2018.0102  
DATE: 03.19.18

**A201**  
REFLECTED CEILING PLAN

CHECKED: KCP DRAWN: MB

COPYRIGHT © 2018 INTERPLAN LLC. SERVICES COPYRIGHT & OTHER RIGHTS RESERVED. REPRODUCTION OF THESE DOCUMENTS TO THE ORIGINAL FILE OR ANY OTHER FILE WHICH WERE REPRODUCED, REPRODUCED, CHANGES OR ASSIGNMENTS ARE PROHIBITED.