


Order Plans

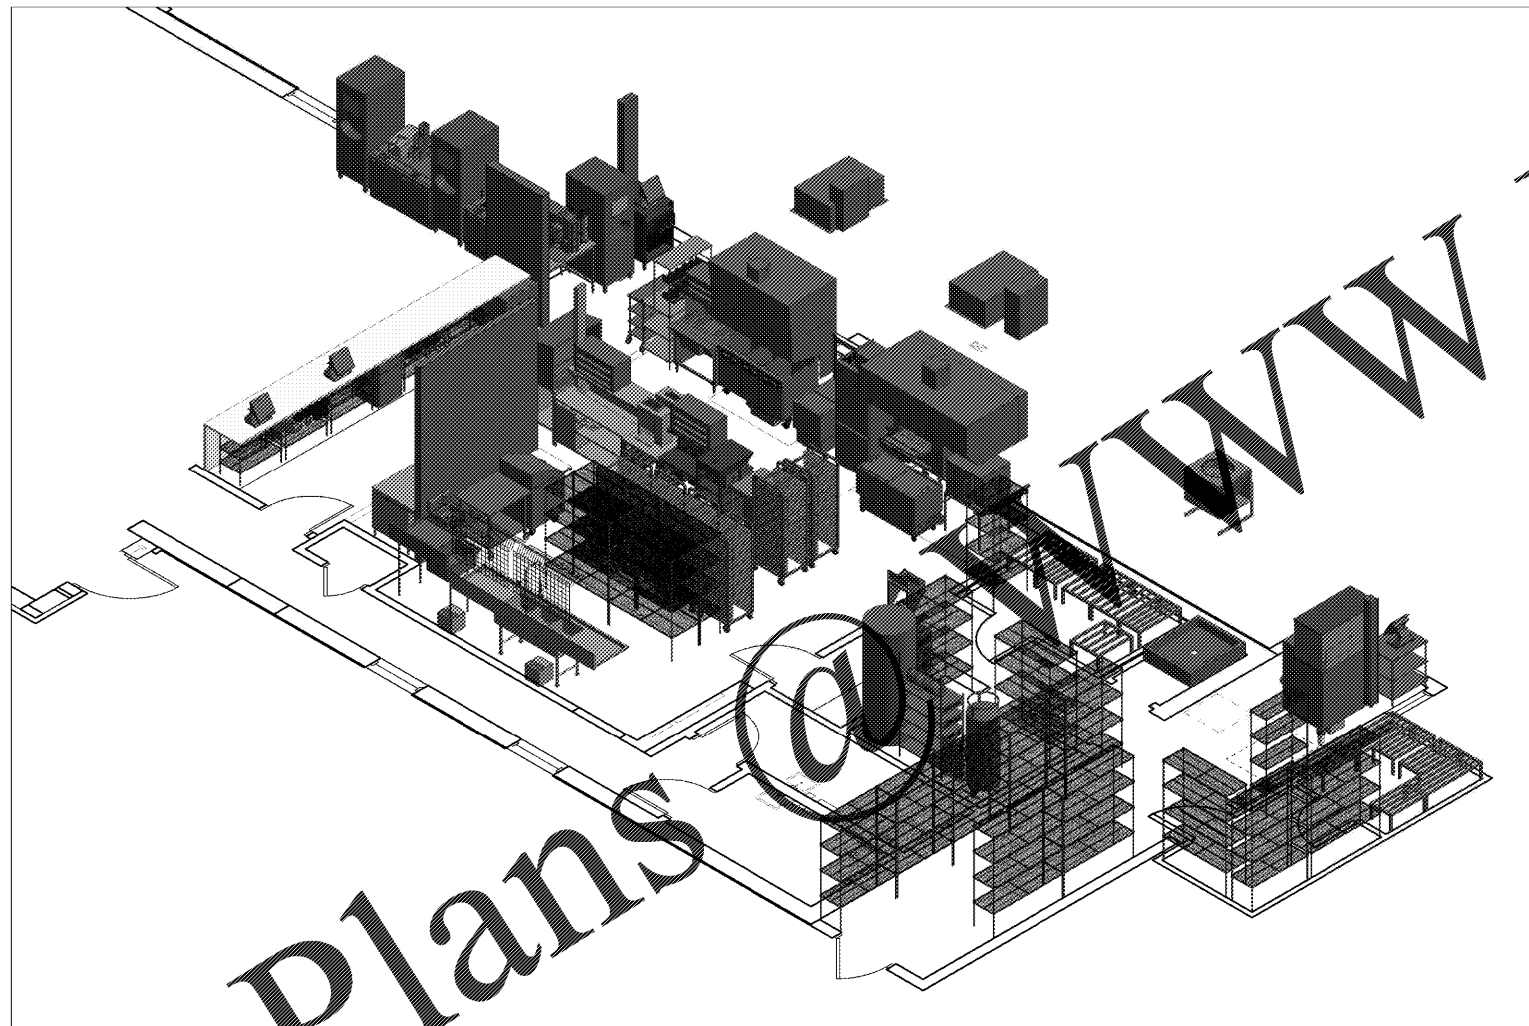

1 (3D)

SHEET LIST	
Sheet Number	Title
K0.0	KES COVER SHEET
K1.0	KES EQUIPMENT PLAN
K2.0	KES SCHEDULES
K3.0	KES ELEVATIONS
K4.0	KES NOTES AND DETAIL
KE1.1	KES ELECTRICAL PLAN
KM1.1	KES MECHANICAL PLAN
KP1.1	KES PLUMBING PLAN

REV #	DATE	DESCRIPTION
A	04/19/2018	Initial Issue

Make it Wonderful



Frankie Foodservice Supply, Inc.
 800 Aviation Parkway
 Smyrna, TN 37167
 Tel. +800 472-2954
 fs_customer-service.us@franke.com
 www.franke-usa.com

© 2017 Frankie Foodservice Systems, Inc. These drawings are specifications and the property of Frankie Foodservice Systems, Inc. and shall not be reproduced, copied or transmitted in any form, without the prior written consent of Frankie Foodservice Systems, Inc. Frankie Foodservice Systems, Inc. reserves the right to change equipment without notice.

Burger King
 2397
 KES COVER SHEET

Burger King
 Site Address:
 998 SUNSET BLVD
 City:
 JESUP
 State: GA Zip Code: 31545 Country: USA
 Region:
 NORTH AMERICA
 Building Type:
 FREESTANDING

Electrical Service:
 208V-230V
 Gas Service:
 UNSPECIFIED
 Market Manager:
 M. COUYOUMJIAN
 Frankie Project Number:
 1393889
 Frankie Order Number:
 5028196
 Created By:
 HP033
 Date Issued:
 04/19/2018
 Modified By:
 HP033
 Drawing Scale:
 As Noted
 Units:
 INCH
 Drawing Number:
 Jesup, GA.rte
 Revision:
 A

Sheet Name:
K0.0

EXISTING EQUIPMENT DEMOLISHED EQUIPMENT RELOCATED EQUIPMENT NEW EQUIPMENT FUTURE EQUIPMENT