


Order Plans

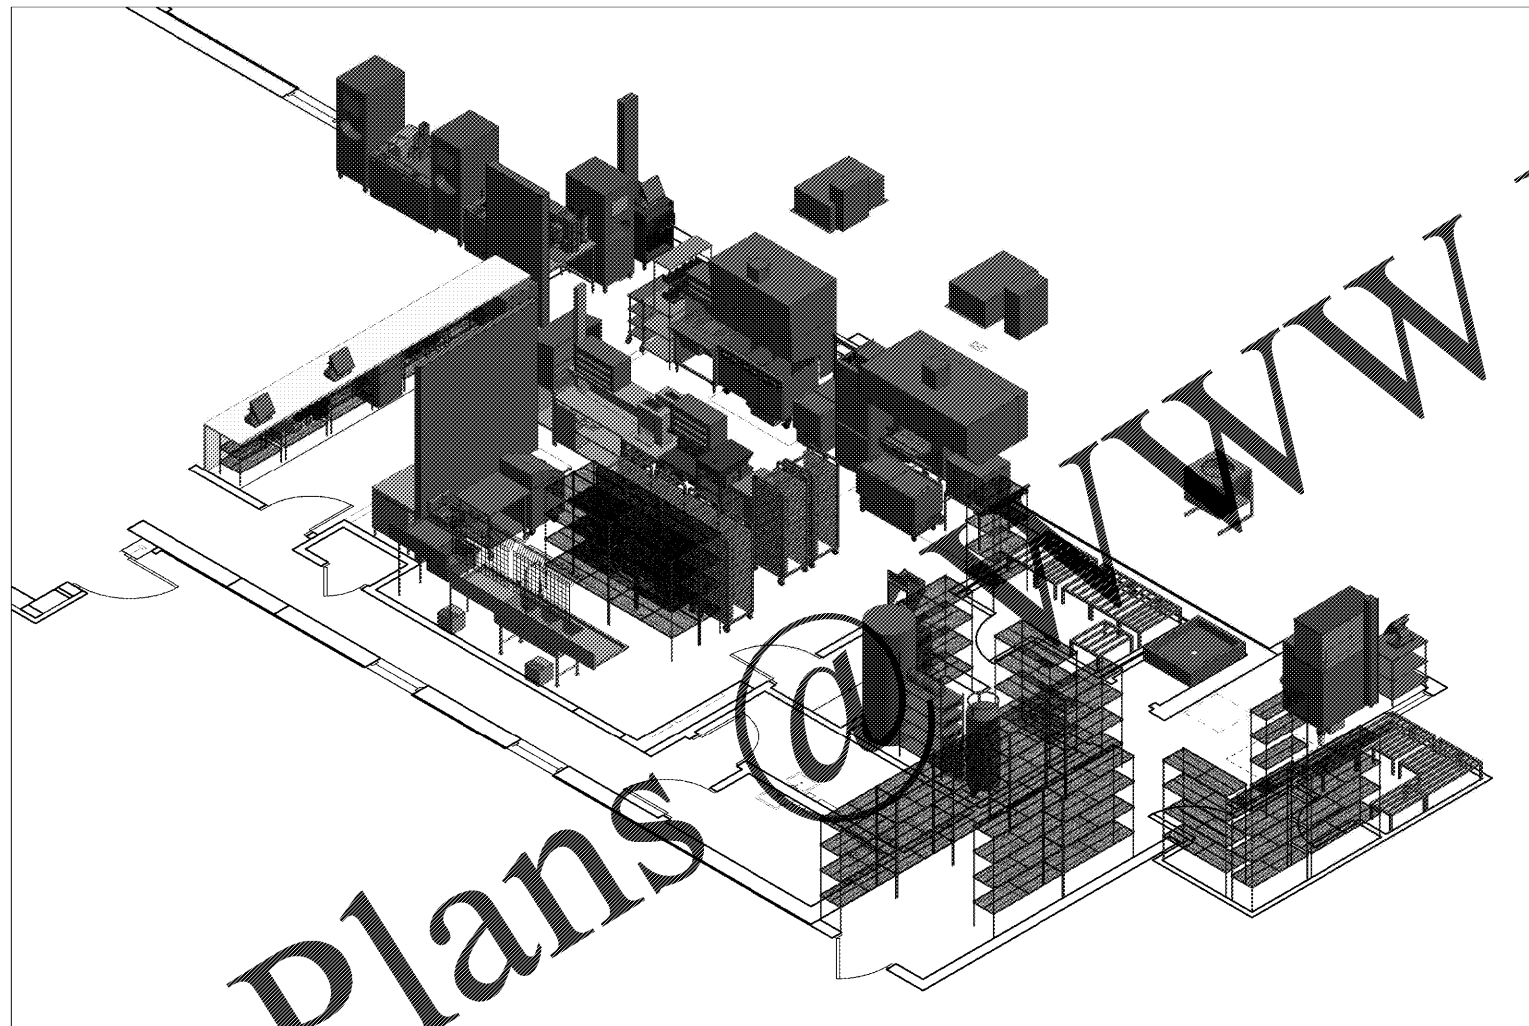

1 (3D)

SHEET LIST	
Sheet Number	Title
K0.0	KES COVER SHEET
K1.0	KES EQUIPMENT PLAN
K2.0	KES SCHEDULES
K3.0	KES ELEVATIONS
K4.0	KES NOTES AND DETAIL
KE1.1	KES ELECTRICAL PLAN
KM1.1	KES MECHANICAL PLAN
KP1.1	KES PLUMBING PLAN

REV #	DATE	DESCRIPTION
A	04/19/2018	Initial Issue

Make it Wonderful



Frankie Foodservice Supply, Inc.
800 Aviation Parkway
Smyrna, TN 37167
Tel. 400 472-2954
fr_customer-service-us@franke.com
www.franke-us.com

© 2017 Frankie Foodservice Systems, Inc. These drawings are specifications and the property of Frankie Foodservice Systems, Inc. and shall not be reproduced, copied or transmitted in any form, without the prior written consent of Frankie Foodservice Systems, Inc. Frankie Foodservice Systems, Inc. reserves the right to change equipment without notice.

Burger King
#2397
Title: KES COVER SHEET

Client: **Burger King**
Site Address: **998 SUNSET BLVD**
City: **JESUP**
State: **GA** Zip Code: **31545** Country: **USA**
Region: **NORTH AMERICA**
Structure Type: **FREESTANDING**

Electrical Service: **208V-230V**
Cook Service: **UNSPECIFIED**
Market Manager: **M. COUYOUMJIAN**
Frankie Project Number: **1393889**
Frankie Order Number: **5028196**
Created By: **HP033**
Date Issued: **04/19/2018**
Modified By: **HP033**
Drawing Scale: **As Noted**
Units: **INCH**
Drawing Number: **Jesup, GA.rte** Revision: **A**

Sheet Name: **K0.0**

EXISTING EQUIPMENT DEMOLISHED EQUIPMENT RELOCATED EQUIPMENT NEW EQUIPMENT FUTURE EQUIPMENT