


- KEYED ROOF PLAN NOTES**
1. PREFINISHED METAL COPING, OVERLAP SEAMS 1 1/2" MIN AT ALL JOINTS.
  2. PREFINISHED METAL CANOPY BELOW BY SIGN CO.
  3. VENT THROUGH ROOF, REFER TO MEP DRAWINGS
  4. ROOF PENETRATION FOR RADIO SATELLITE SYSTEM
  5. PRIMARY ROOF SCUPPER WITH CONDUCTOR HEAD AND DOWNSPOUT
  6. OVERFLOW SCUPPER
  7. EXHAUST FAN, REFER TO MEP DRAWINGS
  8. REMOTE CONDENSOR ON 4X4 TREATED SLEEPERS, TYPICAL
  9. DRAINAGE CRICKET, TYPICAL
  10. DURO-LAST WORK MATS, TYPICAL
  11. 4" DIAMETER SCHEDULE 40 PVC CHASE FOR FLEXIBLE REFRIGERANT PIPING
  12. REFRIGERATION LINES. SEE 8/A251
  13. SATELLITE. SEE 7/A251
  14. VENT TO ROOF. SEE MEP DRAWINGS

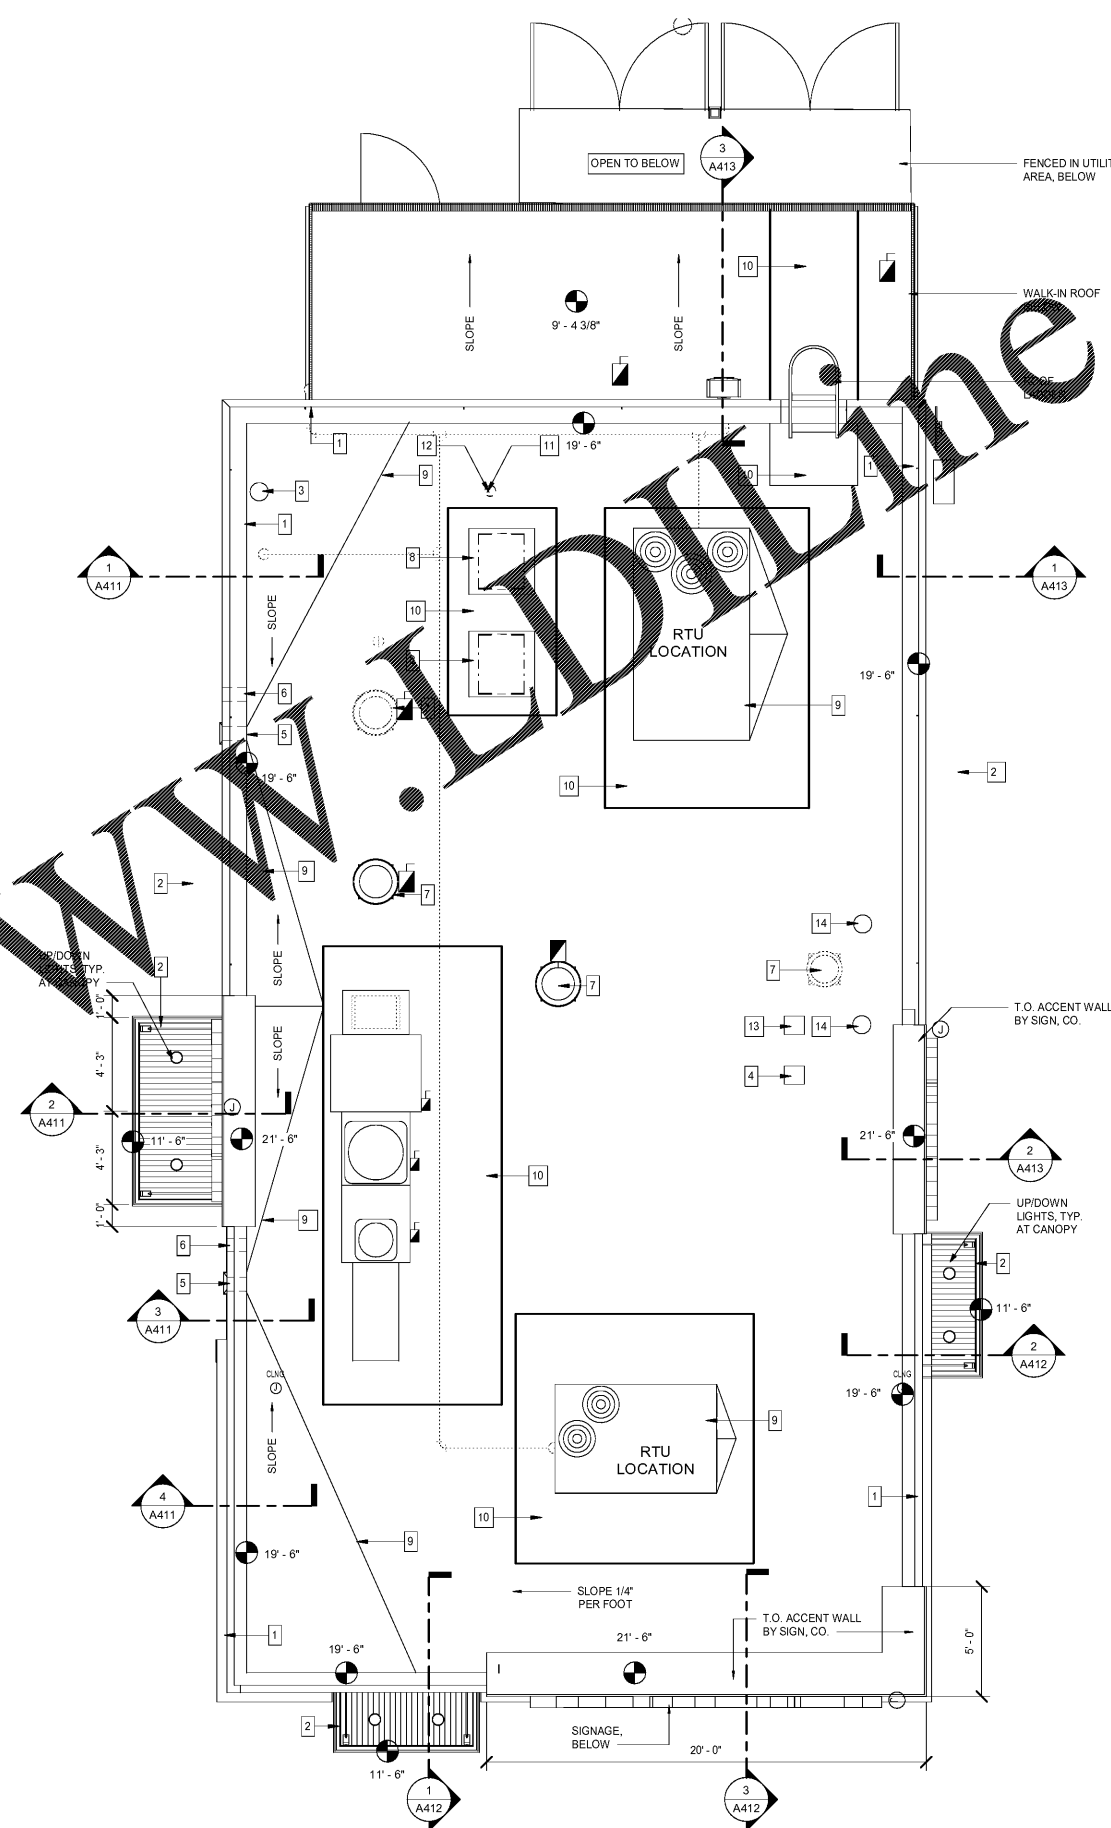

**1 ROOF PLAN**  
 SCALE: 1/4" = 1'-0"

#ATL034  
 CONYERS, GA

*Krystal*

ISSUED FOR  
 CONSTRUCTION

1447 Highway 138  
 Conyers, Georgia 30012  
 Rockdale County, Georgia

Revisions		
#	Date	Description

Project Number: 18028  
 Issued for: CONSTRUCTION  
 Issue Date: 03/22/18

DRAWING TITLE  
**ROOF PLAN AND NOTES**

SHEET NUMBER  
**A250**

Order Plans @ [www.ladline.com](http://www.ladline.com)