


- KEYED ROOF PLAN NOTES**
1. PREFINISHED METAL COPING, OVERLAP SEAMS 1 1/2" MIN AT ALL JOINTS.
 2. PREFINISHED METAL CANOPY BELOW BY SIGN CO.
 3. VENT THROUGH ROOF, REFER TO MEP DRAWINGS
 4. ROOF PENETRATION FOR RADIO SATELLITE SYSTEM
 5. PRIMARY ROOF SCUPPER WITH CONDUCTOR HEAD AND DOWNSPOUT
 6. OVERFLOW SCUPPER
 7. EXHAUST FAN, REFER TO MEP DRAWINGS
 8. REMOTE CONDENSOR ON 4X4 TREATED SLEEPERS, TYPICAL
 9. DRAINAGE CRICKET, TYPICAL
 10. DURO-LAST WORK MATS, TYPICAL
 11. 4" DIAMETER SCHEDULE 40 PVC CHASE FOR FLEXIBLE REFRIGERANT PIPING
 12. REFRIGERATION LINES. SEE 8/A251
 13. SATELLITE. SEE 7/A251
 14. VENT TO ROOF. SEE MEP DRAWINGS

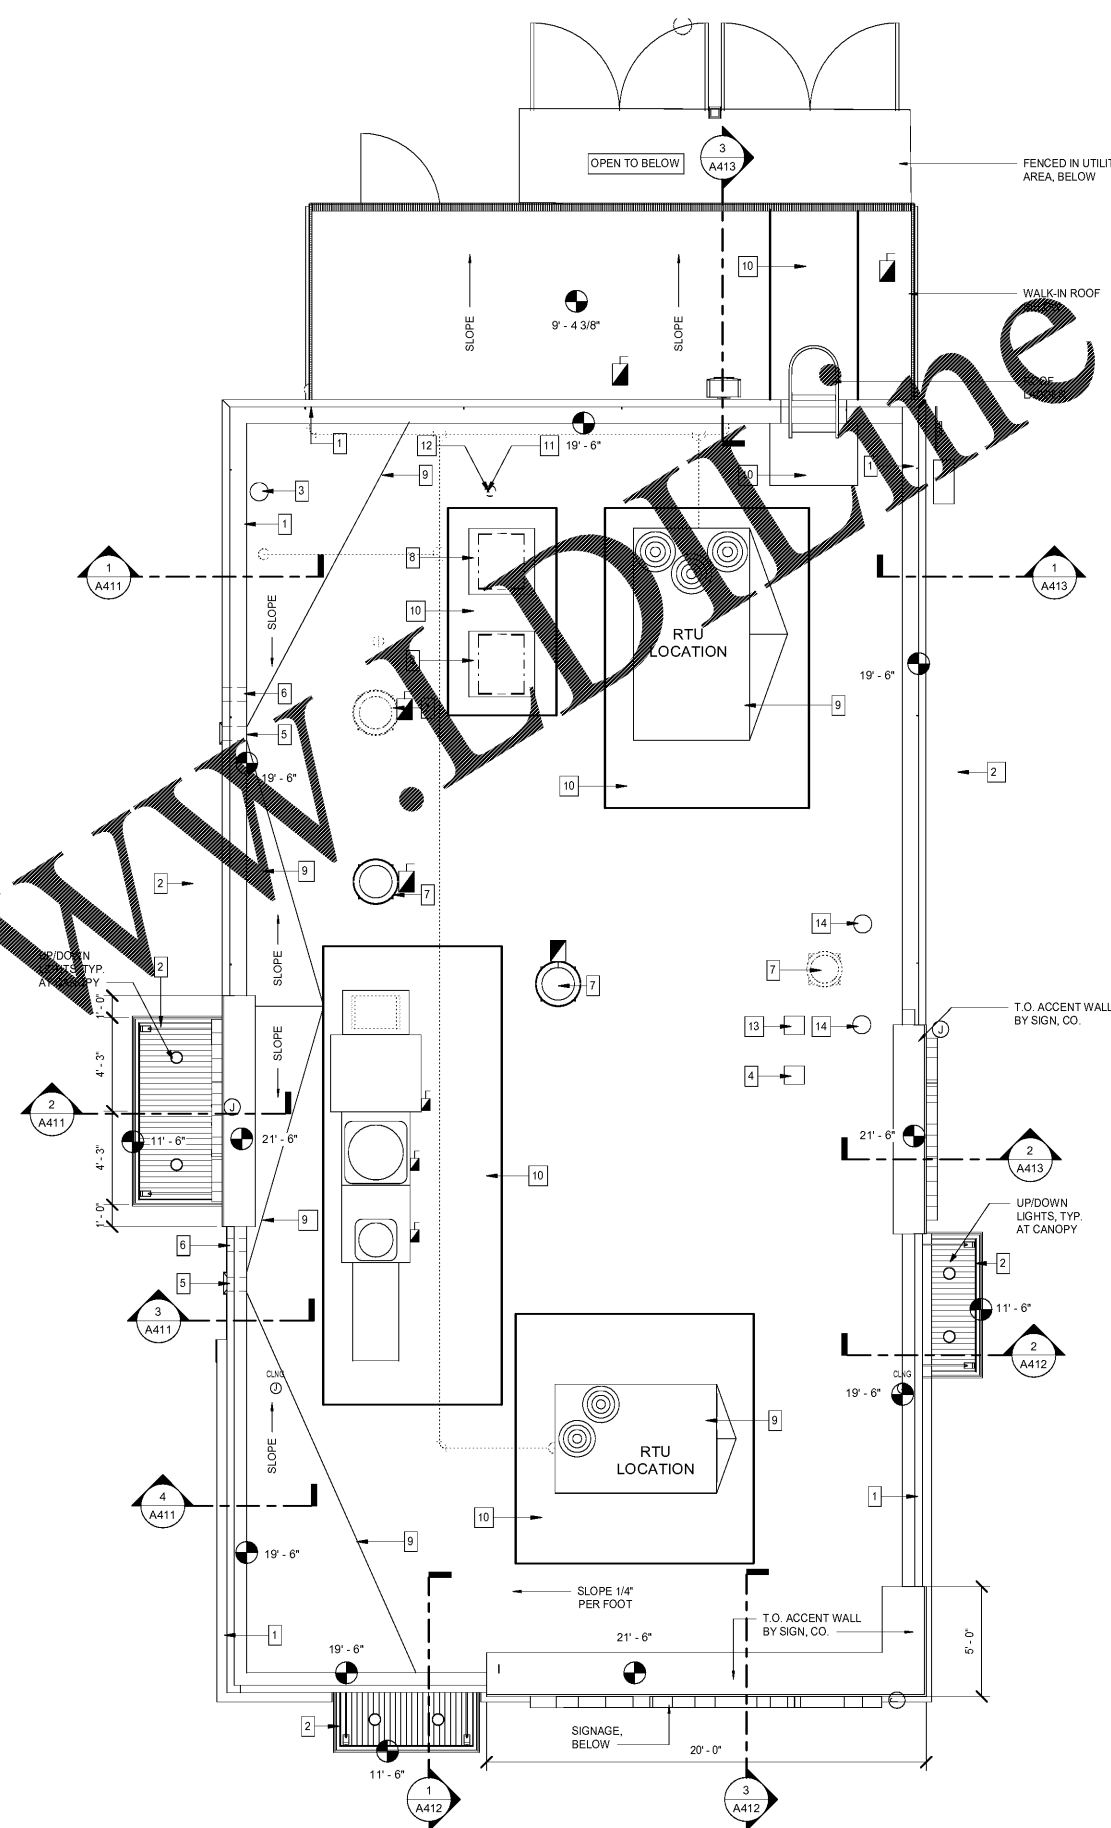

1 ROOF PLAN
 SCALE: 1/4" = 1'-0"

#ATL034
 CONYERS, GA

Krystal

ISSUED FOR
 CONSTRUCTION

1447 Highway 138
 Conyers, Georgia 30012
 Rockdale County, Georgia

Revisions		
#	Date	Description

Project Number: 18028
 Issued for: CONSTRUCTION
 Issue Date: 03/22/18

DRAWING TITLE
ROOF PLAN AND NOTES

SHEET NUMBER
A250

Order Plans @ www.ladline.com