



#ATL034
 CONYERS, GA



ISSUED FOR
 CONSTRUCTION

1447 Highway 138
 Conyers, Georgia 30012
 Rockdale County, Georgia

Revisions		
#	Date	Description

Project Number: 18028
 Issued for: CONSTRUCTION
 Issue Date: 03/22/18


DRAWING TITLE
EXTERIOR ELEVATIONS

SHEET NUMBER
A302

EXTERIOR MATERIAL LEGEND			
EIFS-1	2" EIFS WALL FINISH WITH REVEALS COLOR: SW7067 CITYSCAPE, EGG SHELL STYLE: WATER BASED ACROLON 100 MANUFACTURER: SHERWIN WILLIAMS	CMU-1	DECORATIVE CMU WALL BASE COLOR: DARK GRAY STYLE: 4"Wx8"Hx16"L W/2"x2" CHAM. EDGE PAINT SW7067 CITYSCAPE, EGG SHELL MANUFACTURER: SHERWIN WILLIAMS
EIFS-2	4" EIFS WALL DETAIL COLOR: SW7006 EXTRA WHITE, GLOSS STYLE: WATER BASED ACROLON 100 MANUFACTURER: SHERWIN WILLIAMS	CA-1	ALUMINUM STOREFRONT/ DRIVE-THRU WINDOW COLOR: YSNI CLEAR ANODIZED PLUS STYLE: 4 1/2" ALUMINUM FRAMING MANUFACTURER: YKAP MODEL 20D
EIFS-3	2" EIFS WALL FINISH WITH REVEALS COLOR: SW7064 PASSIVE, EGG SHELL STYLE: WATER BASED ACROLON 100 MANUFACTURER: SHERWIN WILLIAMS	GL-1	STOREFRONT GLAZING COLOR: CLEAR VISION GLASS STYLE: 1" INSULATED GLAZING MANUFACTURER: YKAP MODEL 20D
MP-1	PBC CORRUGATED METAL WALL PANEL COLOR: SLATE GRAY SIGNATURE-300 STYLE: CORRUGATED W/ EXPOSED FASTENERS MANUFACTURER: MBCI	C-1	CANOPIES / OPEN TRELLIS COLOR: WHITE STYLE: ALUMINUM FRAME/ FINISH MANUFACTURER: CAPITAL SIGNS & AWNINGS, LLC.
MP-2	METAL PANEL ACCENT WALLS COLOR: SW 5868 REAL RED STYLE: ACM METAL PANELS MANUFACTURER: CAPITAL SIGNS & AWNINGS, LLC.	C-2	EYEBROW CANOPIES COLOR: WHITE STYLE: ALUMINUM FRAME/ FINISH MANUFACTURER: CAPITAL SIGNS & AWNINGS, LLC.
PT-1	ALUMINUM COPING COLOR: SW 5868 REAL RED, GLOSS STYLE: WATER BASED ACROLON 100 MANUFACTURER: SHERWIN WILLIAMS	S-1	KRISTAL LOGO COLOR: WHITE STYLE: ALUMINUM FRAME/ FINISH MANUFACTURER: CAPITAL SIGNS & AWNINGS, LLC.
PT-2	STEEL ROOF LADDER COLOR: SW7067 CITYSCAPE, EGG SHELL STYLE: PRO INDUSTRIAL ACRYLIC MANUFACTURER: SHERWIN WILLIAMS	T-1	FENCING / FRAMING / GATES COLOR: WINCHESTER GREY STYLE: TREX FENCING MANUFACTURER: TREX
PT-3	WALK-IN COOLERS / FREEZERS COLOR: SW7064 PASSIVE, EGG SHELL STYLE: WATER BASED ACROLON 100 MANUFACTURER: SHERWIN WILLIAMS	L-1	LIGHT FIXTURES COLOR: SEE ELECTRICAL LIGHTING SCHEDULE STYLE: SEE ELECTRICAL LIGHTING SCHEDULE MANUFACTURER: SEE ELECTRICAL LIGHTING SCHEDULE
W-1	ARTWORK - POP 60X60 COLOR: SEE ELECTRICAL LIGHTING SCHEDULE STYLE: SEE ELECTRICAL LIGHTING SCHEDULE MANUFACTURER: SEE ELECTRICAL LIGHTING SCHEDULE	F-1	PERIMETER WOOD FENCE (ALTERNATE) COLOR: WINCHESTER GRAY STYLE: TREX FENCING MANUFACTURER: TREX
W-2	ARTWORK - POP 60X60 COLOR: SEE ELECTRICAL LIGHTING SCHEDULE STYLE: SEE ELECTRICAL LIGHTING SCHEDULE MANUFACTURER: SEE ELECTRICAL LIGHTING SCHEDULE	WC-2	REMOTE WALK-IN COOLERS / FREEZERS (ALTERNATE) COLOR: SW7064 PASSIVE, EGG SHELL STYLE: WATER BASED ACROLON 100 MANUFACTURER: SHERWIN WILLIAMS


ELEVATIONS NOTES	
1.	SEE 3/A504 FOR METAL PANEL FASTENING PATTERN
2.	DOWNSPOUTS SHALL BE GRAY TO MATCH BACKGROUND WALL FINISH COLOR
3.	PROVIDE SEALANT BETWEEN EIFS TRIM AND EIFS DETAIL AT MURAL WALLS/ MURAL LIGHTS

SIGNAGE CALCS.	
TOTALS BY SIGN	
FRONT (STREET) "KRISTAL" SIGN	= 34.42 SF
EAST "KRISTAL" SIGN	= 9.28 SF
EAST (3) KRISTAL MURALS	= 64.44 SF
WEST "KRISTAL" SIGN	= 9.28 SF
WEST (3) KRISTAL MURALS	= 64.44 SF
TOTAL SF OF BUILDING SIGNAGE	= 181.86 SF
TOTALS BY ELEVATION	
FRONT (STREET) ELEVATION	= 34.42 SF
EAST ELEVATION	= 73.72 SF
WEST ELEVATION	= 73.72 SF
TOTAL SF OF BUILDING SIGNAGE	= 181.86 SF

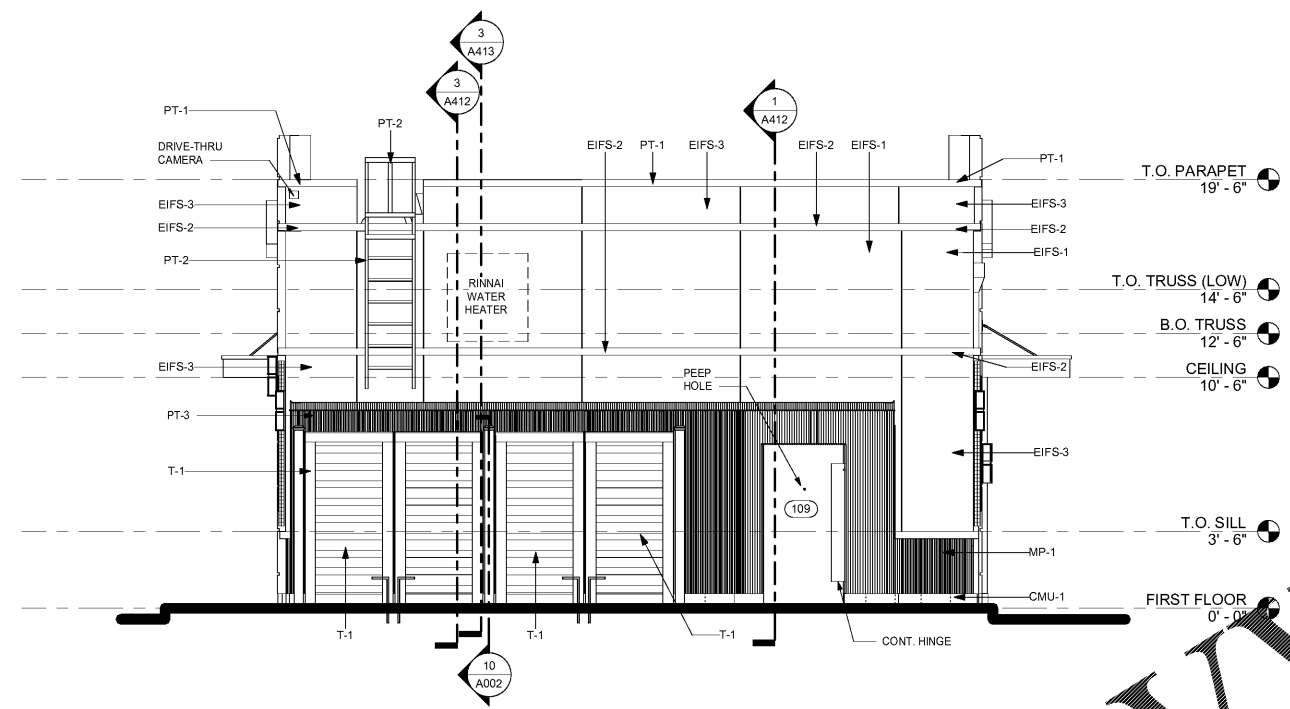

2 EXTERIOR ELEVATION - NORTH
 SCALE: 1/4" = 1'-0"

REAR ELEVATION MATERIAL CALCS.	
EIFS	= 350 SF 95.55%
METAL PANEL	= 20 SF 5.55%
TOTAL	= 370 SF 100.00%

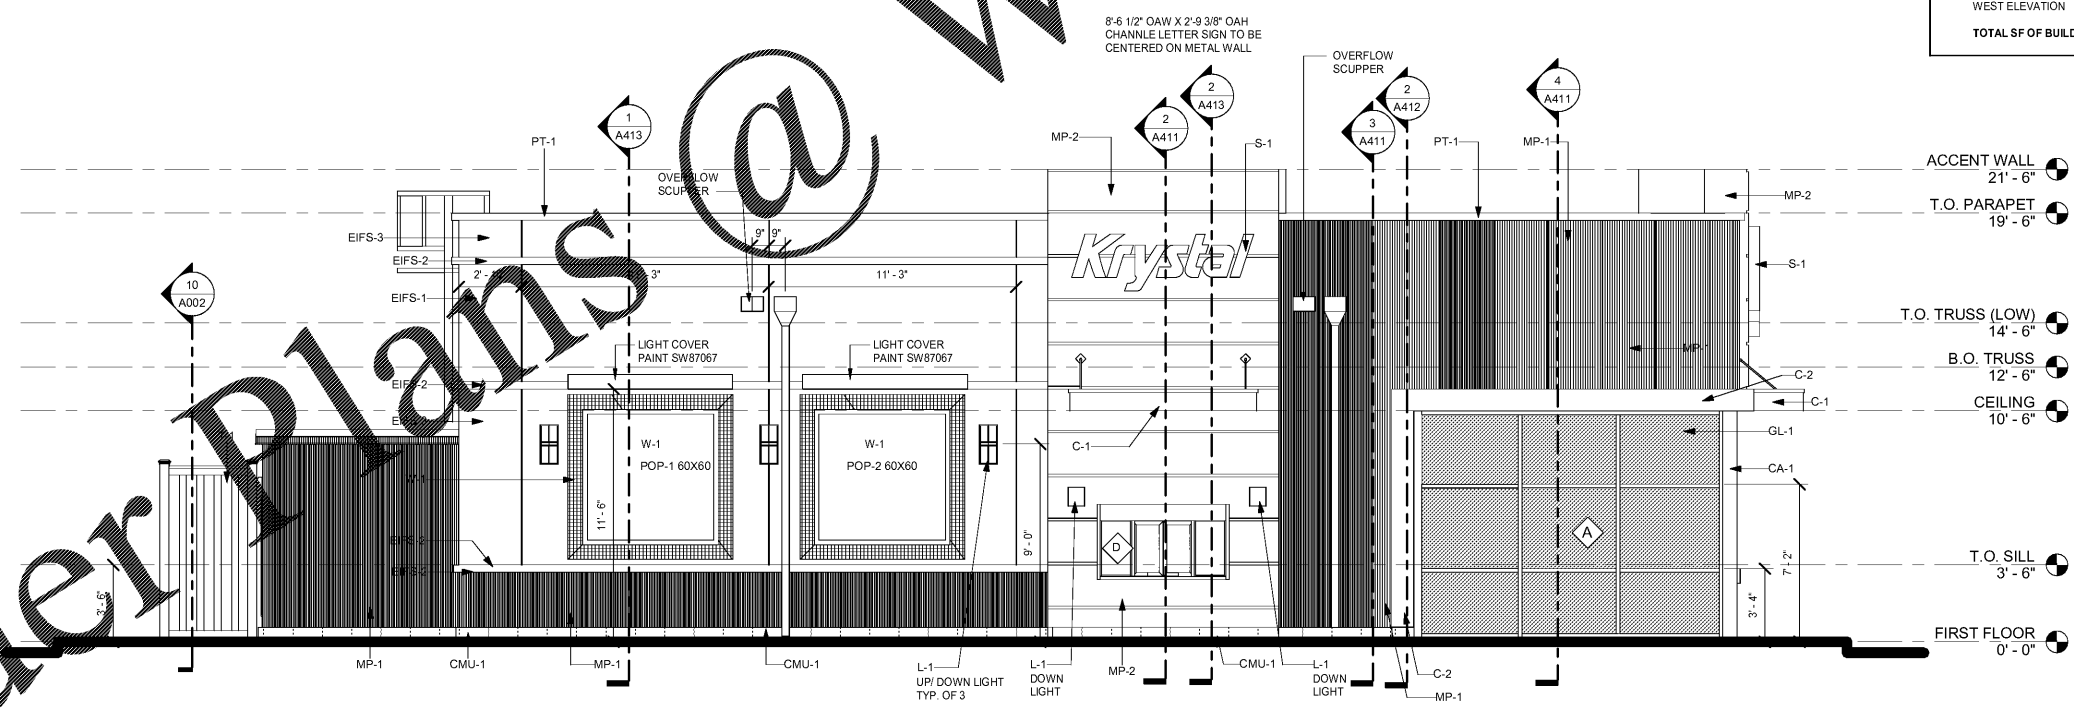

1 EXTERIOR ELEVATION - WEST
 SCALE: 1/4" = 1'-0"

WEST ELEVATION MATERIAL CALCS.	
STOREFRONT	= 170 SF 13.77%
METAL PANEL	= 625 SF 50.60%
EIFS	= 440 SF 35.63%
TOTAL	= 1,235 SF 100.00%

Order Plans @

WWW.LDINW.COM