



03.22.2018

#ATL034
 CONYERS, GA



ISSUED FOR
 CONSTRUCTION

1447 Highway 138
 Conyers, Georgia 30012
 Rockdale County, Georgia

Revisions		
#	Date	Description


Project Number: 18028
 Issued for: CONSTRUCTION
 Issue Date: 03/22/18

DRAWING TITLE
EQUIPMENT PLAN

SHEET NUMBER
A701

STORAGE CALCULATIONS	
DRY STORAGE	
ITEM 23	7 UNITS WITH 4 SHELVES 24X60 SHELVES @ 10 LF PER SHELF = 280 LF
ITEM 37.1	2 UNITS WITH 4 SHELVES 18X60 SHELVES @ 7.5 LF PER SHELF = 060 LF
FREEZER STORAGE	
ITEM 33	6 UNITS WITH 1 SHELF 24X48 SHELF @ 8 LF PER SHELF = 048 LF
COOLER STORAGE	
ITEM 35	2 UNITS WITH 4 SHELVES 24X36 SHELVES @ 6 LF PER SHELF = 048 LF
ITEM 35	2 UNITS WITH 4 SHELVES 24X60 SHELVES @ 10 LF PER SHELF = 080 LF
TOTAL STORAGE ALL TYPES	516 LF

- | EQUIPMENT NOTES |
|--|
| 1. WALK-IN REFRIGERANT LINES SHOULD BE ROUTED FROM WALK-INS TO ROOF IN WALL CAVITY. SEE CUTSHEETS FOR ADDITIONAL INFORMATION |
| 2. SEE MECHANICAL, ELECTRICAL, PLUMBING DRAWINGS FOR ADDITIONAL EQUIPMENT REQUIREMENTS |
| 3. SEE A 702 FOR EQUIPMENT SCHEDULE. |
| 4. REFER TO EQUIPMENT CUTSHEETS FOR ADDITIONAL INFORMATION |
| 5. WATER FILTRATION SYSTEM FURNISHED BY EQUIPMENT SUPPLIER AND INSTALLED BY GENERAL CONTRACTOR. |

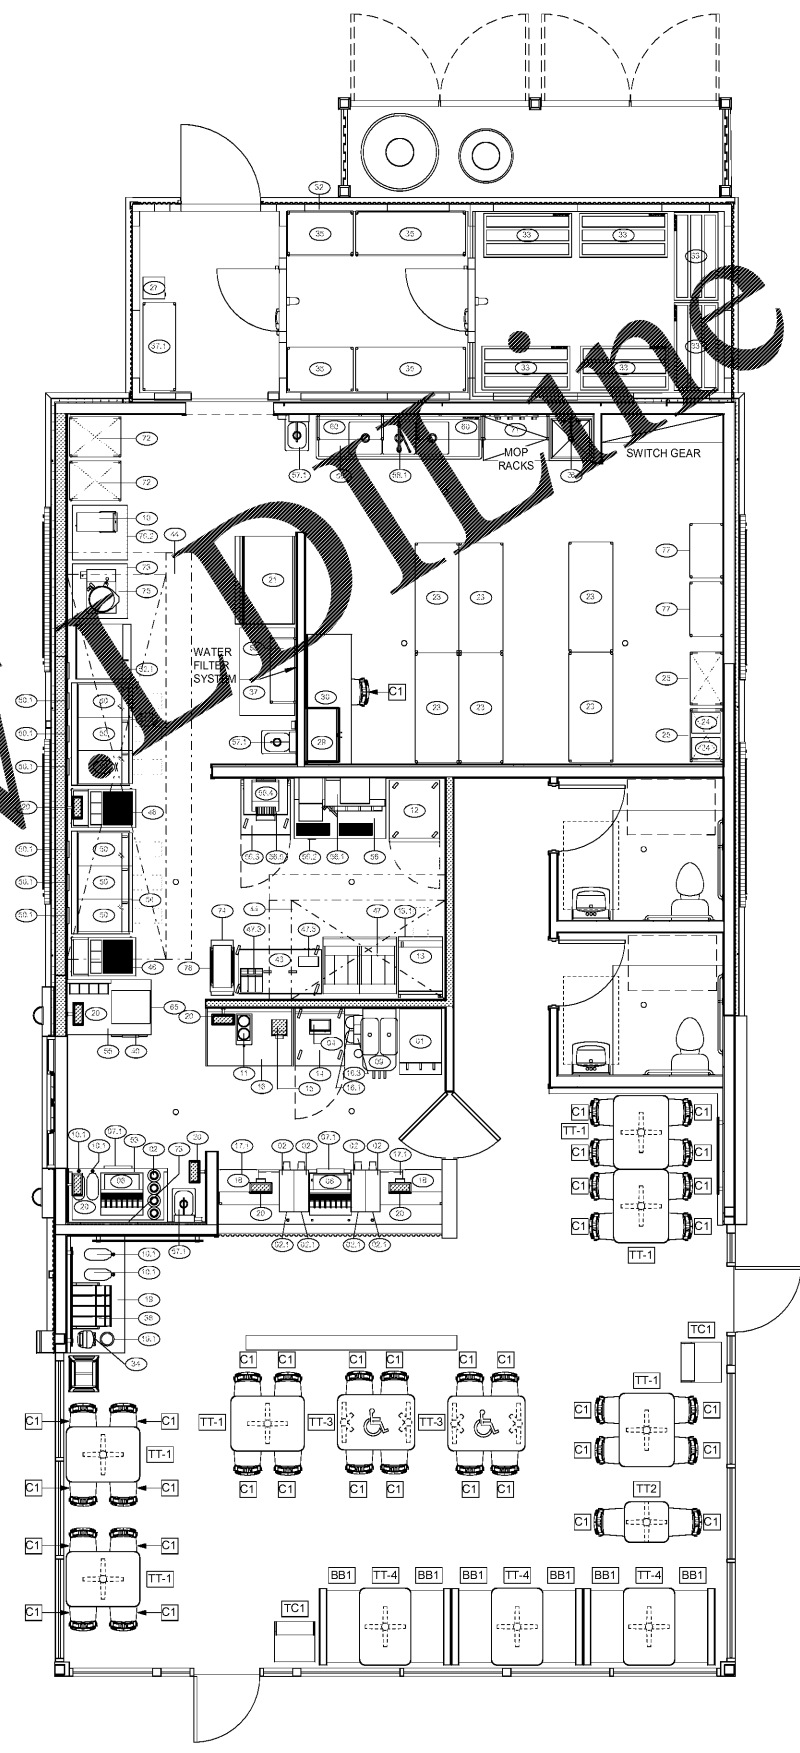

1 EQUIPMENT FLOOR PLAN
 SCALE: 1/4" = 1'-0"

Order Plans @ www.wldline.com