


THE KNEE WALL MUST INCLUDE (1) QUAD POWER OUTLET AT HAND OFF COUNTER FOR ON-THE-GO EQUIPMENT AS SHOWN. IF RESTAURANT DESIGN DOES NOT INCLUDE HAND OFF COUNTER THE QUAD OUTLET MUST BE LOCATED IN KNEE WALL AT END OF COFFEE STATION ADJACENT TO HAND OFF GATE. WHEN HAND OFF COUNTER AND GATE ARE NOT PROVIDED QUAD OUTLET ARE INSTALLED AT DESIGNATED HAND OFF AREA AT POS COUNTER ADJACENT TO COFFEE STATION.

KEYED NOTES:

1. SEE POS AND COMMUNICATIONS. PLAN FOR FURTHER INFORMATION REGARDING POS AND UNDER COUNTER ELECTRICAL SERVICE.
2. ELECTRICAL CONTRACTOR TO PROVIDE 25 FT. PIGTAIL FOR DONUT CASE WIRING.
3. PROVIDE RED ILLUMINATED SWITCH FOR HOOD EXHAUST FAN CONTROL AND LIGHTS. PROVIDE TAG ABOVE SWITCH IDENTIFYING HOOD USE.
4. NEW HAND DRYERS, E.C. SHALL INSTALL J-BOX PER MANUFACTURERS SPECIFICATIONS/ INSTALLATION GUIDE. PROVIDE LOCKABLE BREAKER PER NEC 422.31.
5. REFER TO POS COMMUNICATIONS FLOOR PLAN FOR LOCATIONS AND ELEVATIONS OF OFFICE RECEPTACLES.
6. NOT USED.
7. CONNECT THE DRIVE THRU MENU BOARD LIGHTING AND DT CANOPY LIGHTING CIRCUITS TO THE TIMECLOCK.
8. NOT USED.
9. EQUIPMENT MOUNTED ON ROOF. SEE MECHANICAL DRAWINGS FOR EXACT LOCATIONS.
10. EXISTING ELECTRICAL PANELS TO REMAIN.
11. CONTRACTOR TO MOUNT RECEPTACLE IN THE SOFFIT BEHIND THE MENUBOARD. VERIFY ACTUAL LOCATION WITH ARCHITECT PRIOR TO INSTALLING.
12. NOT USED.
13. CONTRACTOR SHALL PROVIDE POWER AND NECESSARY WIRING FOR THE HOOD ELECTRICAL PANEL. SEE THE CAPTIVE WIRE DRAWINGS FOR WIRING REQUIREMENTS.
14. CONTROL RELAY PANEL. SEE LIGHTING PLAN FOR SCHEDULE AND CONTROL. SEE MECHANICAL DRAWINGS FOR ADDITIONAL INFORMATION.

RECEPTACLES TAGGED WITH "USB" IN THE SALES & SEATING AREAS SHALL BE HUBBELL USB15X21 (IVORY) / NP261 (IVORY) COMBO USB CHARGER WITH TAMPER RESISTANT RECEPTACLE.
 SEATING AREA RECEPTACLES SHALL BE IVORY WITH IVORY COVER PLATE AND ARE TO BE MOUNTED AT 3'-2 1/2" AFF.

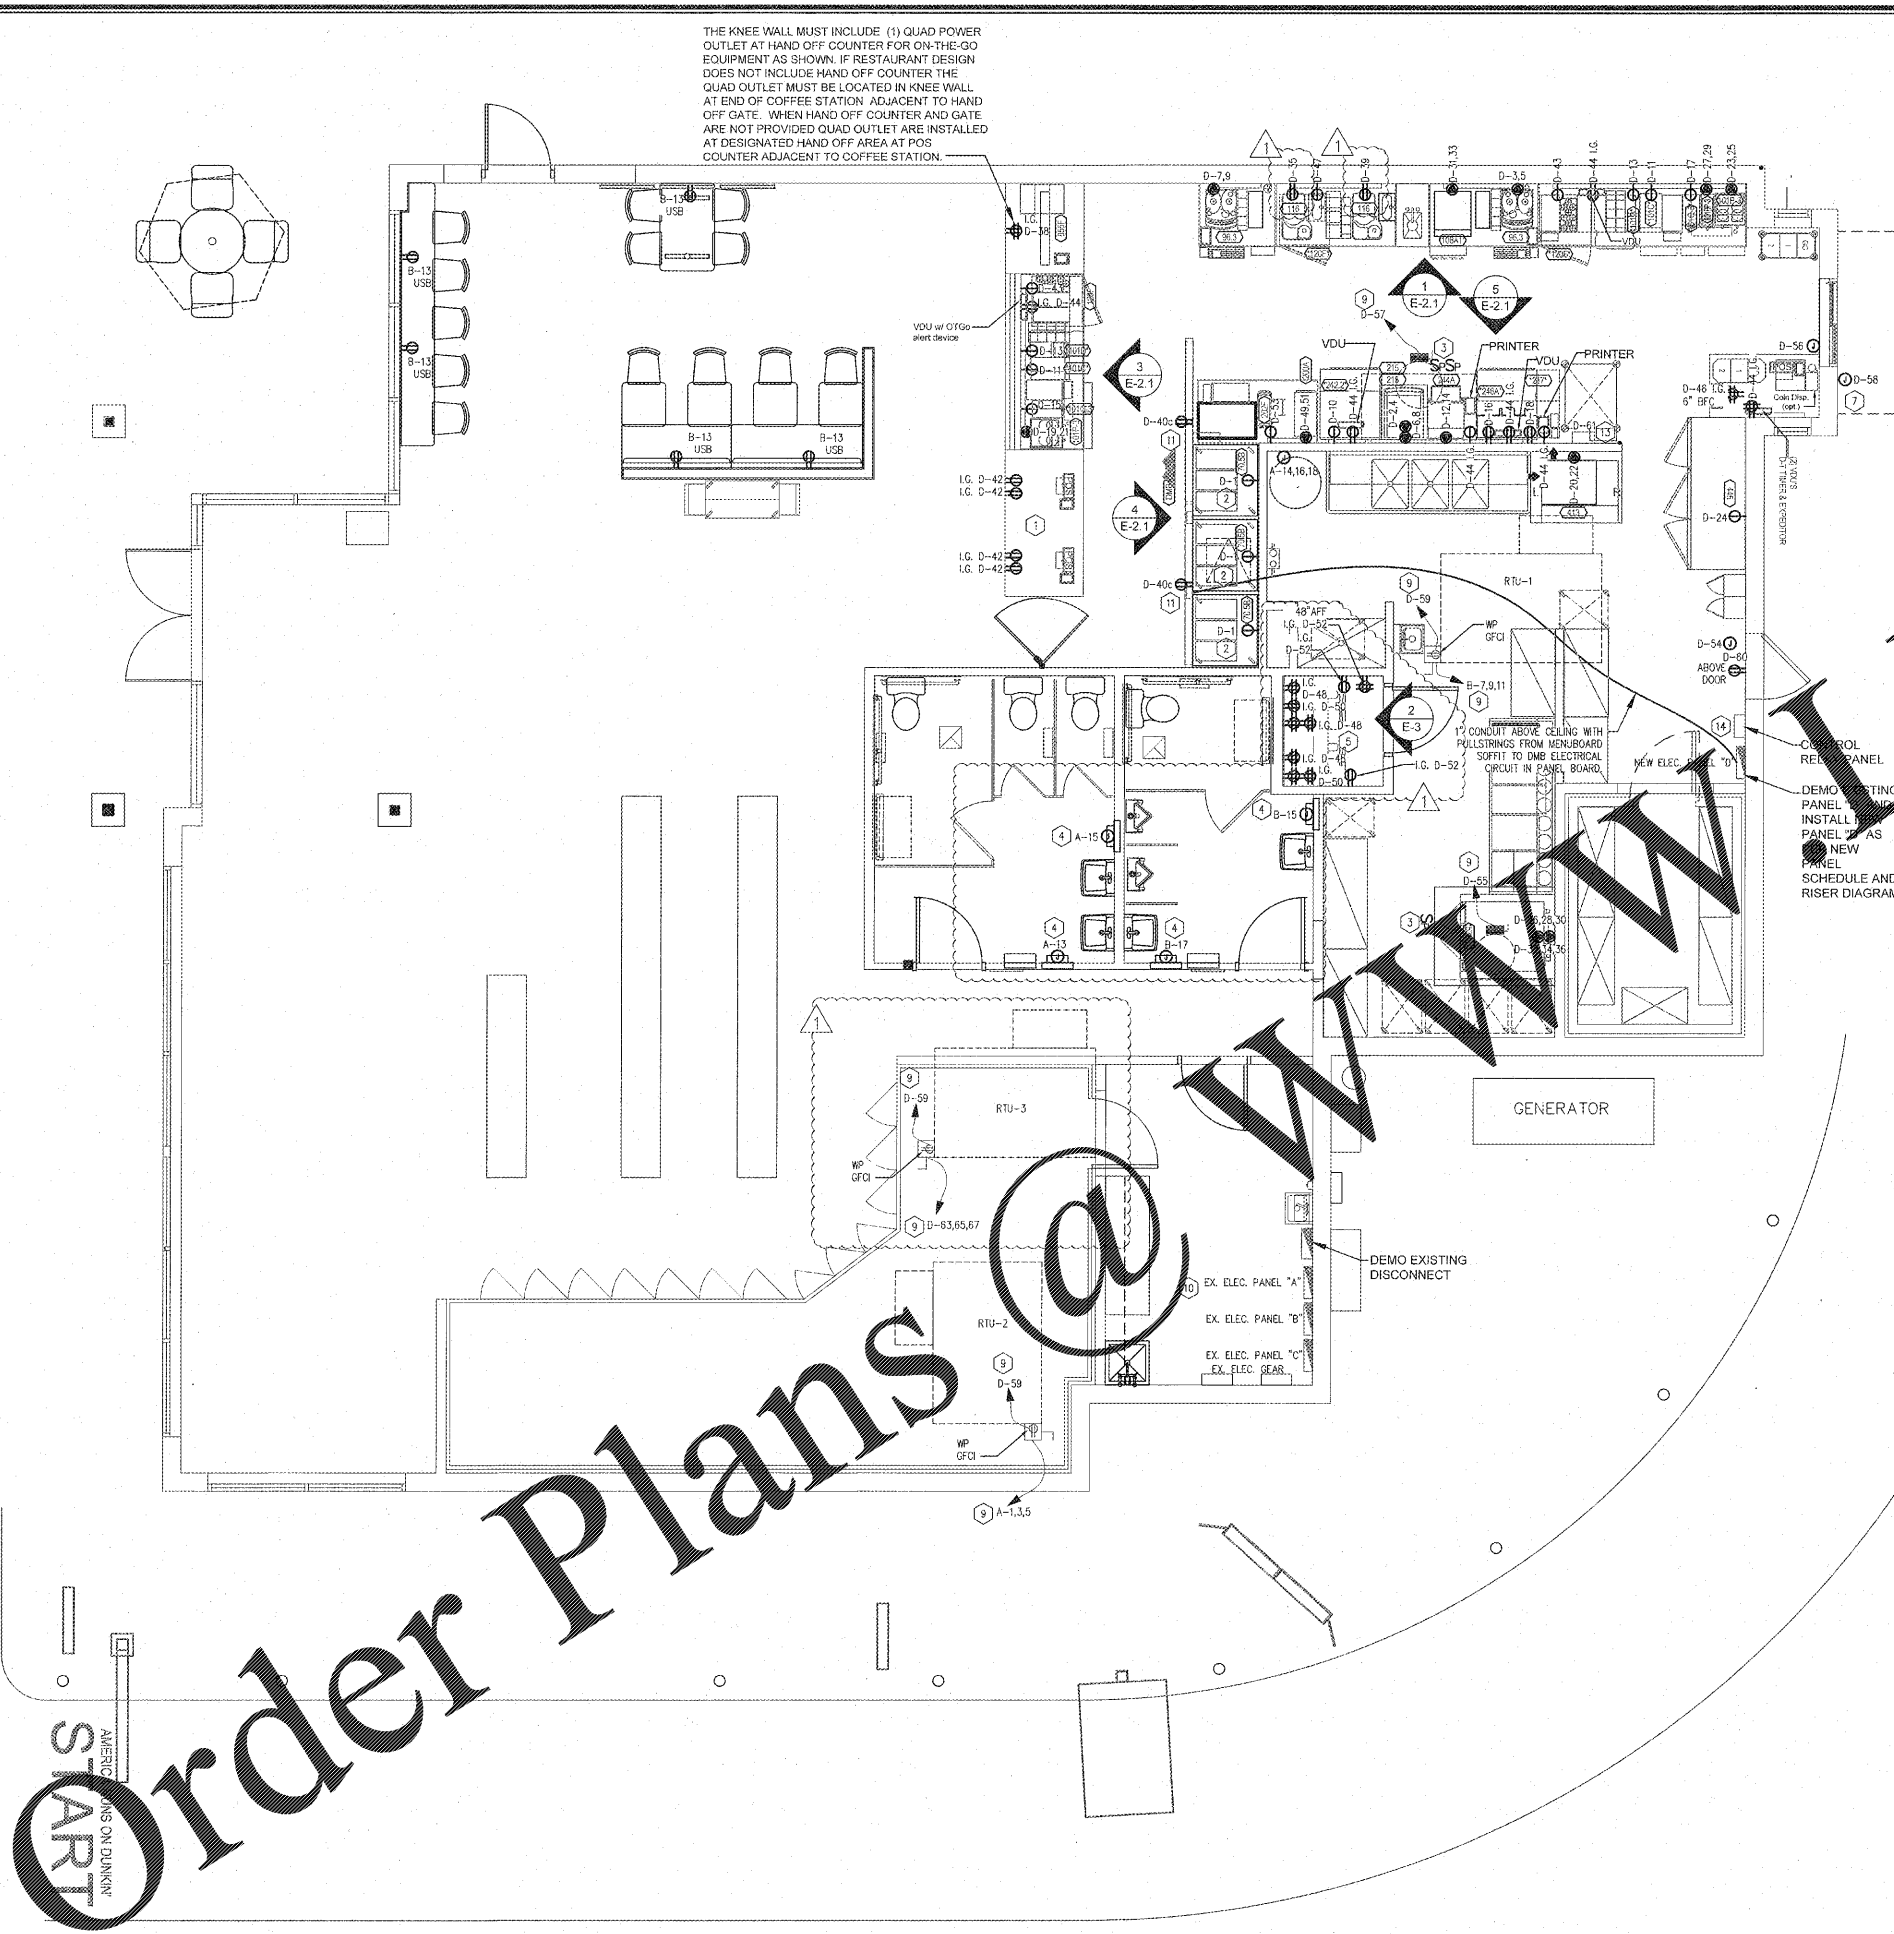

START
 AMERICAN
 BRANDS ON DUNKIN'

1 POWER PLAN
 1/4"=1'-0"

THESE PLANS ARE CONFIDENTIAL PROPERTY OF DUNKIN' BRANDS, INC. UNDER RESTRICTED ACCESS.

Dunkin' Brands

PROJECT NO.: 17229

NRD national
 ARCHITECTS & ENGINEERS
 restaurant
 designers

3005 Corrington Mill Blvd., Morrisville, NC 27560
 ph: 919 544 7251 fax: 919 544 9399
 A Division of LMHT Associates

STATE OF VIRGINIA
 PROFESSIONAL SEAL
 REGISTERED PROFESSIONAL ENGINEER
 IN ELECTRICAL

NO	DESCRIPTION	DATE	DATE	DATE
1	OWNER COMMENTS (RESTROOM CHANGE)	5/2/18	3-18-18	
			SCALE	
			DRAWN	CTT
			CKD	DRS
			APPD	DRS

DD FRESH BREW 1.0
 908 MARKET DRIVE, EMPORIA, VA

**ELECTRICAL
 POWER PLAN**

PC# 358084

E-2.0

NOTE: DRAWINGS ARE NOT TO SCALE IF SHEET IS PLOTTED ON 11" x 17"