

- NOTE:
- COORDINATE WITH STRUCTURAL, PLUMBING, MECHANICAL AND ELECTRICAL FOR ALL ITEMS PROVIDED BY THOSE DISCIPLINES. CONTRACTOR SHALL BE RESPONSIBLE FOR LAYING OUT ALL CEILING MOUNTED ELEMENTS WITH ALL OTHER CEILING MOUNTED EQUIPMENT AND STRUCTURE AND CORRECTING ANY INTERFERENCE PRIOR TO INSTALLATION.
 - PREPARE AND PAINT ALL CEILING MOUNTED ITEMS ON SALES FLOOR, INCLUDING BUT NOT LIMITED TO HVAC DIFFUSERS AND RETURNS, THREADED ROD, CONDUIT AND SPRINKLER PIPING.
 - PREPARE AND PAINT 6-WAY DIFFUSER IN ITS ENTIRETY; INCLUDING DRUM DIFFUSERS. ROTATE DRUM DIFFUSER TO ENSURE FULL COVERAGE. AFTER MECHANICAL CONTRACTOR POSITIONS DRUM DIFFUSERS, TOUCH UP DRUM DIFFUSER PAINT.
 - ALL DIMENSIONS ARE TO FACE OF WALL FINISH UNLESS OTHERWISE NOTED.
 - ALL DIMENSIONS TO LIGHT LOCATIONS ARE TO CENTERLINE OF FIXTURE.
 - CALK ALL SUSPENDED CEILING TO WALL INTERSECTIONS - SEE SPEC SECTION 079200.
 - ALL INTERIOR WALLS EXCEPT SHADED PORTIONS EXTEND TO UNDERSIDE OF DECK.
 - ATTACH POWERPOLE TO ROOF STRUCTURE WITH UNISTRUT (TYP. AT CHECKLANES AND SPOT MERCHANTISERS) - PAINT UNISTRUT TO MATCH CEILING.
 - GC TO ENSURE ALL JOIST AND JOIST GIRDER TAGS ARE PROPERLY SECURED TO JOIST WEBBING AND CONCEALED FROM VIEW PRIOR TO PAINTING.
 - NORDEON LIGHTING SYSTEM SHALL BE OWNER FURNISHED AND CONTRACTOR INSTALLED. CONTRACTOR SHALL HAVE FIVE (5) DAYS FROM DATE OF DELIVERY ACCEPTANCE TO VERIFY SHIPMENT FOR ANY DAMAGES; CORRECT QUANTITY OF FIXTURES AND PLACE A CLAIM. AFTER FIVE (5) DAYS THE CONTRACTOR SHALL BE RESPONSIBLE FOR ANY DAMAGES AND ADDITIONAL FIXTURES REQUIRED.
 -

LEGEND:

SPRINKLER HEAD	
EXIT SIGN	
EMERGENCY LIGHT	
2' X 4' RECESSED LIGHT FIXTURE	
1' X 4' RECESSED LIGHT FIXTURE	
WALL PACK OR SCIENCE	
4' STRIP LIGHT FIXTURE	
8' STRIP LIGHT FIXTURE	
RETURN AIR GRILLE	
SUPPLY DIFFUSER	
SHADE FIXTURES ARE NIGHT LIGHTS - SEE LIGHTING PLAN	

Issued:	Date:
A Permit Set	12/05/17
B Client Review Set	05/03/18
C Bid Set	05/11/18
D	
Revisions:	Date:
1	
2	
4	
5	
7	
8	
9	

DO NOT SCALE PLANS

Copying, Printing, Software and other processes required to produce these prints can stretch or shrink the actual paper or layout. Therefore, scaling of this drawing may be inaccurate. Contact ms consultants with any need for additional dimensions or clarifications.

ms consultants, inc.
 engineers, architects, planners
 920 Main Campus Drive
 Suite 430
 Raleigh, NC 27606-5213
 phone 919.772.5565
 fax 919.779.2308


DRAWN BY: MEM/KNW
 REVIEWED BY: JAB

Seal

ALDI Inc.
 1985 Old Union Church Road
 Salisbury, NC 28146
 (704) 642-0023
 (704) 642-0078 fax

ALDI Inc. Store #: 65
 Charlotte, NC
 6113 Idlewild Road
 Charlotte, NC 28212
 Mecklenburg County
 Project Name & Location:

Reflected Ceiling Plan	Project No.
Drawing Name:	40452-13
Prototype Rls. 09/07/17	
Type: LHSD-V8	
	A-111
Scale: As Noted	Drawing No.

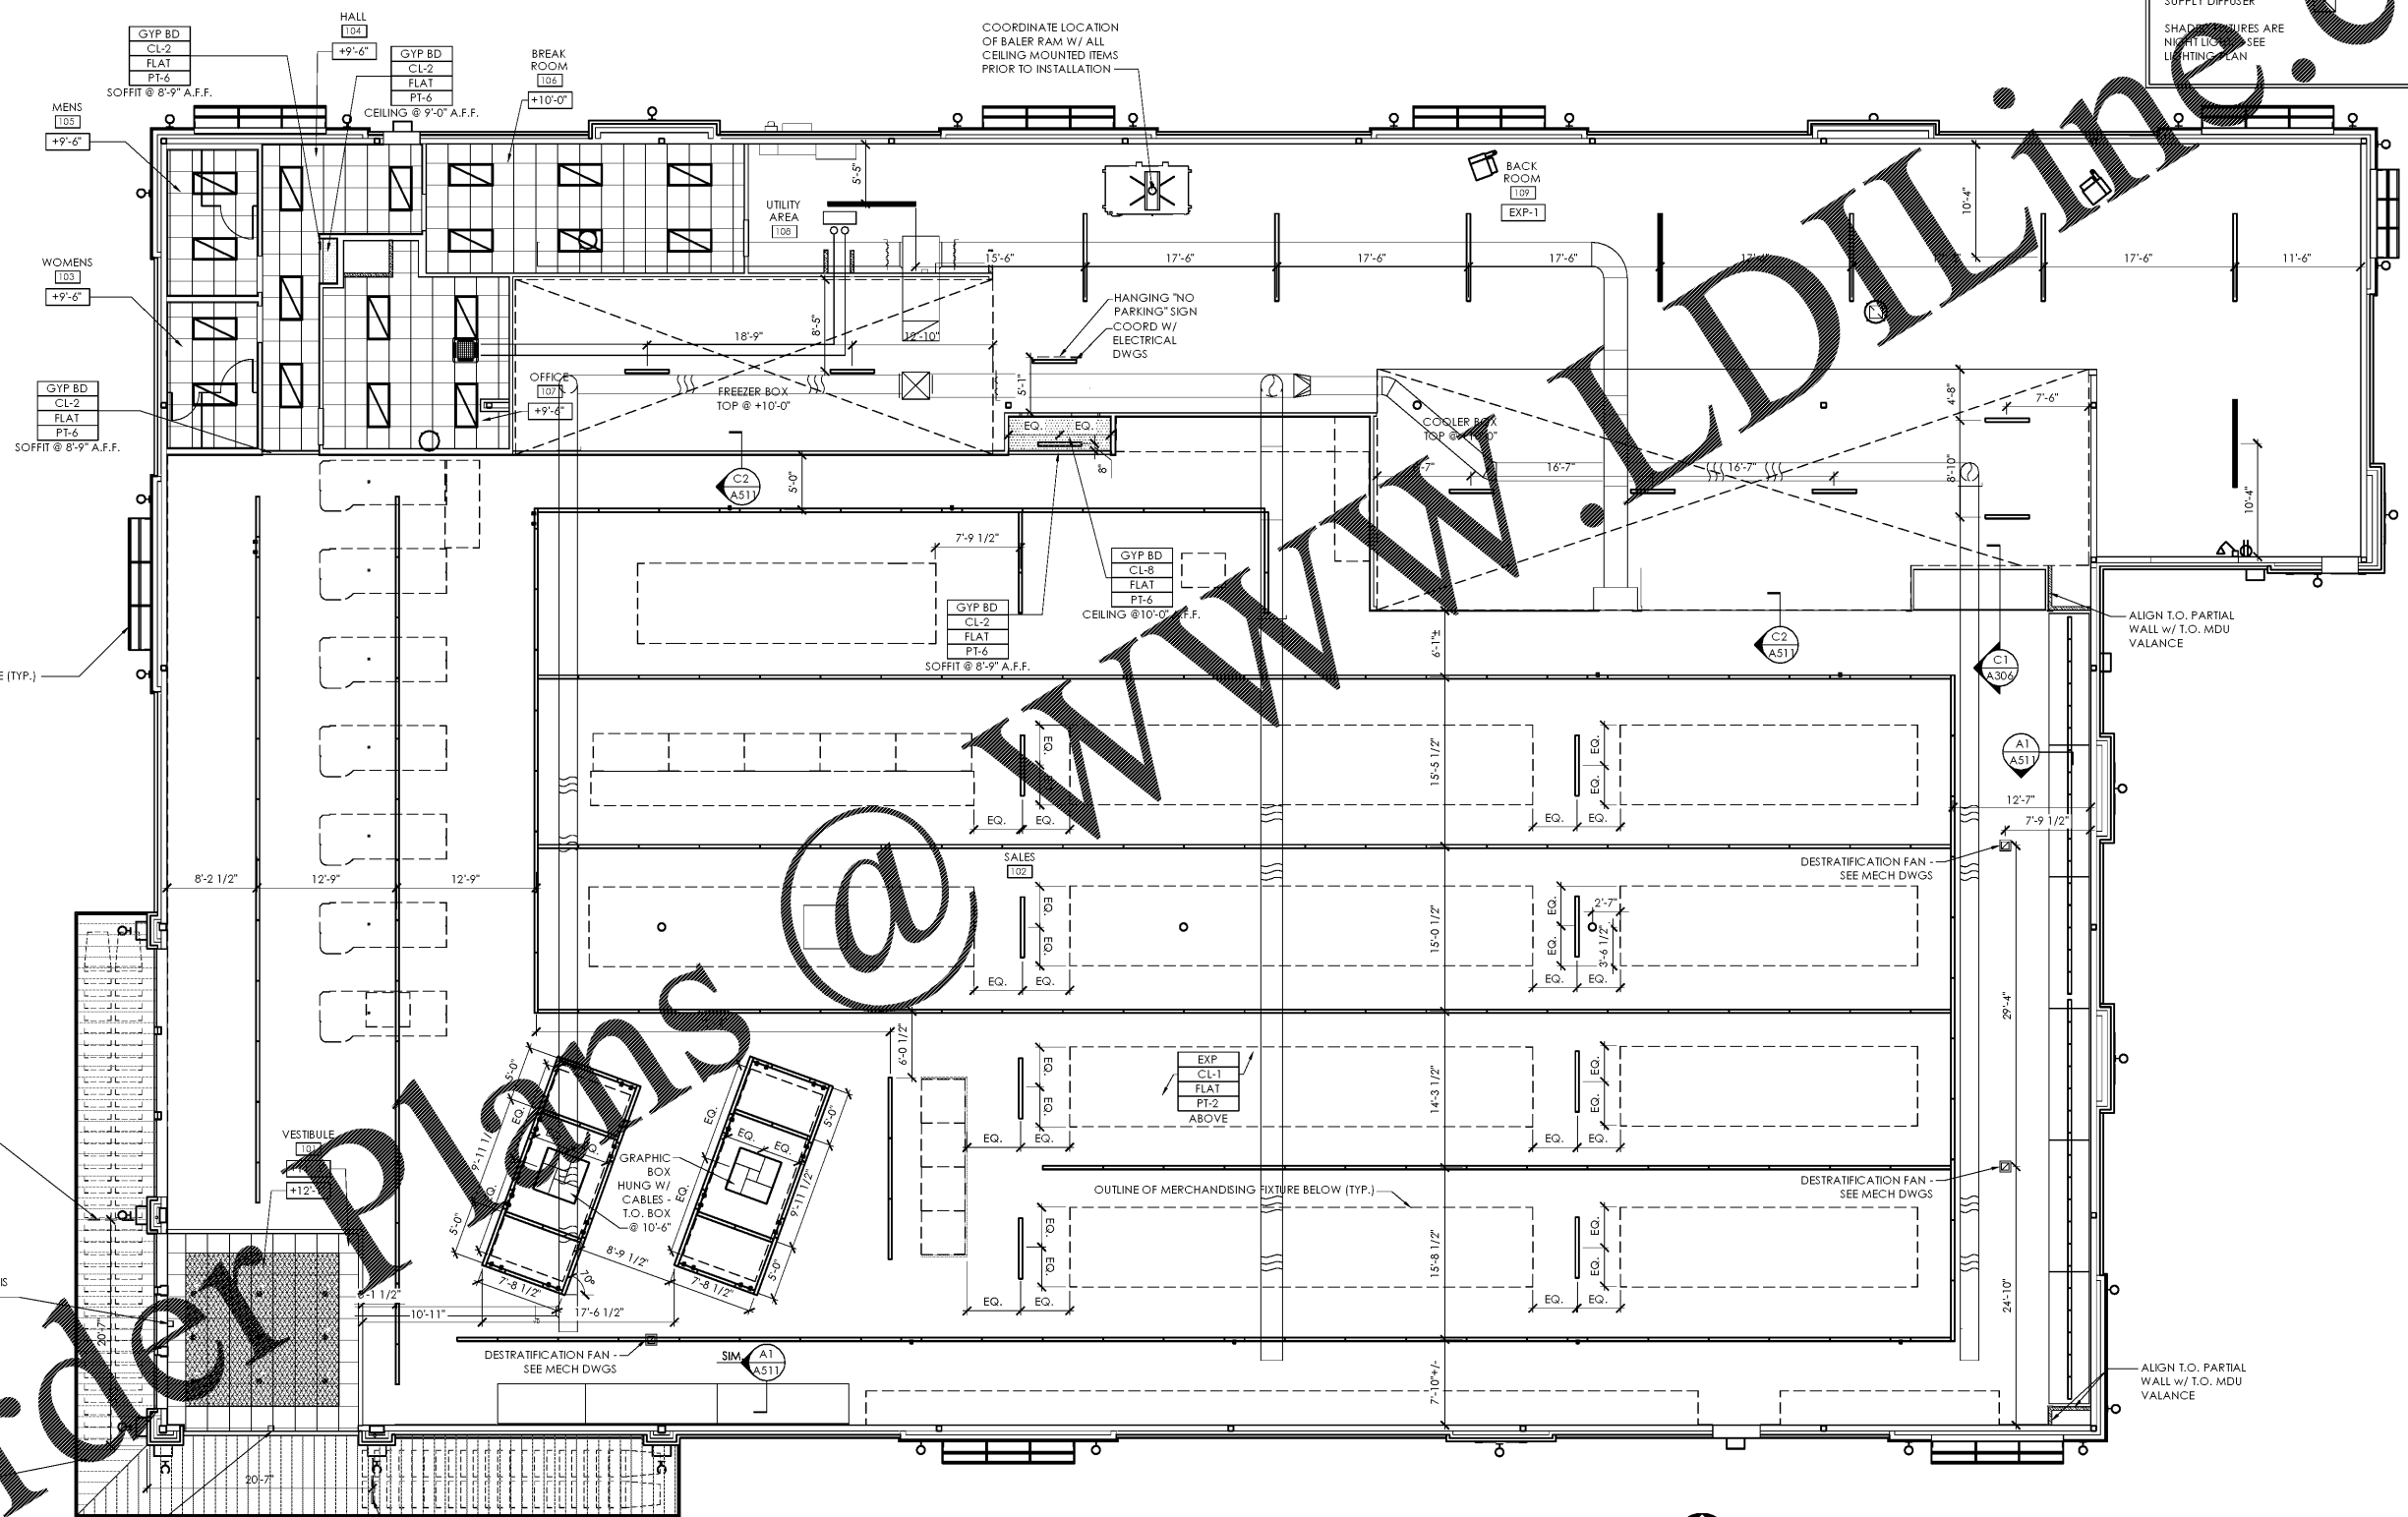

1 Reflected Ceiling Plan
 SCALE: 1/8" = 1'-0"
 PLAN NORTH

PLOTTED: 5/11/2018 11:42 AM

Order Plans

HANGING SIGN - SEE DETAIL D2/A602; CENTER BETWEEN WALL SCIENCE AND EDGE OF CANOPY

J-BOXES ABOVE CEILING FOR 'FOOD MARKET' AND 'ALDI' LOGO SIGNS - SEE ELECTRICAL DWGS; DO NOT INSTALL GYP BD UNTIL SIGNAGE ELECTRICAL ROUGH-IN IS COMPLETE

ALUM SUN SHADE (TYP.) - REFER TO WALL SECTION

J-BOXES ABOVE CEILING FOR 'FOOD MARKET' AND 'ALDI' LOGO SIGNS - SEE ELECTRICAL DWGS; DO NOT INSTALL GYP BD UNTIL SIGNAGE ELECTRICAL ROUGH-IN IS COMPLETE

HANGING SIGN - SEE DETAIL D2/A602; CENTER BETWEEN WALL SCIENCE AND EDGE OF CANOPY