



SEALS
COPYRIGHT BY ROSENBLUM COE ARCHITECTS, INC.
THIS DRAWING HAS BEEN PREPARED BY ROSENBLUM COE ARCHITECTS, INC. FOR THE PROJECT AND IS THE PROPERTY OF ROSENBLUM COE ARCHITECTS, INC. IT IS TO BE USED ONLY FOR THE PROJECT AND SITE SPECIFIC WORK SHOWN THEREON. NO PART OF THIS DOCUMENT MAY BE REPRODUCED OR TRANSMITTED IN ANY FORM OR BY ANY MEANS, ELECTRONIC OR MECHANICAL, INCLUDING PHOTOCOPYING, RECORDING, OR BY ANY INFORMATION STORAGE AND RETRIEVAL SYSTEM, WITHOUT THE WRITTEN PERMISSION OF ROSENBLUM COE ARCHITECTS, INC.

- NOTES
- 1. CONTRACTOR SHALL DEMOLISH SANITARY RISER FOR RELOCATION. SEE NEW WORK PLANS FOR MORE INFORMATION.
 - 2. CONTRACTOR SHALL DEMOLISH VENT PIPING.
 - 3. CONTRACTOR SHALL STORE DEMOLITION FITTINGS FOR RELOCATION. SEE NEW WORK PLANS AND RISER FOR MORE INFORMATION.

GENERAL NOTES
1. REFER TO PD01 FOR GENERAL NOTES.

MUSC
MEDICAL UNIVERSITY
of SOUTH CAROLINA
PROJECT NUMBER: H51-50068
DHEC PROJECT NUMBER: 580145

CONSTRUCTION DOCUMENTS


**STORM EYE INSTITUTE
OPTICAL SHOP
H51-50068**
167 ASHLEY AVE
CHARLESTON, SC 29425

**ROSENBLUM COE
ARCHITECTS,
INC.**
1643 MEANS STREET
CHARLESTON, SC 29412
843.577.6073

**PLUMBING CRAWL SPACE
DEMOLITION PLAN**

SHEET NAME	
PROJECT NUMBER	17016
DRAWN BY	TSN
CHECKED BY	CRB
DATE	05/09/2018
SCALE	1/4" = 1'-0"

PD100

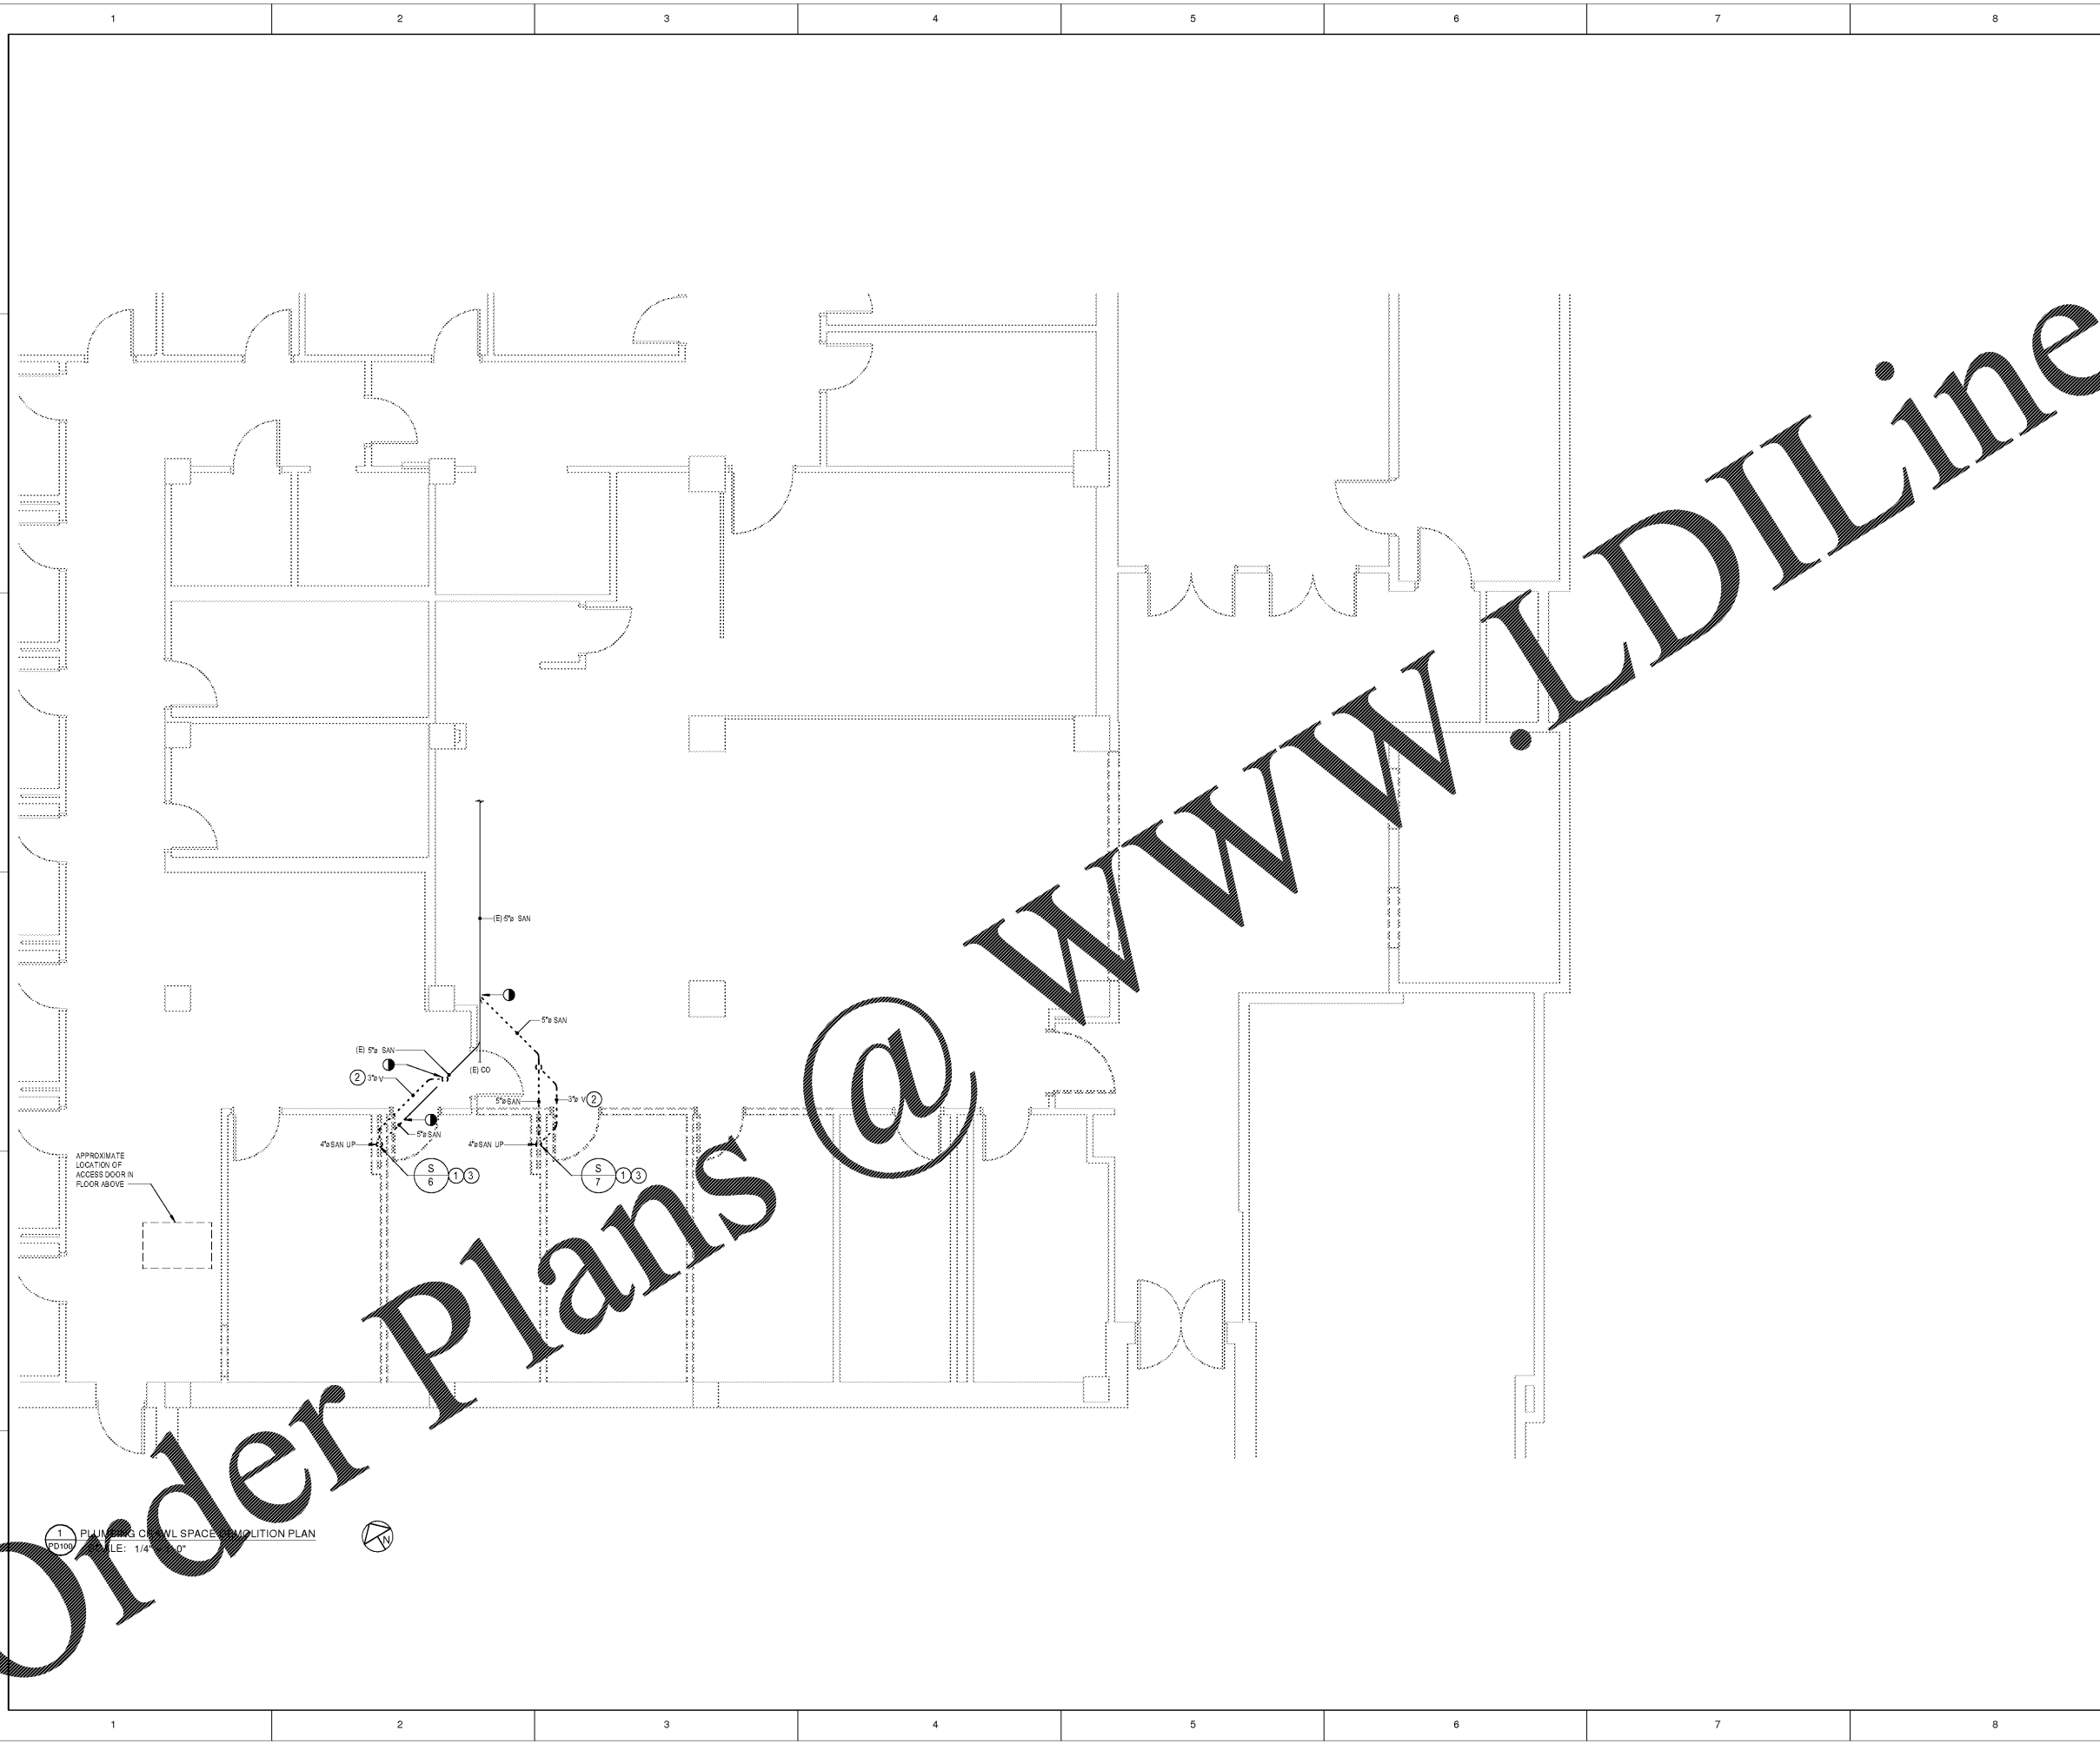

1 PLUMBING CRAWL SPACE DEMOLITION PLAN
SCALE: 1/4" = 1'-0"

Order Plans @ www.LDILine.com