



SEALS  
COPYRIGHT BY ROSENBLUM COE ARCHITECTS, INC.  
THIS DRAWING HAS BEEN PREPARED BY ROSENBLUM COE ARCHITECTS, INC. FOR THE PROJECT AND IS THE PROPERTY OF ROSENBLUM COE ARCHITECTS, INC. IT IS TO BE USED ONLY FOR THE PROJECT AND SITE SPECIFIC WORK SHOWN HEREON. NO PART OF THIS DOCUMENT MAY BE REPRODUCED OR TRANSMITTED IN ANY FORM OR BY ANY MEANS, ELECTRONIC OR MECHANICAL, INCLUDING PHOTOCOPYING, RECORDING, OR BY ANY INFORMATION STORAGE AND RETRIEVAL SYSTEM, WITHOUT THE WRITTEN PERMISSION OF ROSENBLUM COE ARCHITECTS, INC.

- NOTES
- 1. CONTRACTOR SHALL DEMOLISH SANITARY RISER FOR RELOCATION. SEE NEW WORK PLANS FOR MORE INFORMATION.
  - 2. CONTRACTOR SHALL DEMOLISH VENT PIPING.
  - 3. CONTRACTOR SHALL STORE DEMOLITION FITTINGS FOR RELOCATION. SEE NEW WORK PLANS AND RISER FOR MORE INFORMATION.

GENERAL NOTES  
1. REFER TO PD01 FOR GENERAL NOTES.

**MUSC**  
MEDICAL UNIVERSITY  
of SOUTH CAROLINA  
PROJECT NUMBER: H51-50068  
DHEC PROJECT NUMBER: 580145

**CONSTRUCTION DOCUMENTS**


**STORM EYE INSTITUTE  
OPTICAL SHOP  
H51-50068**  
167 ASHLEY AVE  
CHARLESTON, SC 29425

**ROSENBLUM COE  
ARCHITECTS,  
INC.**  
1643 MEANS STREET  
CHARLESTON, SC 29412  
843.577.6073

**PLUMBING CRAWL SPACE  
DEMOLITION PLAN**

SHEET NAME	
PROJECT NUMBER	17016
DRAWN BY	TSN
CHECKED BY	CRB
DATE	05/09/2018
SCALE	1/4" = 1'-0"

**PD100**

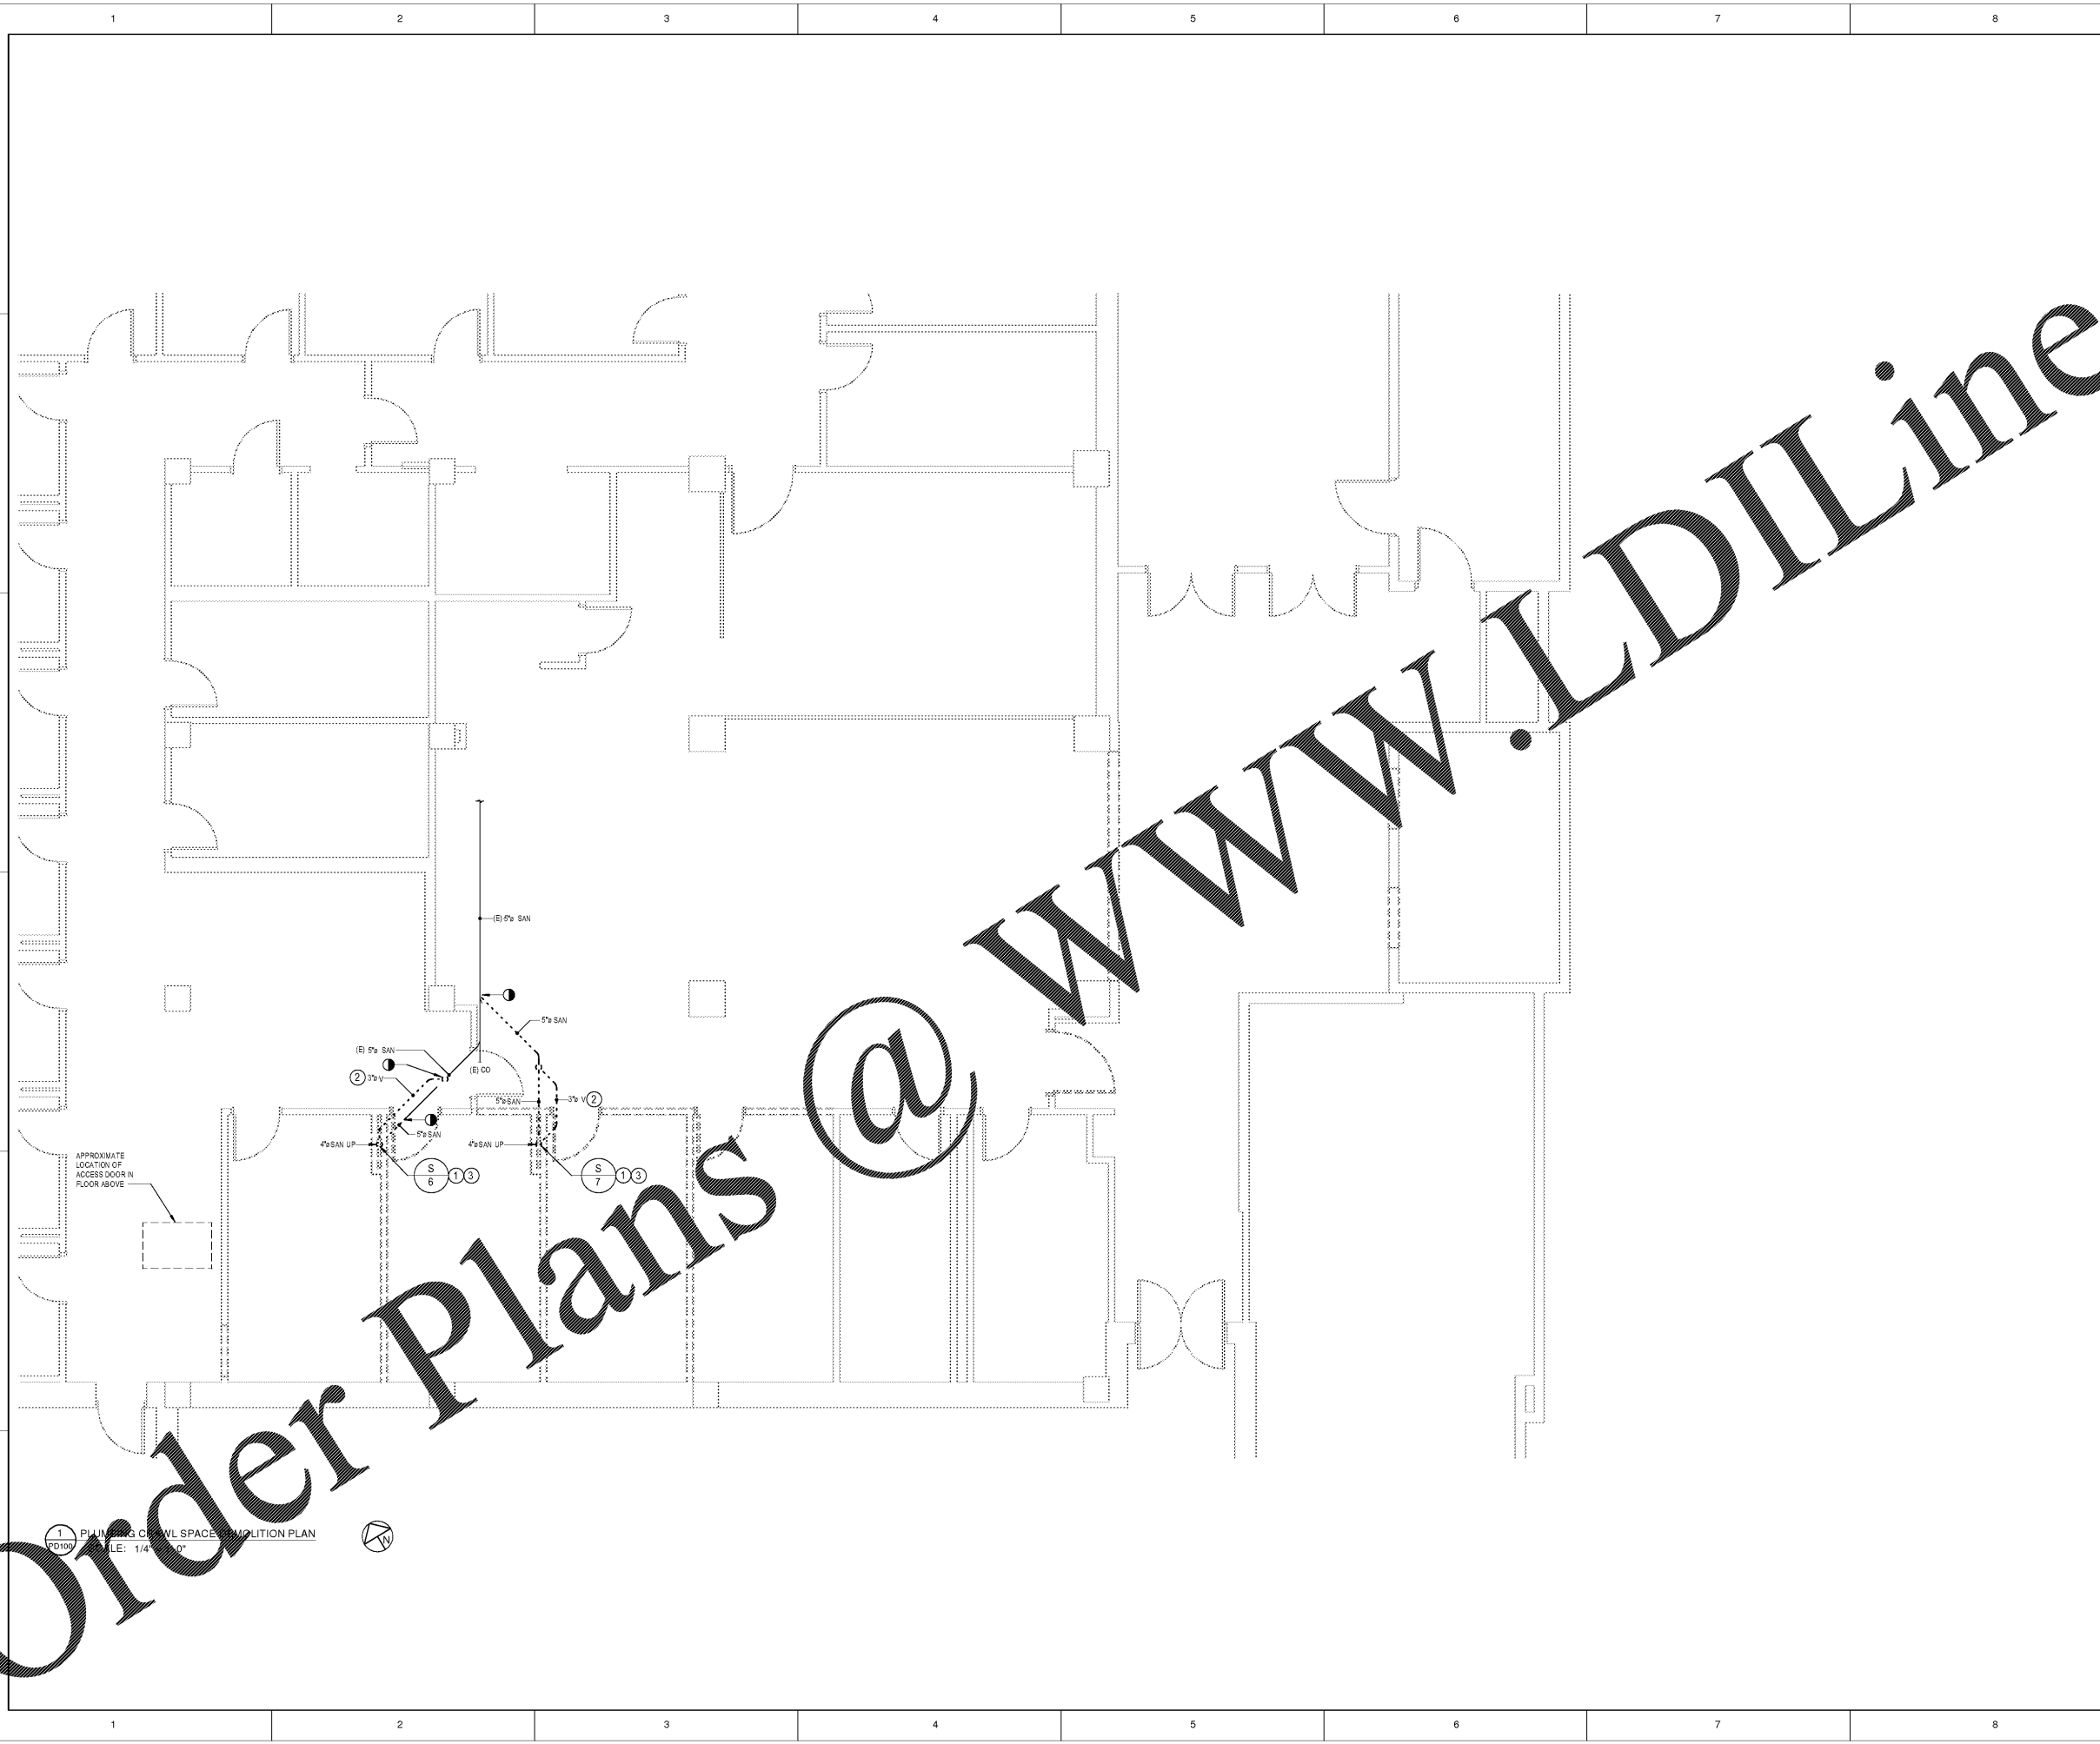

1 PLUMBING CRAWL SPACE DEMOLITION PLAN  
SCALE: 1/4" = 1'-0"

Order Plans @ [www.LDILine.com](http://www.LDILine.com)