




NORTH BIRDSEYE PERSPECTIVE

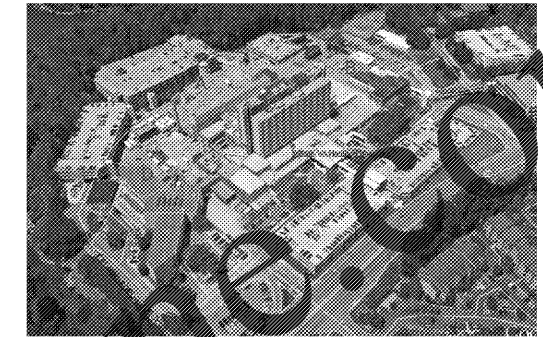

EAST BIRDSEYE PERSPECTIVE

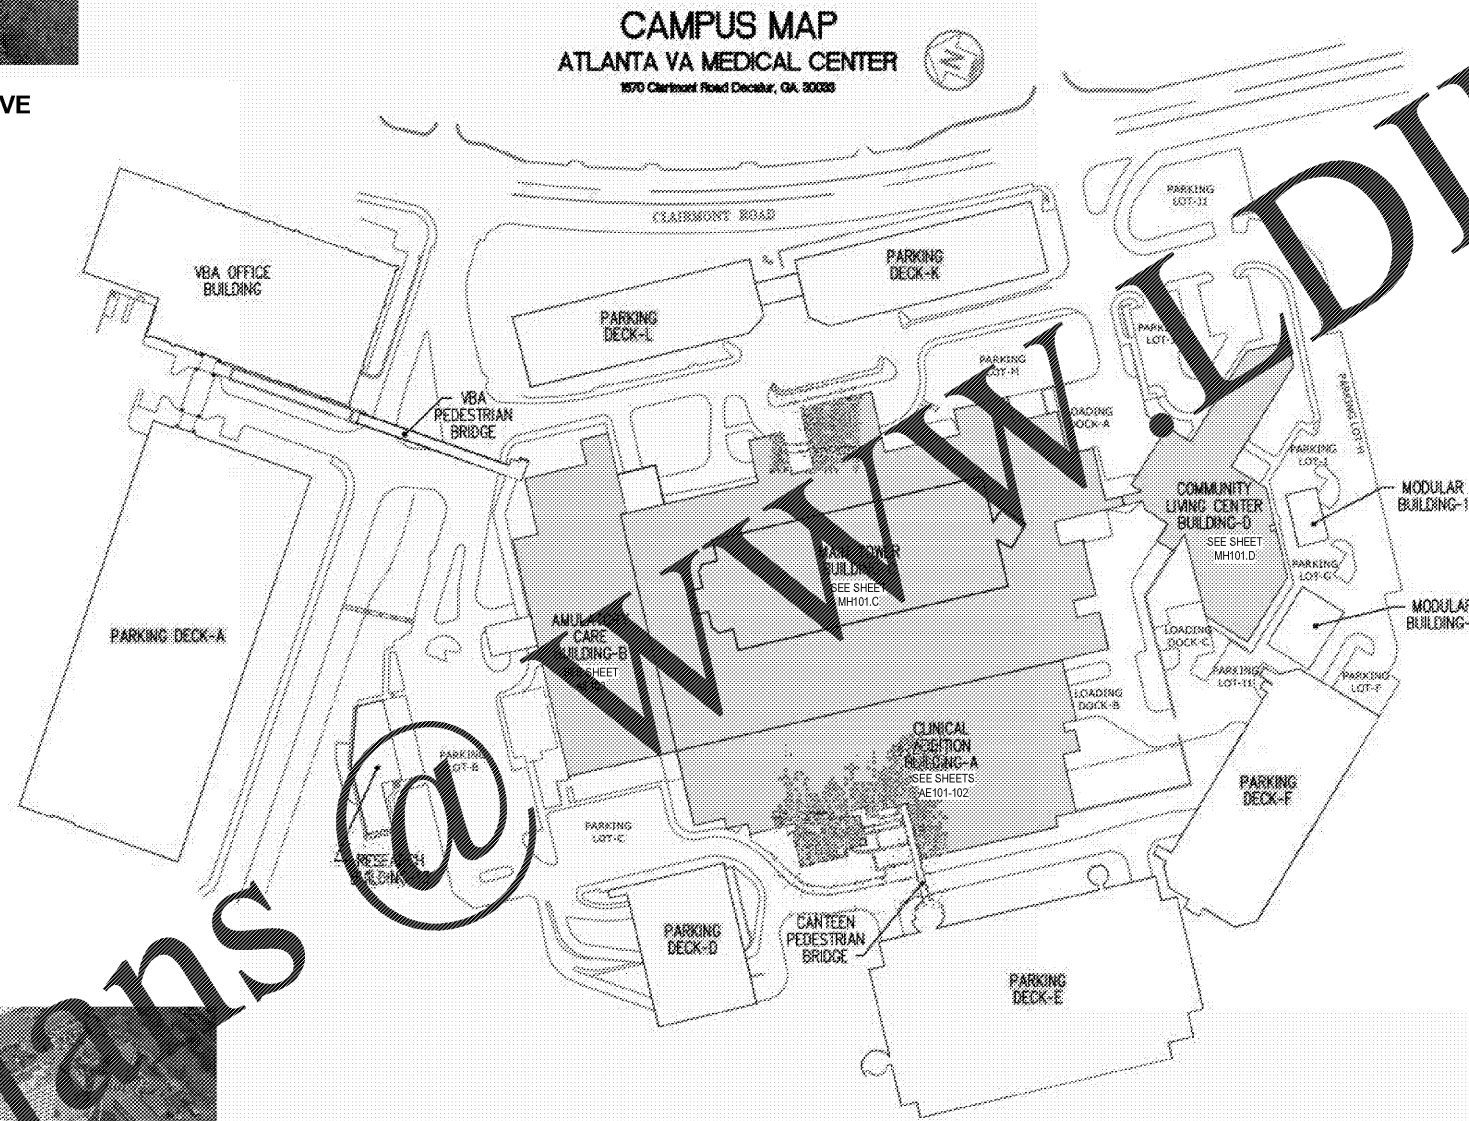

WEST BIRDSEYE PERSPECTIVE

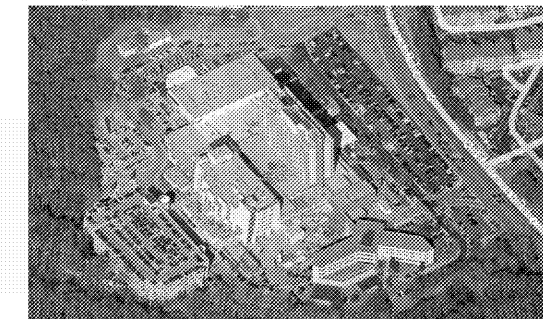

SOUTH BIRDSEYE PERSPECTIVE

Scale bars for various drawing sizes: 1/8" = 1'-0", 1/4" = 1'-0", 1/2" = 1'-0", 3/4" = 1'-0", 1" = 1'-0", 1 1/4" = 1'-0", 1 1/2" = 1'-0", 1 3/4" = 1'-0", 2" = 1'-0", 2 1/4" = 1'-0", 2 1/2" = 1'-0", 2 3/4" = 1'-0", 3" = 1'-0", 3 1/4" = 1'-0", 3 1/2" = 1'-0", 3 3/4" = 1'-0", 4" = 1'-0", 4 1/4" = 1'-0", 4 1/2" = 1'-0", 4 3/4" = 1'-0", 5" = 1'-0", 5 1/4" = 1'-0", 5 1/2" = 1'-0", 5 3/4" = 1'-0", 6" = 1'-0", 6 1/4" = 1'-0", 6 1/2" = 1'-0", 6 3/4" = 1'-0", 7" = 1'-0", 7 1/4" = 1'-0", 7 1/2" = 1'-0", 7 3/4" = 1'-0", 8" = 1'-0", 8 1/4" = 1'-0", 8 1/2" = 1'-0", 8 3/4" = 1'-0", 9" = 1'-0", 9 1/4" = 1'-0", 9 1/2" = 1'-0", 9 3/4" = 1'-0", 10" = 1'-0".

Order Plans

WWW.DILITHIUM.COM

100% CONSTRUCTION DOCUMENT SUBMISSION
FULLY SPRINKLERED

Revisions: Date	CONSULTANTS:		ARCHITECT/ENGINEERS: BES DESIGN/BUILD, LLC 766 Middle St, Fairhope, AL 36532 Phone: 251.990.5778 Fax: 251.990.3716	Drawing Title: ARCHITECTURAL SITE PLAN	Project Title: UPGRADE ELEVATORS BUILDINGS A, B, C, AND D		Project Number: 508-14-123		ATLANTA VA MEDICAL CENTER
					Approved: Project Director		Building Number: A, B, C & D		
Date: 2017.05.01		Drawn: DJH		Checked: RP		Dwg. 4 of 28			