


one eighth inch = one foot  
 one quarter inch = one foot  
 one half inch = one foot  
 three eighths inch = one foot  
 three quarters inch = one foot  
 one inch = one foot  
 one and one eighth inch = one foot  
 one and one quarter inch = one foot  
 one and one half inch = one foot  
 one and three quarters inch = one foot  
 two inches = one foot  
 three inches = one foot  
 four inches = one foot  
 five inches = one foot  
 six inches = one foot  
 seven inches = one foot  
 eight inches = one foot  
 nine inches = one foot  
 ten inches = one foot  
 eleven inches = one foot  
 twelve inches = one foot

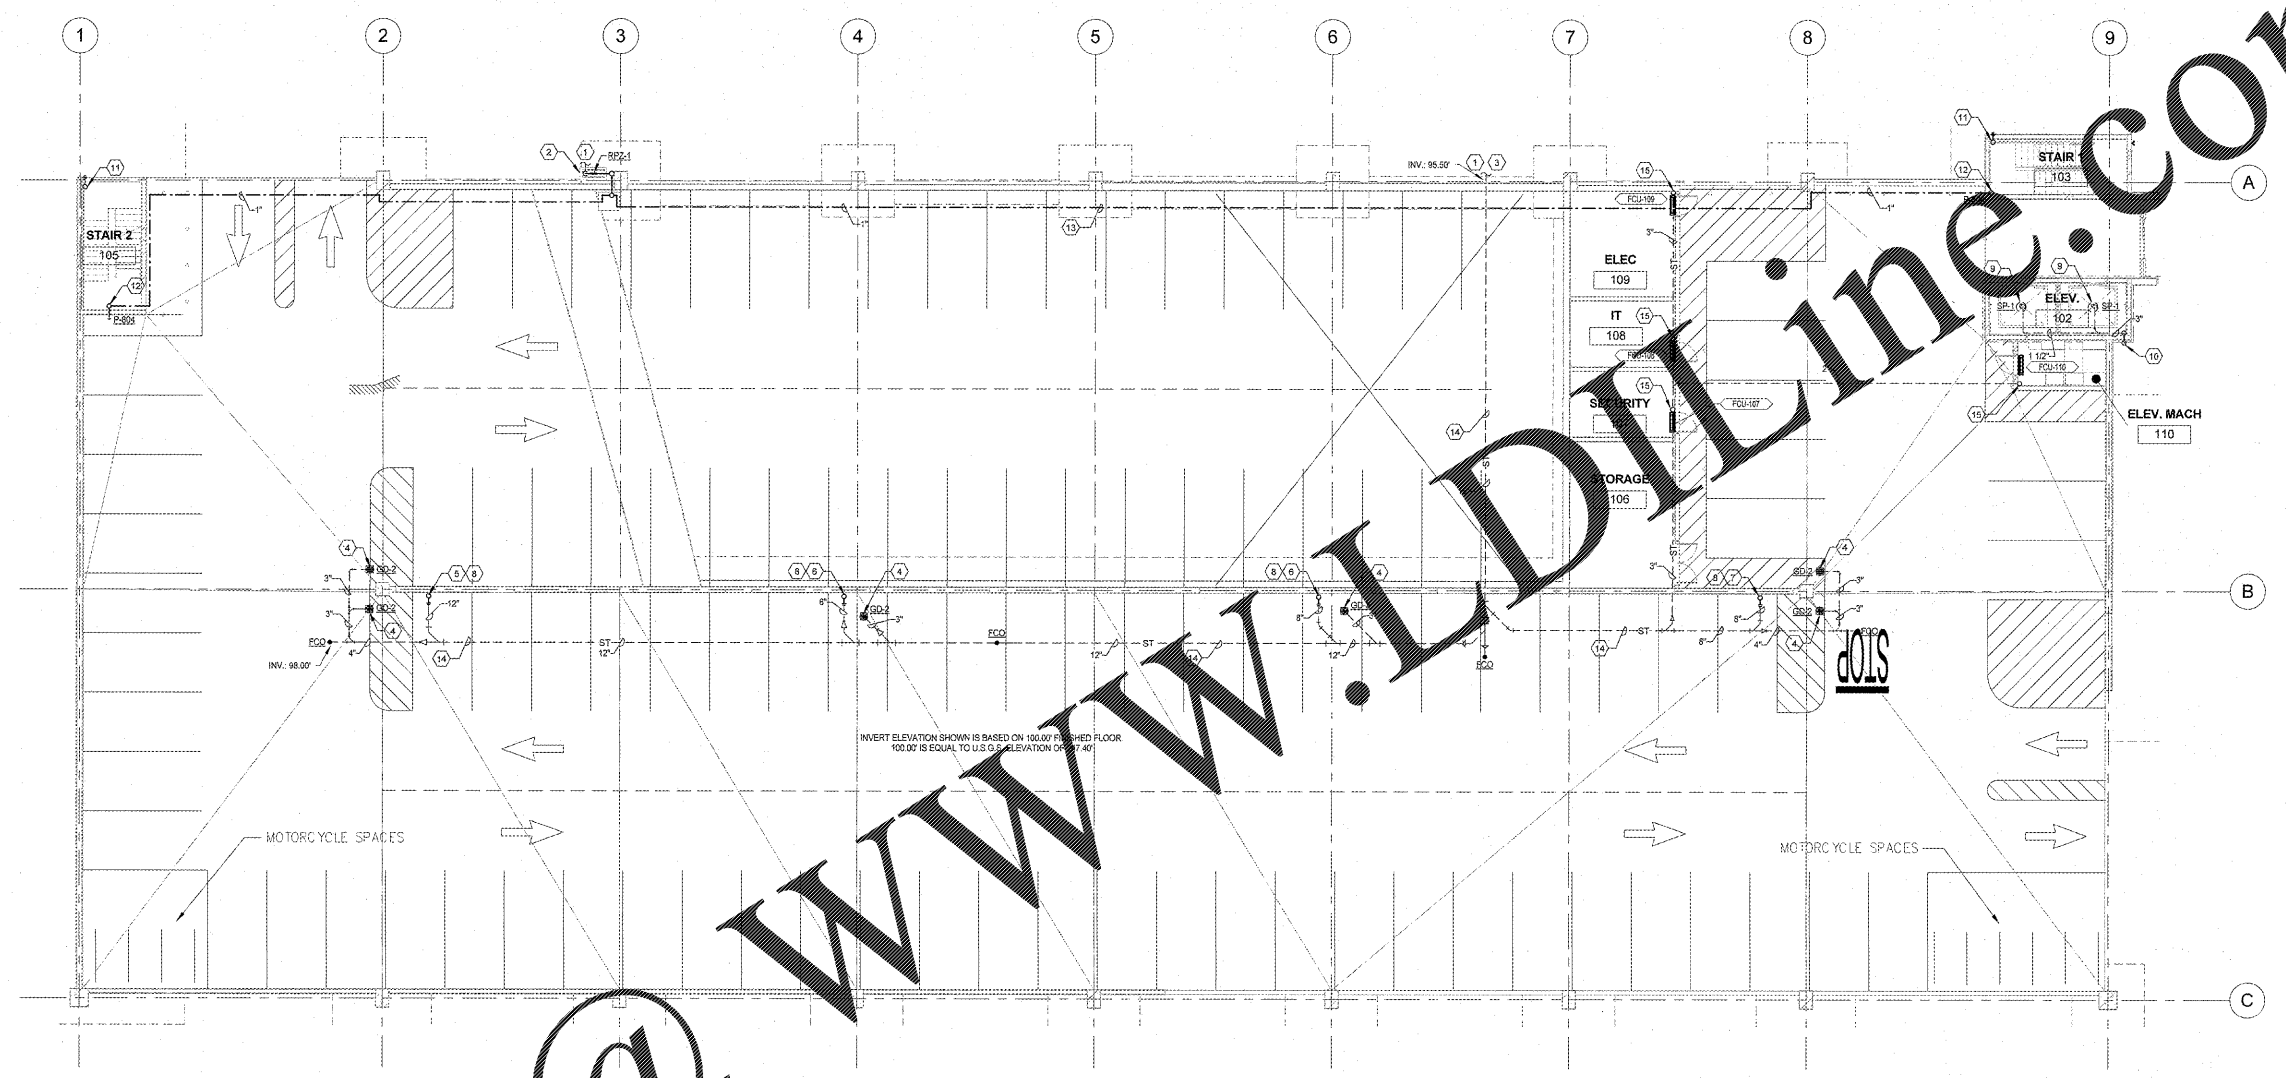

**1 FIRST FLOOR PLUMBING PLAN**  
 PP101 3/32" = 1'-0"

KEY	NOTE	KEY	NOTE
1	SEE CU101 SITE UTILITY PLAN FOR CONTINUATION.	9	SEE 4P1001 SUMP PUMP DETAIL.
2	RPZ IN HOT BOX (80V), SEE 6P1001.	10	3" SUMP PUMP DISCHARGE, ELBOW PIPE DOWN 36" OUTSIDE THE BUILDING. DISCHARGE PIPE TO TERMINATE AT 24" ABOVE FINISHED GRADE. PROVIDE SPLASH BLOCK.
3	INVERT ELEVATION FOR STORM PIPE IS 4.5 FEET BELOW FINISHED FLOOR ELEVATION. COORDINATE WITH CIVIL PRIOR TO INSTALLATION OF STORM PIPING.	11	3" OVERFLOW STORM DRAIN UP TO STAIR TOWER. TERMINATE WITH DOWNSPOUT NOZZLE AND PROVIDE SPLASH BLOCK.
4	CENTER DRAINS ON EDGE OF WASH. COORDINATE FLOOR DRAIN LOCATIONS WITH STRUCTURAL PLANS.	12	1" DOMESTIC COLD WATER UP AND 3/4" DOWN TO P-304 AT 1' AFF. SEE 4P1002 FOR CONTINUATION.
5	12" Ø STORM DRAIN CONDUCTOR UP. TRANSITION TO 12" Ø WHEN TURNING HORIZONTAL UNDER SLAB. PROTECT WITH PIPE GUARD. SEE 7AP1001.	13	INSTALL TIGHT TO BOTTOM OF DOUBLE TEES.
6	6" Ø STORM DRAIN CONDUCTOR UP. PROTECT WITH PIPE GUARD. SEE 7AP1001.	14	PIPE LOCATED UNDER SLAB, TYPICAL.
7	6" Ø STORM DRAIN CONDUCTOR UP. TRANSITION TO 8" Ø WHEN TURNING HORIZONTAL UNDER SLAB. PROTECT WITH PIPE GUARD. SEE 7AP1001.	15	CONDENSATE DRAIN STANDPIPE. SEE DETAIL 8P1001.
8	PROVIDE CLEANOUT AT THE BASE OF THE RISER. COORDINATE WITH PIPE GUARD. SEE 7AP1001.		

Order Plans @ WWW.LDOnline.com

Revisions	Date

MEMPHIS VAMC  
 1030 JEFFERSON AVE, MEMPHIS, TN 38104

**ARCHITECT/ENGINEERS:**

**PROJECT LEAD**  
 Architect, Structural Engineer, Civil Engineer  
**GUIDON DESIGN**

905 N. CAPITOL AVE. SUITE 100, INDIANAPOLIS, IN 46204  
 317.800.8368 WWW.GUIDONDESIGN.COM  
 SUSTAINABLE ARCHITECTURE + ENGINEERING

**MEP Engineer**  
 APOGEE CONSULTING GROUP  
 1151 Kildaire Farm Rd. Suite 120 Cary, NC 27511  
 Tele: 919-858-7420

**Functional Design**  
 CARL WALKER INC.  
 3211 Internet Blvd., Suite 220 Frisco, TX 75034  
 Tele: 469-777-5143

BID SET			
Drawing Title <b>FIRST FLOOR PLUMBING PLAN</b>	Project Title <b>CONSTRUCT PARKING GARAGE ON WEST LOT</b>	Project Number <b>15.1067</b>	OFFICE OF FACILITIES MANAGEMENT
Approved for Design Concept: <b>FACILITY MANAGEMENT DIVISION MANAGER</b>	Location <b>MEMPHIS, TN</b>	Building Number <b>614-319</b>	
Date <b>11/14/2016</b>	Checked By: <b>DJR</b>	Drawn By: <b>ORD</b>	VA Project Number <b>614-319</b>
Drawing Number <b>PP101</b>			VA U.S. Department of Veterans Affairs