


one eighth inch = one foot
 one quarter inch = one foot
 three eighths inch = one foot
 one half inch = one foot
 three quarters inch = one foot
 one inch = one foot
 one and one half inches = one foot
 two inches = one foot
 three inches = one foot
 four inches = one foot
 five inches = one foot
 six inches = one foot
 seven inches = one foot
 eight inches = one foot
 nine inches = one foot
 ten inches = one foot
 eleven inches = one foot
 twelve inches = one foot

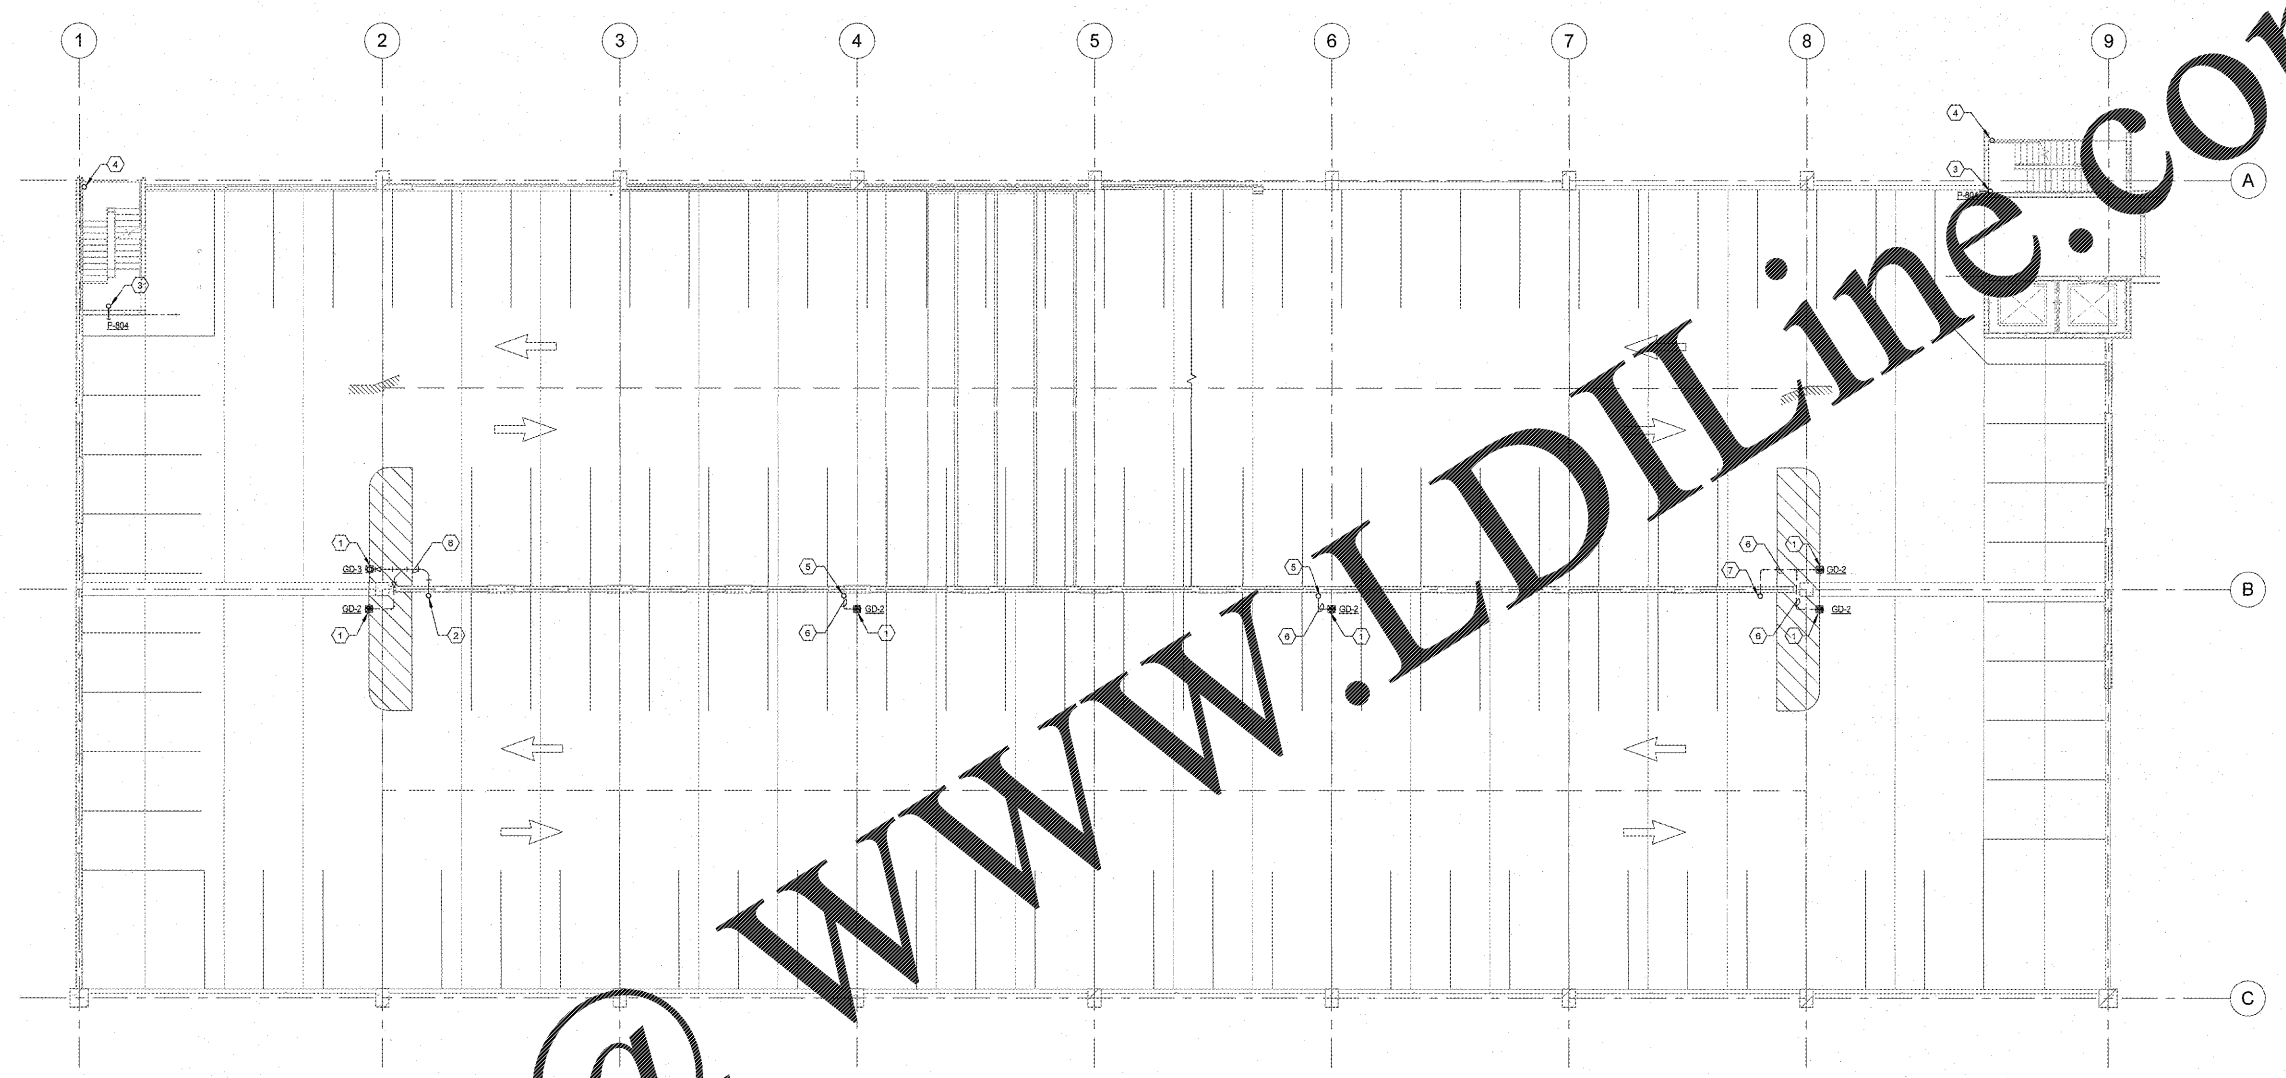

1 SECOND FLOOR PLUMBING PLAN
 PP102 3/32" = 1'-0"

KEY	NOTE
1	CENTER DRAINS ON EDGE OF WASH. COORDINATE FLOOR DRAIN LOCATIONS WITH STRUCTURAL PLANS.
2	8" Ø STORM DRAIN CONDUCTOR UP AND 10" Ø DOWN. SEE 1PP103 AND 1PP101 FOR CONTINUATION. PROTECT WITH PIPE GUARD. SEE 7AP501.
3	3/4" DOMESTIC COLD WATER UP AND 1" DOWN. SEE 1PP103 AND 1PP101 FOR CONTINUATION.
4	3" Ø OVERFLOW STORM DRAIN CONDUCTOR UP AND DOWN. SEE 1PP103 AND 1PP101 FOR CONTINUATION.
5	8" Ø STORM DRAIN CONDUCTOR UP AND DOWN. SEE 1PP103 AND 1PP101 FOR CONTINUATION. PROTECT WITH PIPE GUARD. SEE 7AP501.
6	PIPE LOCATED OVERHEAD ON 1ST LEVEL. SHOWN ON THIS PLAN TO CLARIFY ROUTING.
7	8" Ø STORM DRAIN CONDUCTOR UP AND DOWN. SEE 1PP103 AND 1PP101 FOR CONTINUATION. PROTECT WITH PIPE GUARD. SEE 7AP501.

Order Plans @

WWW.LDILine.com

Revisions:	Date

VA U.S. Department of Veterans Affairs
 MEMPHIS VAMC
 1030 JEFFERSON AVE, MEMPHIS, TN 38104



ARCHITECT/ENGINEERS:
PROJECT LEAD
 Architect, Structural Engineer, Civil Engineer
GUIDON DESIGN
 955 N. CAPITOL AVE. SUITE 100 INDIANAPOLIS, IN 46204
 317.600.0388 WWW.GUIDONDESIGN.COM
 SUSTAINABLE ARCHITECTURE + ENGINEERING

MEP Engineer
 APOGEE CONSULTING GROUP
 1151 Kildaire Farm Rd. Suite 120 Cary, NC 27511
 Tele: 919-858-7420

Functional Design
 CARL WALKER INC.
 3211 Internet Blvd., Suite 220 Frisco, TX 75034
 Tele: 469-777-5143

BID SET			
Drawing Title SECOND FLOOR PLUMBING PLAN	Project Title CONSTRUCT PARKING GARAGE ON WEST LOT	Project Number 15.1067	OFFICE OF FACILITIES MANAGEMENT
Approved for Design Concept: FACILITY MANAGEMENT DIVISION MANAGER	Location MEMPHIS, TN	Building Number	VA Project Number 614-319
Date 11/14/2016	Checked By DJR	Drawing Number PP102	U.S. Department of Veterans Affairs
	Drawn By ORD		