




one eighth inch = one foot
 one quarter inch = one foot
 one half inch = one foot
 three eighths inch = one foot
 one half inch = one foot
 three quarters inch = one foot
 one inch = one foot
 one and one half inches = one foot
 two inches = one foot
 three inches = one foot

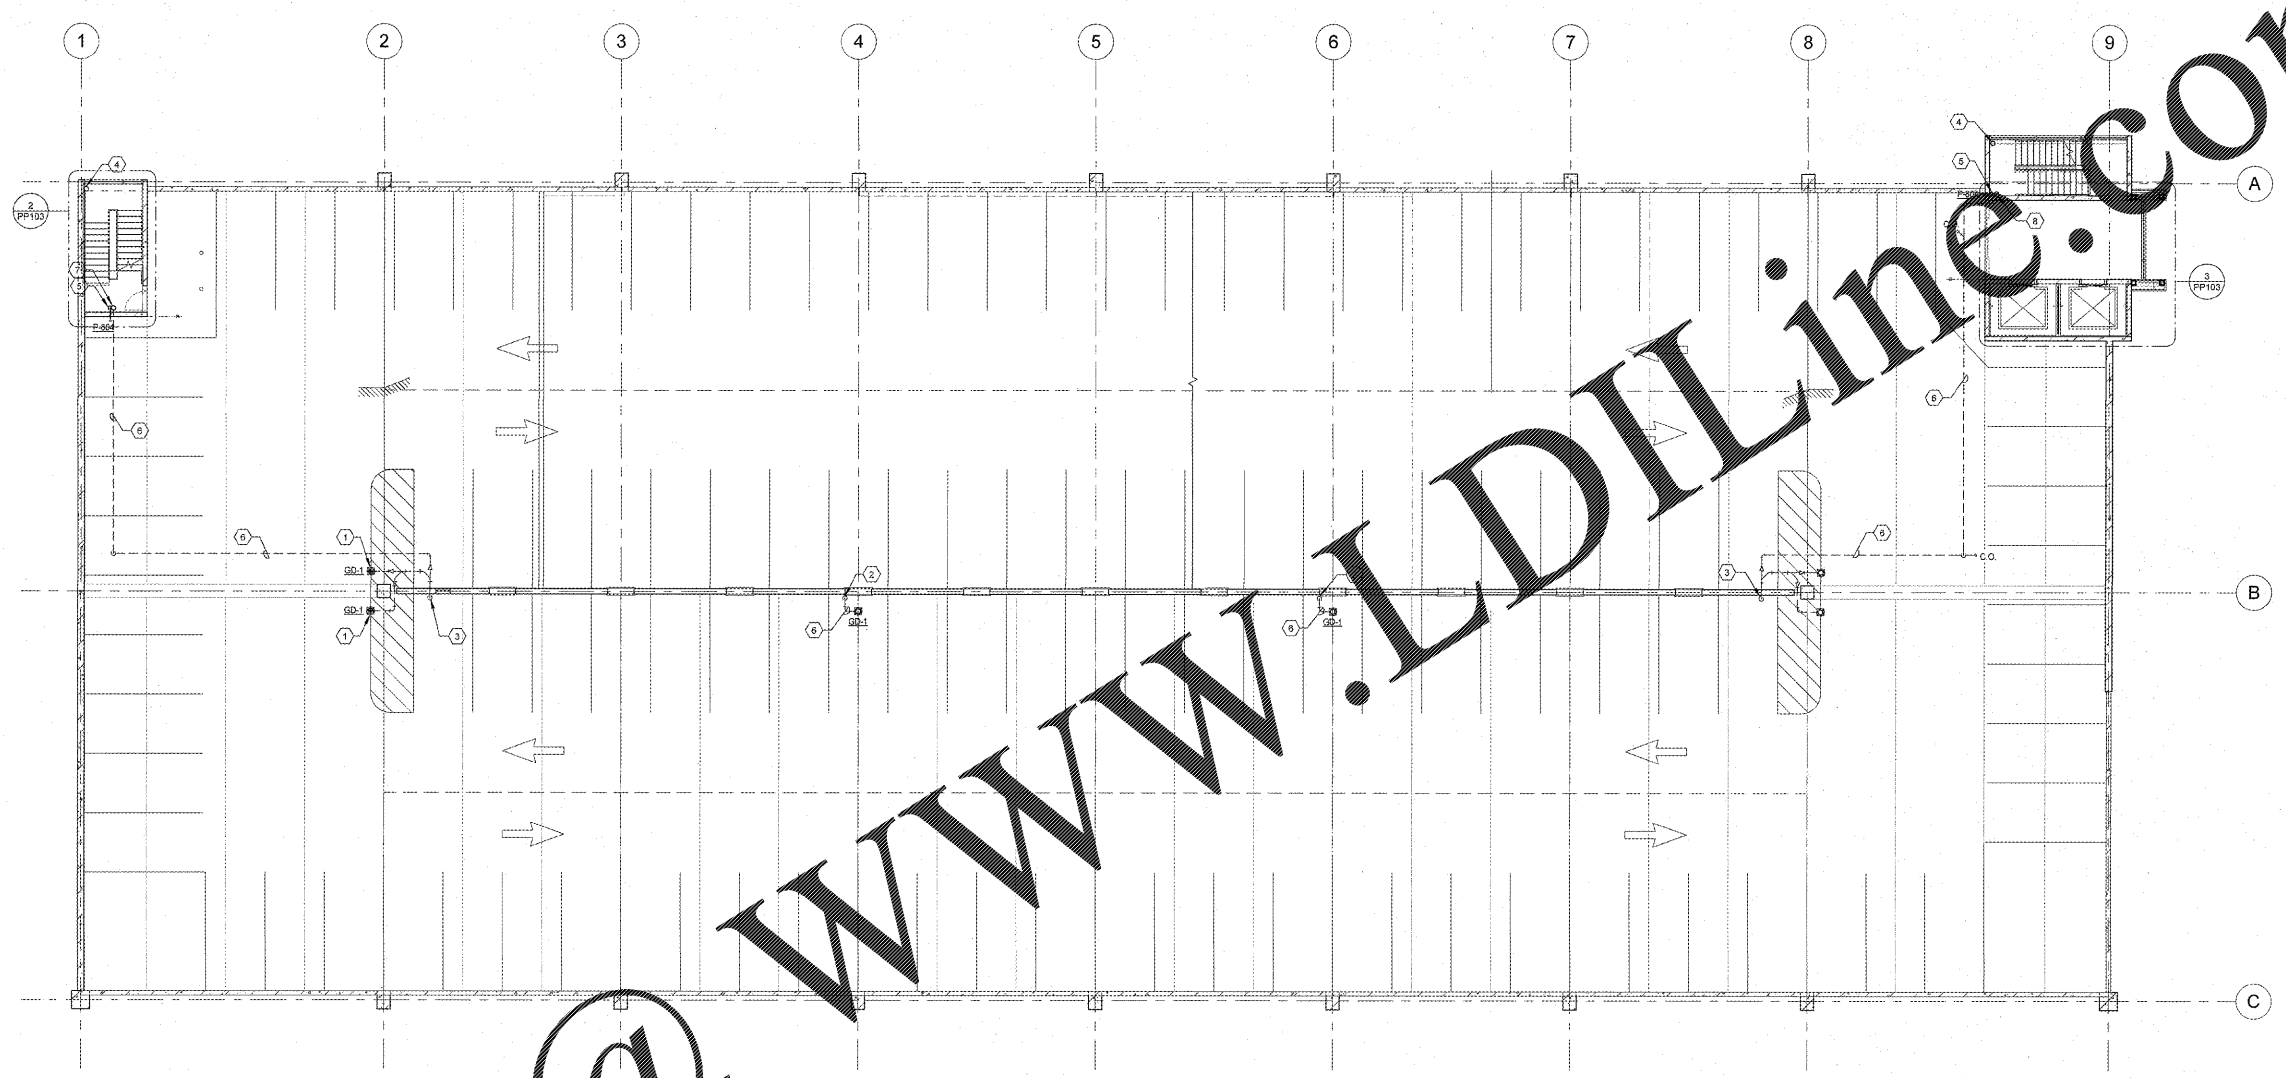

1 THIRD FLOOR PLUMBING PLAN
 PP103 3/32" = 1'-0"

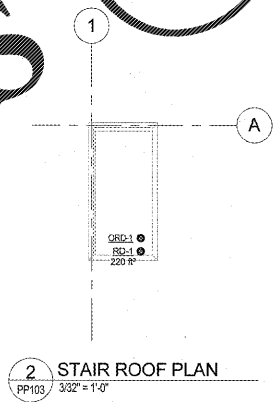

2 STAIR ROOF PLAN
 PP103 3/32" = 1'-0"

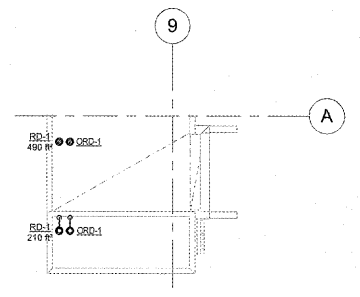

3 ELEV./STAIR 1 PARTIAL ROOF PLAN
 PP103 3/32" = 1'-0"

- | KEY | NOTE |
|-----|--|
| 1 | CENTER DRAINS ON EDGE OF WASH. COORDINATE FLOOR DRAIN LOCATIONS WITH STRUCTURAL PLANS. |
| 2 | 1" Ø STORM DRAIN CONDUCTOR UP AND DOWN. SEE 1PP104 AND 1PP102 FOR CONTINUATION. PROTECT WITH PIPE GUARD. SEE 7AP501. |
| 3 | 1" Ø STORM DRAIN CONDUCTOR DOWN. SEE 1PP102 FOR CONTINUATION. PROTECT WITH PIPE GUARD. SEE 7AP501. |
| 4 | 3" Ø OVERFLOW STORM DRAIN CONDUCTOR UP AND DOWN. SEE 1PP104 AND 1PP102 FOR CONTINUATION. |
| 5 | 3/4" COLD WATER DOWN. SEE 1PP102 FOR CONTINUATION. |
| 6 | PIPE LOCATED OVERHEAD ON 2ND LEVEL. SHOWN ON THIS PLAN TO CLARIFY ROUTING. |
| 7 | 1" Ø STORM DRAIN CONDUCTOR UP TO STAIR TOWER ROOF. |
| 8 | 1" Ø STORM DRAIN CONDUCTOR UP TO ELEVATOR STAIR TOWER ROOF. |

Order Plans @

Revisions:	Date

VA U.S. Department of Veterans Affairs
 MEMPHIS VAMC
 1030 JEFFERSON AVE, MEMPHIS, TN 38104

ARCHITECT/ENGINEERS:
 PROJECT LEAD
 Architect, Structural Engineer, Civil Engineer
GUIDON DESIGN
 905 N. CAPITOL AVE. SUITE 100 INDIANAPOLIS, IN 46204
 317.800.8388 WWW.GUIDONDESIGN.COM
 SUSTAINABLE ARCHITECTURE + ENGINEERING

MEP Engineer
 APOGEE CONSULTING GROUP
 1151 Kildaire Farm Rd. Suite 120 Cary, NC 27511
 Tele: 919-858-7420

Functional Design
 CARL WALKER INC.
 3211 Internet Blvd., Suite 220 Frisco, TX 75034
 Tele: 469-777-5143

BID SET			
Drawing Title THIRD FLOOR PLUMBING PLAN	Project Title CONSTRUCT PARKING GARAGE ON WEST LOT	Project Number 15.1067	OFFICE OF FACILITIES MANAGEMENT
Approved for Design Concept: FACILITY MANAGEMENT DIVISION MANAGER	Location MEMPHIS, TN	Building Number	VA Project Number 614-319
Date 11/14/2016	Checked By DJR	Drawn By ORD	Drawing Number PP103
		VA U.S. Department of Veterans Affairs	