

GENERAL SHEET NOTES

- A. SEE SHEET AE601 FOR WINDOW TYPES.
- B. SEE SHEET C8/AE201 FOR EXTERIOR WINDOW TYPES.
- C. DIMENSIONS SHOWN ARE FROM FINISHED FACE OF WALL AND WALL DEPTHS ARE NOMINAL. SEE SHEET G105 FOR SPECIFIC WALL TYPES USED AND ACTUAL WALL DEPTHS.

SHEET KEYNOTES

- 1. FLOOR EXPANSION JOINT; SEE D6/AE502 DETAIL
- 2. WALL EXPANSION JOINT; SEE D8/AE502 DETAIL
- 3. GFRG COLUMN COVERING; SEE E1/AE502 DETAIL
- 4. WALL INFILL
- 5. FLOOR DRAIN FOR ICE MACHINE; SEE PLUMBING FOR FINAL LOCATION.
- 6. PREPARE EXISTING INTERIOR FINISH WALL TO RECEIVE NEW LAMINATED DRYWALL OR CEMENT BOARD.
- 7. PROVIDE 8"x8" STAINLESS STEEL WALL ACCESS PANEL AT 3'-6" A.F.F. FOR WATER VALVE TURN OFF FUNCTION. ACCESS PANEL TO BE PSYCHIATRIC FACILITY GRADE.



COORDINATION DRAWINGS

SEE COVER SHEET FOR COORDINATION NOTES.
 C=EXISTING CLEAR GLAZING
 S=EXISTING SPANDREL GLAZING
 SEE 08.00.00 SPEC FOR REPLACEMENT GLAZING SYSTEM

SYMBOLS LEGEND

- EXISTING WALL, DOOR, WINDOW, MILLWORK, FIXTURE OR OTHER FIXTURE OR ASSEMBLY TO BE REMOVED.
- EXISTING WALL, DOOR, WINDOW, MILLWORK, FIXTURE OR ASSEMBLY TO REMAIN.
- NEW WALL
- SMOKE TIGHT WALL
- 2-HOUR FIRE/ SMOKE RATED WALL
- 1 HOUR FIRE RATED WALL
- 1 HOUR SMOKE BARRIER WALL
- PROJECT LIMITS OF WORK
- NO PIPING OR DUCTWORK SHALL BE ROUTED THROUGH ELECTRICAL AND/OR DATA ROOMS.
- EXISTING CONCRETE COLUMN


KEY PLAN

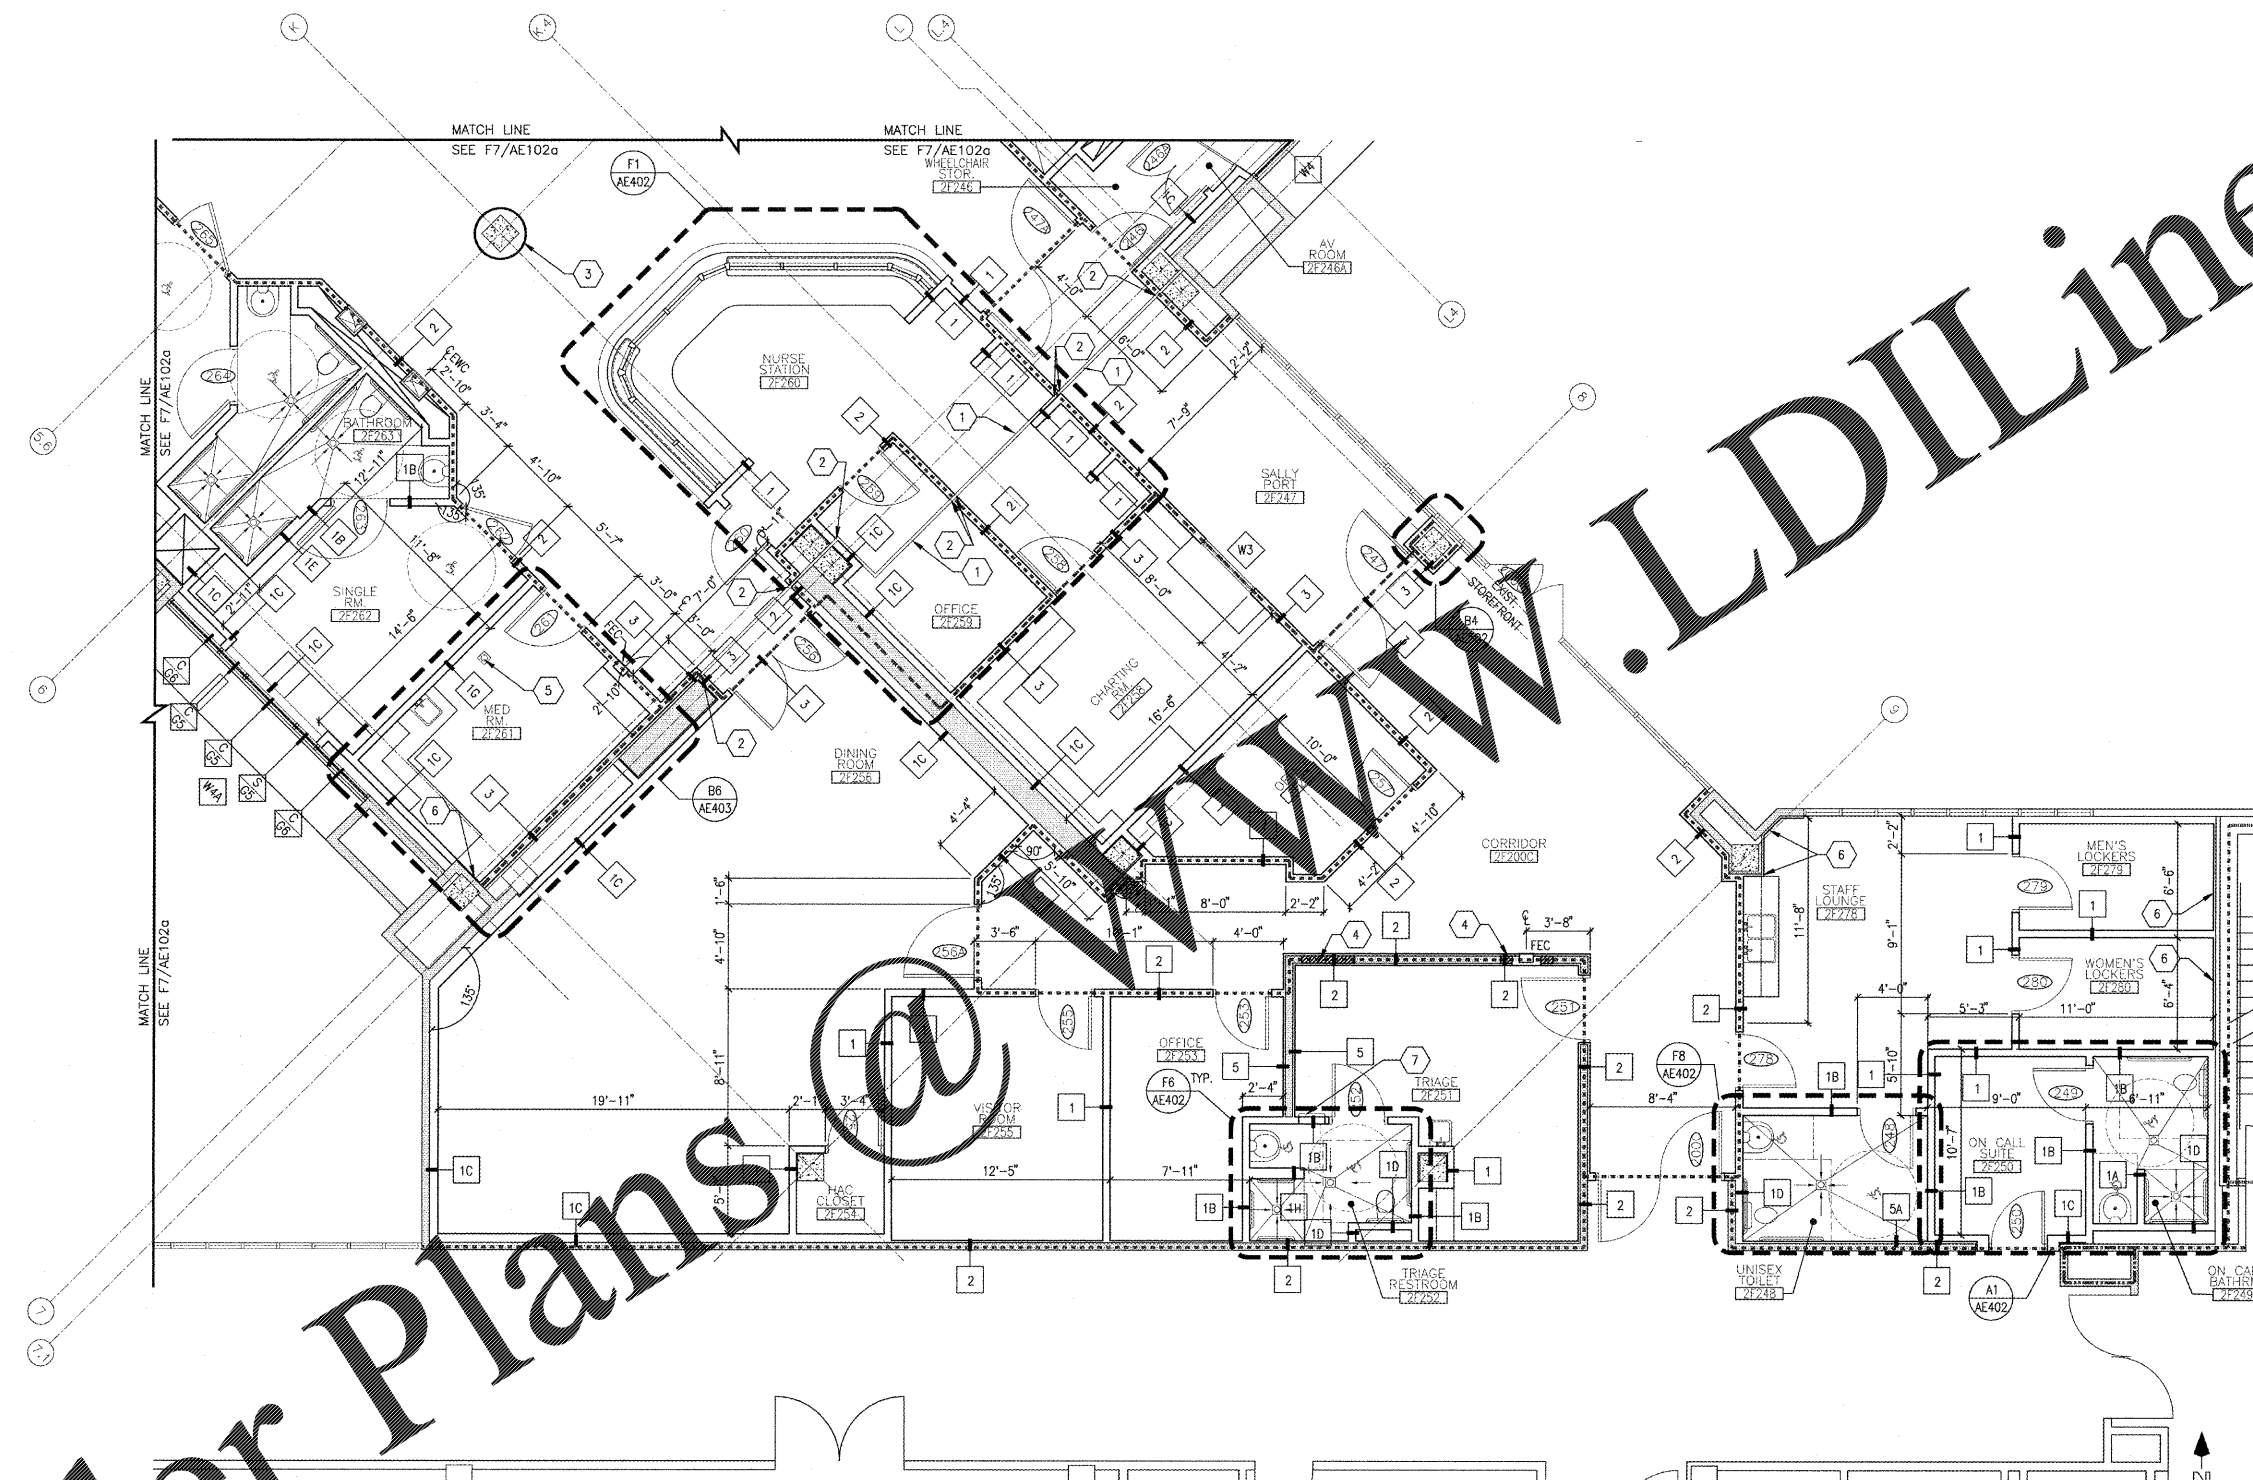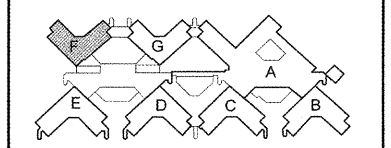

"F" WING SECOND FLOOR PARTIAL ARCHITECTURAL DIMENSION FLOOR PLAN
 SCALE: 1/4" = 1'-0"

REVISION	DESCRIPTION

Department of Veterans Affairs
 Charlie Norwood
 VA Medical Center
 1 Freedom Way
 Augusta, Ga. 30904

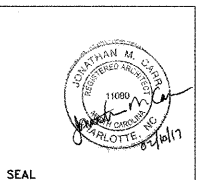

Architect/Engineer Address
Harrell, Saltrick & Hopper
 Design & Management Solutions for the Built Environment
 805 TOWER POINT DRIVE, CHARLOTTE, NC 28227
 WWW.HSH.COM
 P 704.814.1330 F 704.321.0633
 COPYRIGHT © 2012 HARRELL, SALTRICK & HOPPER, PC
 HWY PROJECT # 12015

Recommended Approvals:	
1. MEDICAL CENTER DIRECTOR	6. OPERATIONS SERVICE LINE MANAGER
2. ASSISTANT DIRECTOR	7. INFECTION CONTROL MANAGER
3. CHIEF OF STAFF	8. SAFETY MANAGER
4. ASSOC. DIRECTOR	9. GENERAL ENGINEER
5. SERVICE LINE MGRS.	10. COR

Drawing Title "F" WING PARTIAL ARCHITECTURAL DIMENSION FLOOR PLAN
100% CONSTRUCTION DOCUMENTS
FULLY SPRINKLERED

Project Title RENOVATE MENTAL HEALTH UNITS	Date February 10, 2017
Drawn BWS III	Project Number 509-12-104
Checked	DRAWING No. AE102c
Reviewed	Const. Contract No.

Veterans Affairs