


GENERAL SHEET NOTES

- A. REFER TO FINISH SCHEDULE FOR FINISH MATERIAL COLOR, SIZE AND LOCATION.
- B. REFER TO EQUIPMENT SCHEDULE SHEETS FOR ADDITIONAL EQUIPMENT INFORMATION.

SHEET KEYNOTES

- 1. REFER TO RCP PLAN FOR HEIGHT
- 2. RESIN PANEL WITH ALUM. FRAME-REFER TO FIN. SCHEDULE
- 3. BUILT-IN CASEWORK
- 4. BED (FLOOR MOUNTED)
- 5. NURSE CALL BUTTON
- 6. OPEN SHELVING WARDROBE
- 7. LIGHT FIXTURE-REFER TO RCP PLANS & ELEC. DRAWINGS
- 8. WALL TRIM PAINTED WITH P-1
- 9. WALL BASE-REFER TO FINISH SCHEDULE
- 10. WALL PAINTED-REFER TO FINISH SCHEDULE
- 11. CERAMIC WALL TILE CT-1, REFER TO FINISH SCHEDULE
- 12. CERAMIC WALL TILE CT-3 OR CT-4, REFER TO FINISH SCHEDULE
- 13. CERAMIC WALL TILE CT-5-REFER TO FINISH SCHEDULE
- 14. EXISTING STRUCTURE ABOVE
- 15. STAINLESS STEEL GRAB BARS
- 16. CERAMIC TRIM (CT-6)-REFER TO F3/A401, TYPICAL
- 17. TOILET TISSUE DISPENSER
- 18. STAINLESS STEEL FRAMED MIRROR POLYCARBONATE SAFETY GLASS
- 19. DOOR-REFER TO DOOR SCHEDULE
- 20. DOUBLE TIER METAL LOCKERS
- 21. CURTAIN WALL WINDOW SYSTEM
- 22. WASH AND DRYER-REFER TO EQUIPMENT PLAN
- 23. HAND SOAP CONTAINER
- 24. CORNER GUARD-REFER TO FIN. SCHEDULE
- 25. PSYCHIATRIC HANDRAIL-REFER TO FIN. SCHEDULE (TYP.)
- 26. PSYCHIATRIC CRASH RAIL-REFER TO FIN. SCHEDULE (TYP.)
- 27. NURSE STATION CASEWORK
- 28. GYPSUM BOARD BULKHEAD
- 29. RECESSED PAPER TOWEL DISPENSER
- 30. SOLID SURFACE COUNTERTOP
- 31. PLASTIC LAMINATE ON PLYWOOD-REFER TO FINISH SCHEDULE
- 32. EXISTING EXPANSION JOINT
- 33. TACKBOARD/MARKERBOARD
- 34. WALL MOUNTED CLOCK
- 35. TABLE MOUNTED EXAM LIGHT-REFER TO ELEC. DRAWINGS
- 36. EXAM TABLE
- 37. SOLID WALL SURFACE MATERIAL-REFER TO FIN. SCHEDULE
- 38. SHOWER FIXTURE-REFER TO PLUMBING DRAWINGS
- 39. RECESSED SOAP DISPENSER
- 40. KEYPAD
- 41. CARD READER/KEYPAD
- 42. FIRE EXTINGUISHER CABINET
- 43. ELECTRIC WATER COOLER
- 44. ELECTRICAL RECEPTACLE-SEE ELEC. DRAWINGS
- 45. NURSE CALL DEVICE-SEE ELEC. DRAWINGS
- 46. DATA/VOICE RECEPTACLE-SEE ELEC. DRAWINGS
- 47. LIGHT SWITCH-SEE ELEC. DRAWINGS
- 48. END PANEL
- 49. OPEN AREA - NO GLAZING
- 50. STOREFRONT WINDOW
- 51. UNDER-COUNTER, 30" WIDE ACCESS PANEL
- 52. STAINLESS STEEL FRAMED SAFETY GLASS MIRROR COUNTERTOP
- 54. BRACKET SUPPORTING END OF COUNTERTOP. INSTALL BRACKET INSIDE RECESSED CABINET FOR SINK.

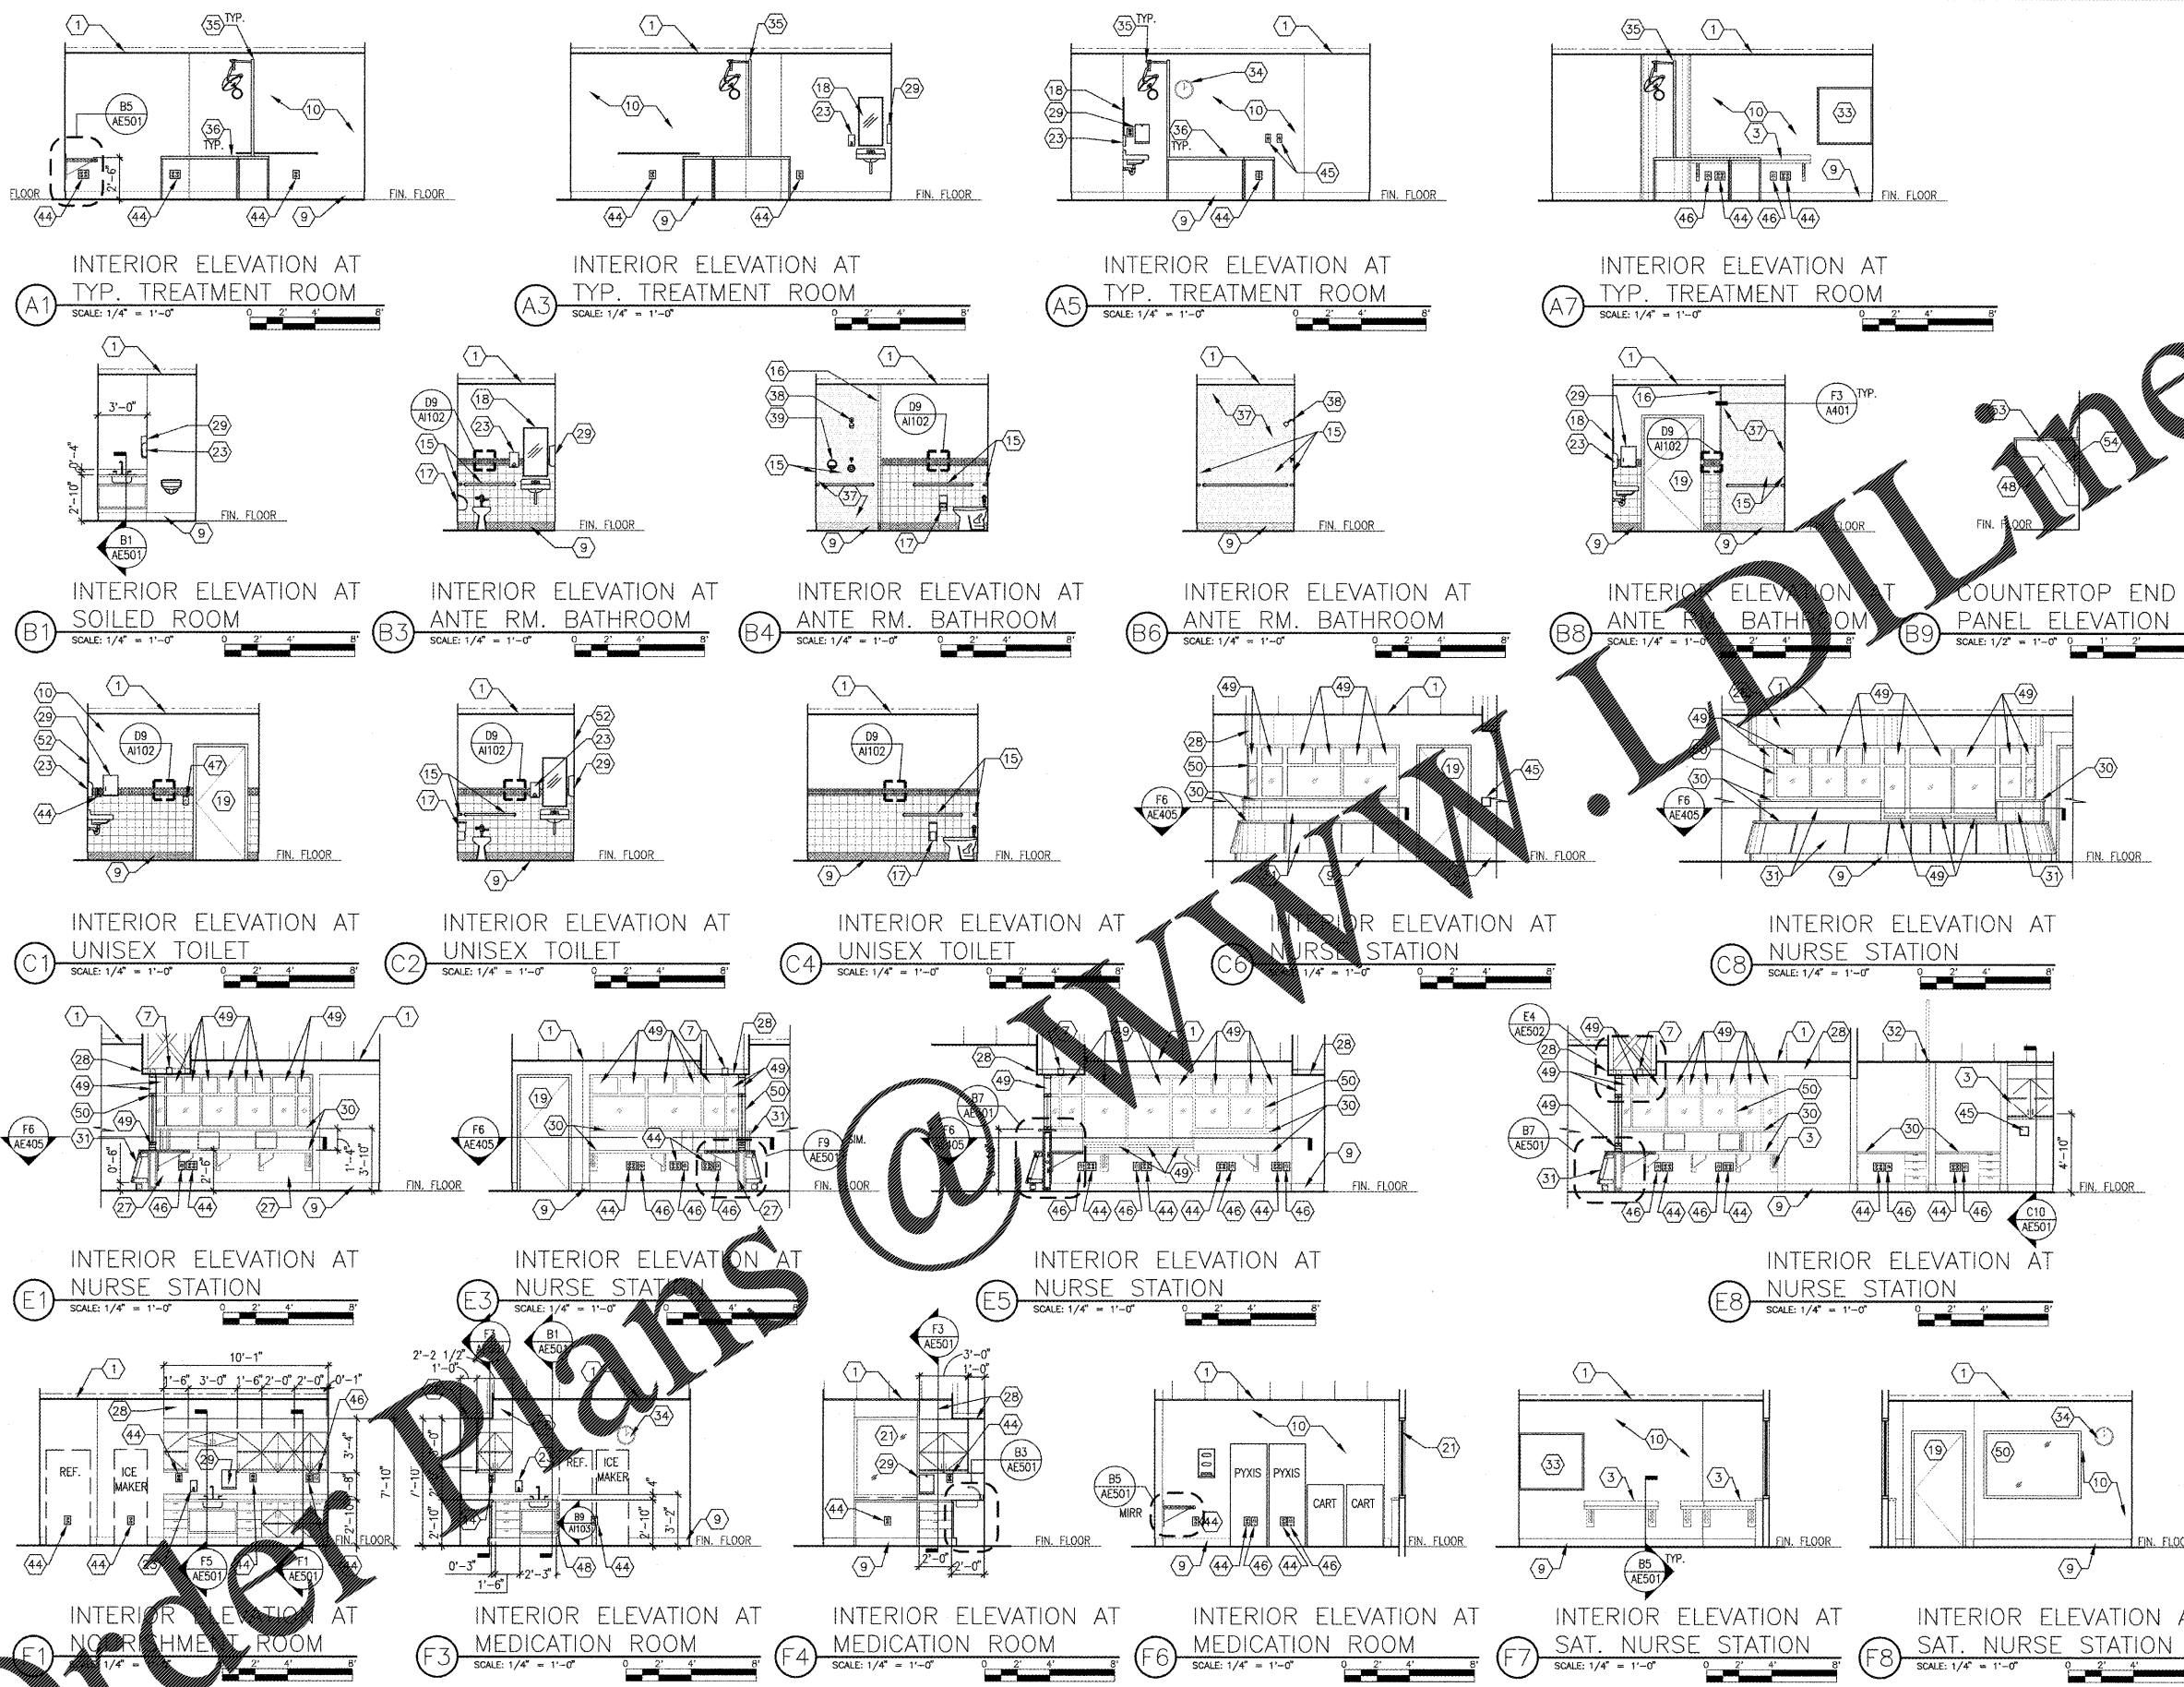

| REVISION | DESCRIPTION | DATE |
|----------|-------------|------|
| | | |
| | | |
| | | |

Department of Veterans Affairs
Charlie Norwood
 VA Medical Center
 1 Freedom Way
 Augusta, Ga. 30904

Architect/Engineer Address
Harrell, Saltrick & Hopper
 Design & Management Solutions for the Built Environment
 2016 TOWER POINT DRIVE CHARLOTTE, NC 28227
 WWW.HSHFPC.COM P 704.914.1300 F 704.351.0833
 COPYRIGHT © 2012 HARRELL, SALTRICK & HOPPER, PC
 HSH PROJECT # 12015

| Recommended Approvals: | |
|----------------------------|------------------------------------|
| 1. MEDICAL CENTER DIRECTOR | 6. OPERATIONS SERVICE LINE MANAGER |
| 2. ASSISTANT DIRECTOR | 7. INFECTION CONTROL MANAGER |
| 3. CHIEF OF STAFF | 8. SAFETY MANAGER |
| 4. ASSOC. DIRECTOR | 9. GENERAL ENGINEER |
| 5. SERVICE LINE MGRS. | 10. COR |

| Drawing Title | | Project Title | |
|-----------------------------------|--|------------------------------|-----------------|
| INTERIOR ARCHITECTURAL ELEVATIONS | | RENOVATE MENTAL HEALTH UNITS | |
| 100% CONSTRUCTION DOCUMENTS | | Drawn BWS III | Building Number |
| FULLY SPRINKLERED | | Checked | Reviewed |

| Date | Project Number | Drawing No. |
|-------------------|----------------|-------------|
| February 10, 2017 | 509-12-104 | AI103 |

