

GENERAL SHEET NOTES

- A. ALL VISUAL DEVICE CANDELA RATINGS TO BE 75cd UNLESS OTHERWISE NOTED.
- B. ALL CEILING MOUNTED SMOKE DETECTORS SHALL BE INSTALLED A MINIMUM OF 3 FEET AWAY FROM ANY HVAC SUPPLY AND RETURN DIFFUSERS.

SHEET KEYNOTES

- 1. PROVIDE INITIAL TYPE PULL STATION WITH KEY-OPERATED COVER.
- 2. DUCT DETECTOR AND FIRE ALARM RELAY TO OPERATE COMBINATION FIRE/SMOKE DAMPER. RELAY CAN BE A PART OF THE SMOKE DETECTOR BASE. DUCT DETECTOR MUST BE INSTALLED IN DUCT WITHIN 5' OF DAMPER.


COORDINATION DRAWINGS

SEE COVER SHEET FOR COORDINATION NOTES.




SYMBOLS LEGEND

- EXISTING WALL, DOOR, WINDOW, MILLWORK, FIXTURE OR OTHER FIXTURE OR ASSEMBLY TO REMAIN.
- NEW WALL
- SMOKE TIGHT WALL
- 2-HOUR FIRE/ SMOKE RATED WALL
- 1 HOUR FIRE RATED WALL
- 1 HOUR SMOKE BARRIER WALL
- NO PIPING OR DUCTWORK SHALL BE ROUTED THROUGH ELECTRICAL AND/OR DATA ROOMS.
- EXISTING CONCRETE COLUMN

KEY PLAN

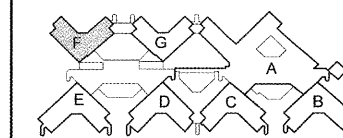

 
E1 "F" WING SECOND FLOOR OVERALL FIRE ALARM FLOOR PLAN  
SCALE: 1/8" = 1'-0"

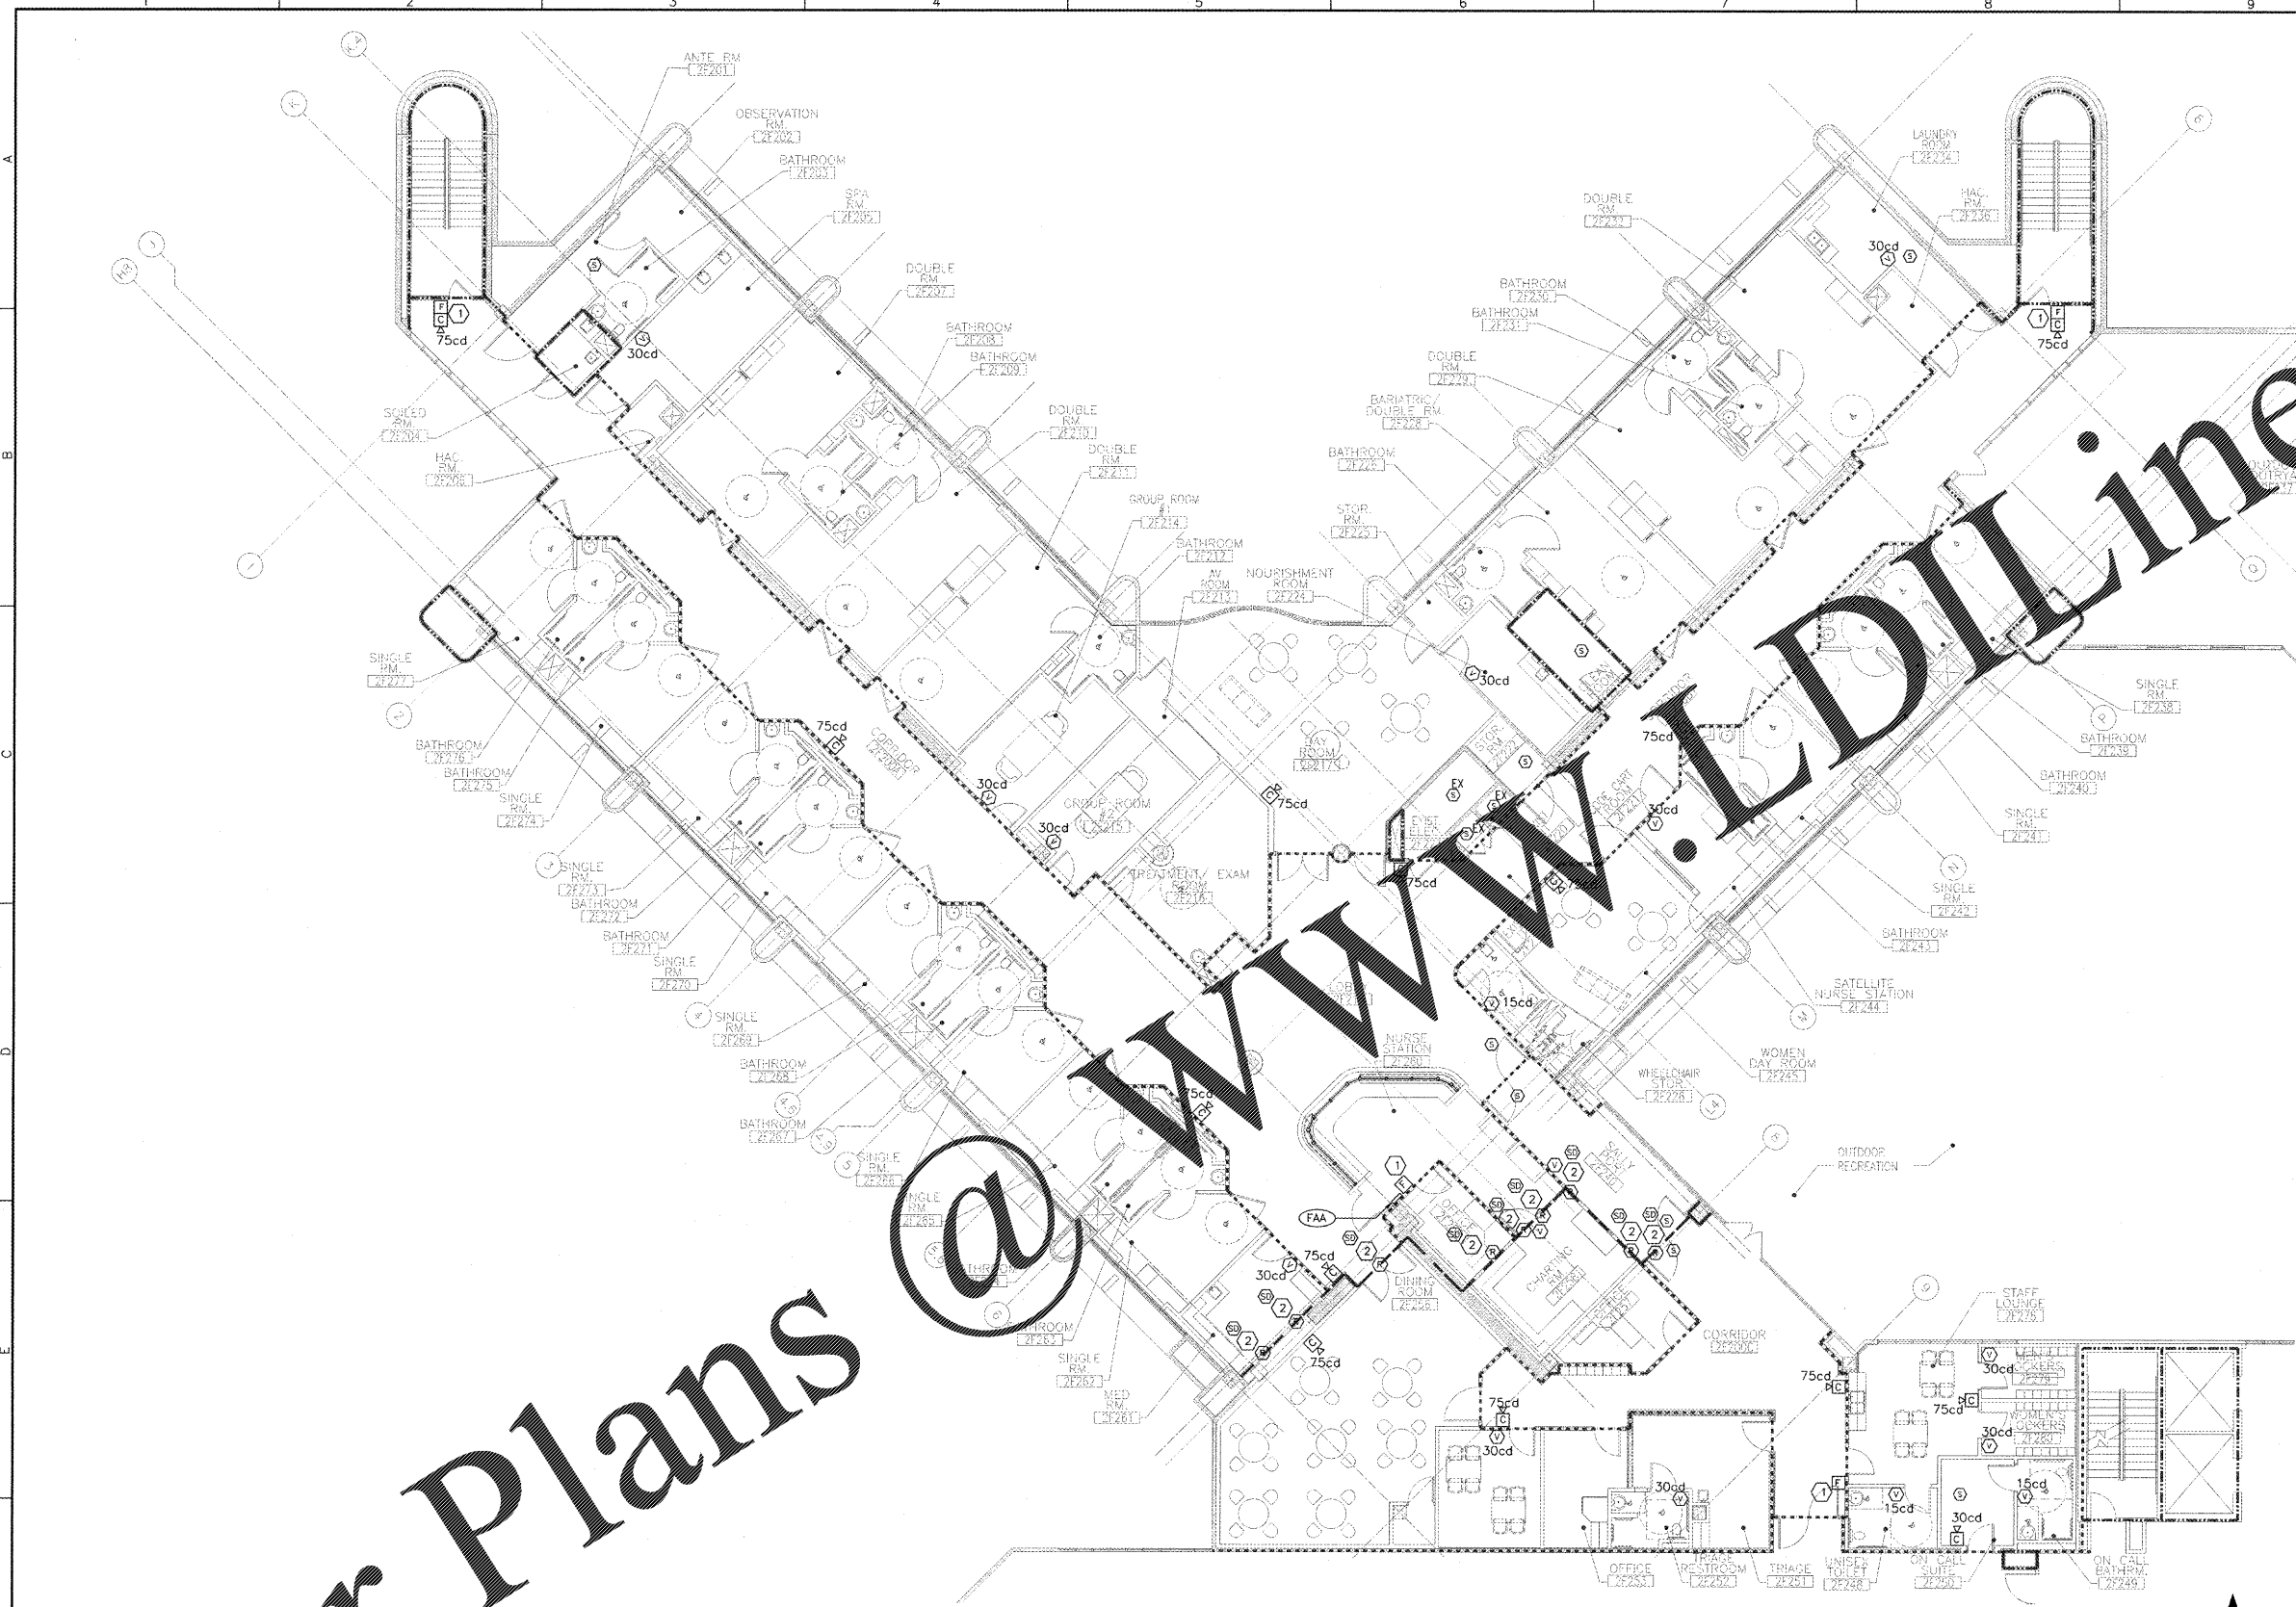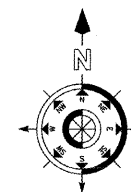

three inches = one foot  
 one and one half inches = one foot  
 one inch = one foot  
 three quarters inch = one foot  
 one half inch = one foot  
 one eighth inch = one foot  
 one quarter inch = one foot  
 one eighth inch = one foot

NO.	REVISION DESCRIPTION	DATE

**Department of Veterans Affairs**  
 Charlie Norwood  
 VA Medical Center  
 1 Freedom Way  
 Augusta, Ga. 30904

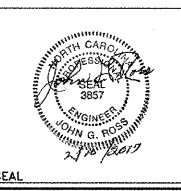

Architect/Engineer Address  
**Harrell, Saltrick & Hopper**  
 Design & Management Solutions for the Built Environment  
 2015 TOMMY HORN DRIVE  
 CHARLOTTE, NC 28227  
 WWW.HSHPC.COM  
 P 704.321.1320  
 F 704.321.0833  
 COPYRIGHT © 2012 HARRELL, SALTRICK & HOPPER, PC  
 HIGH PROJECT # 12015

Recommended Approvals:	
1. MEDICAL CENTER DIRECTOR	6. OPERATIONS SERVICE LINE MANAGER
2. ASSISTANT DIRECTOR	7. INFECTION CONTROL MANAGER
3. CHIEF OF STAFF	8. SAFETY MANAGER
4. ASSOC. DIRECTOR	9. GENERAL ENGINEER
5. SERVICE LINE MGRS.	10. COR

Drawing Title	"F" WING OVERALL FIRE ALARM FLOOR PLAN
100% CONSTRUCTION DOCUMENTS	FULLY SPRINKLERED

Project Title	RENOVATE MENTAL HEALTH UNITS
Drawn	Building Number
Checked	Reviewed
AutoCAD File Name	Const. Contract No.

Date	February 10, 2017
Project Number	509-12-104
DRAWING No.	FA101

