



Project Location:
Soft Surroundings
BILTMORE VILLAGE
 10 BROOK STREET
 SPACE #160
 ASHEVILLE, TN 28803
 4,740 SQUARE FEET

DRAWINGS ISSUED FOR:
 programming
 schematic des.
 design dev.
 bidding
 permits/11 review 04-06-18
 construction


REVISIONS: 04-20-18

Prj. no. 8-218-030
 Drawn RM - GV
 Checked KR - GV
 Approved KN

Do not scale this print. Use figured dimensions only.

Drawing title:
LO-VOLTAGE CEILING PLAN

Sheet no.
A-2.4

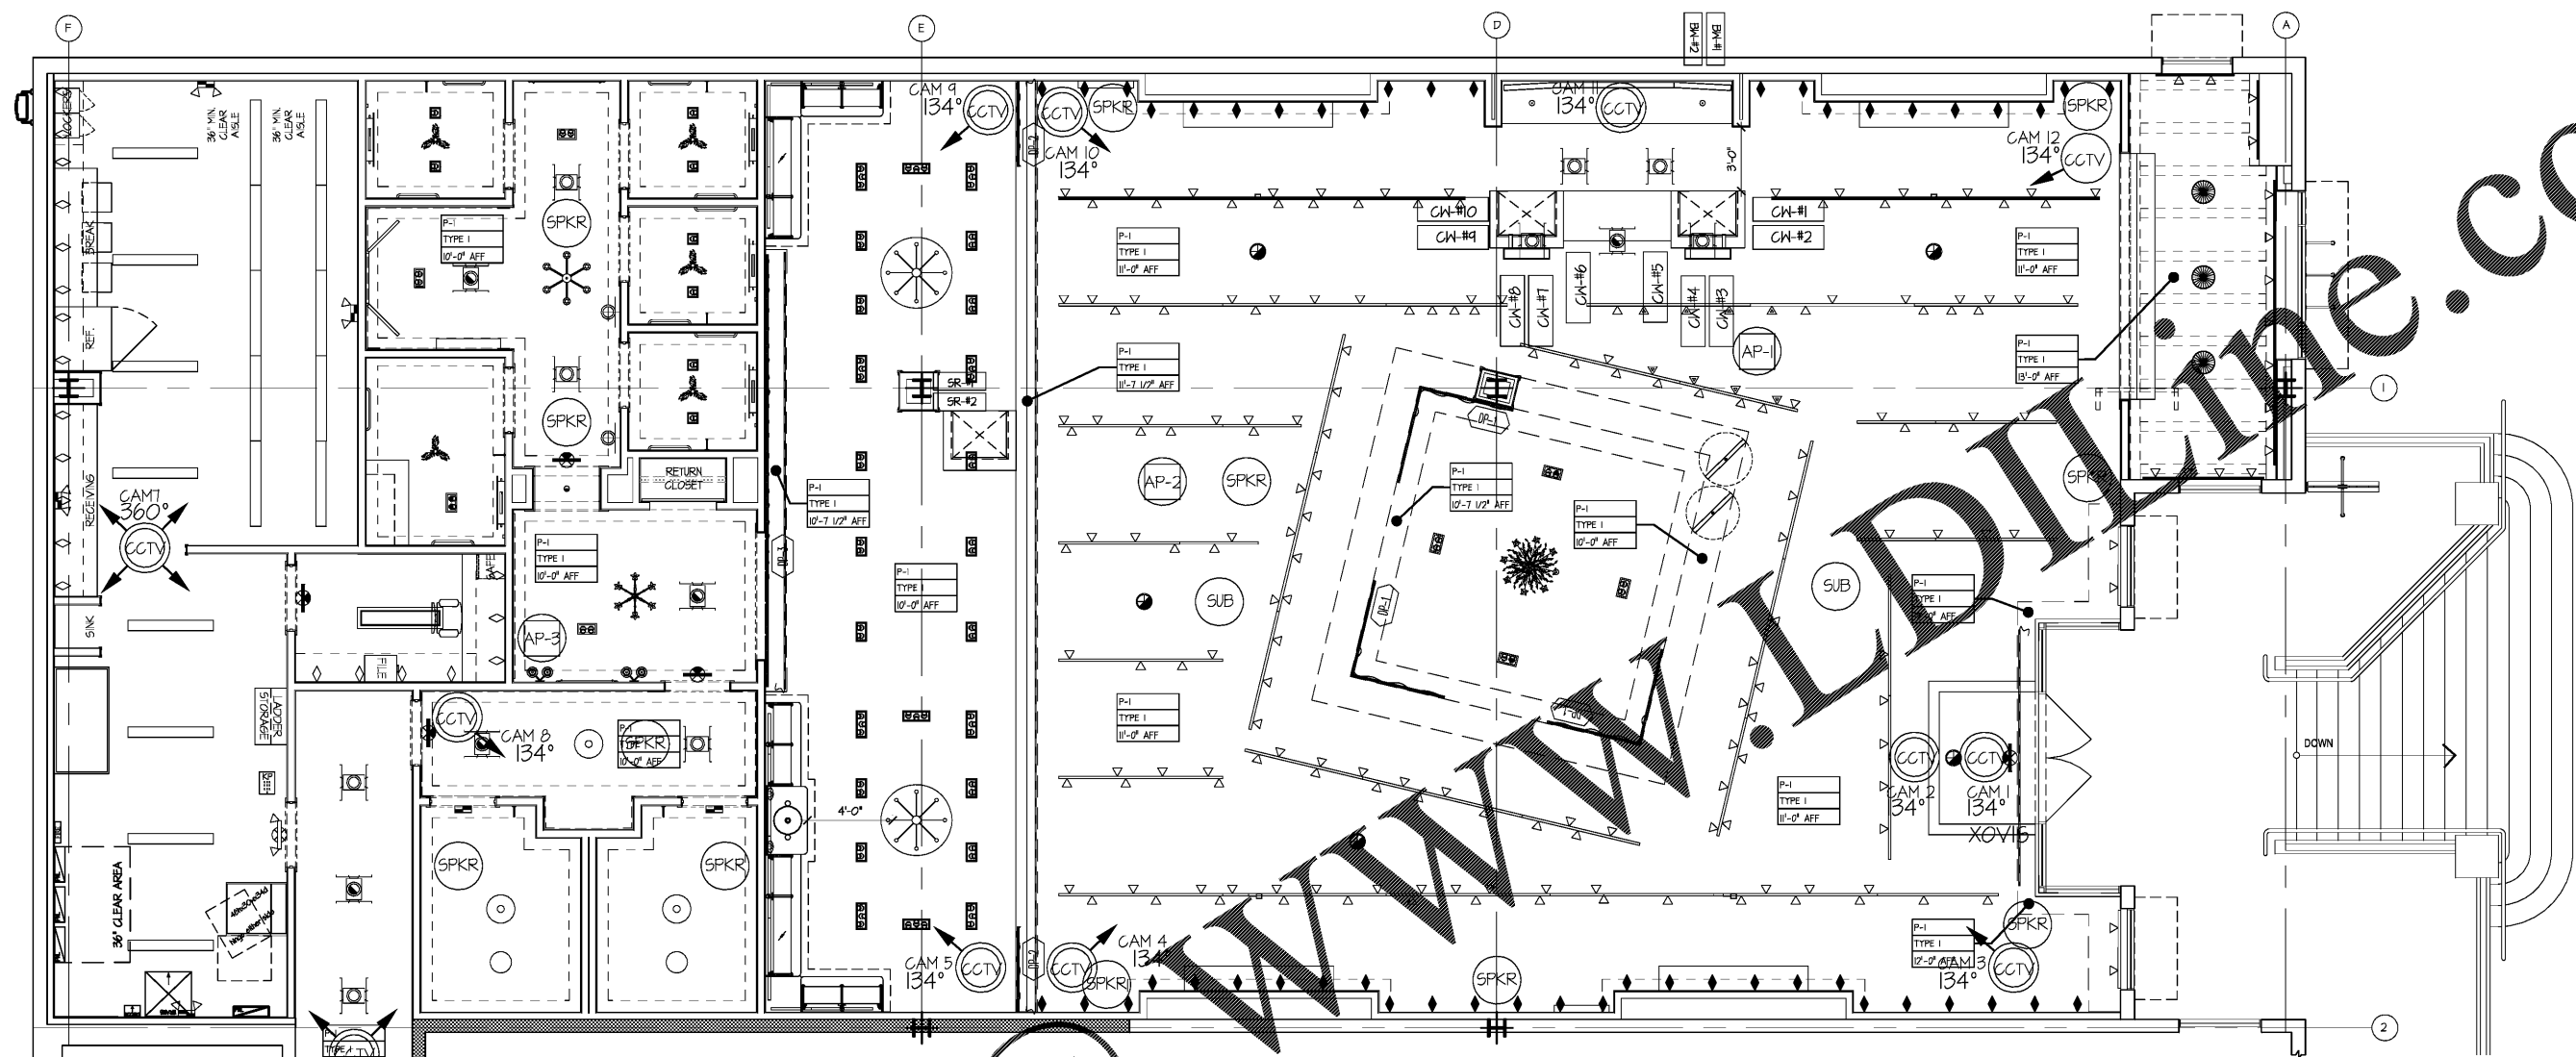

LOW VOLTAGE FLOOR PLAN
 SCALE: 1/4" = 1'-0"
 NORTH

LOW VOLTAGE WIRING ASSISTANCE SYMBOLS/NOTATIONS/ FOR VENDORS

WALL MOUNTED KEY PAD DATA BAI ALARM SYSTEM DATA CONNECTION
 MD MOTION DETECTOR FRONT AND BACK DOOR

NOTE THAT SALES AREA MOTION DETECTOR IS NOT INDICATED AND THAT PLACEMENT WILL BE DETERMINED AT THE TIME OF INSTALLATION.

LOW VOLTAGE WIRING ASSISTANCE SYMBOLS/NOTATIONS/ FOR VENDORS

SPKR SPEAKERS CEILING MOUNTED-
 KP SECURITY KEYPAD TO ALARM
 CCTV CLOSED CIRCUIT TELEVISION CAMERA W/ NO. LOCATION AND ROTATION.
 AP-1 WIRELESS ACCESS POINT TYPICAL INDICATION


SEE MOOD MEDIA LAYOUT FOR SPEAKER LOCATIONS. ALL SPEAKERS ARE CEILING MOUNTED WITH THE PERIMETER SATELLITES BEING INSTALLED ON BRACKETS AND THE SPEAKERS IN THE MIDDLE BEING FLUSH MOUNTED INTO THE CEILING.

LOW VOLTAGE WIRING ASSISTANCE SYMBOLS/NOTATIONS/ FOR VENDORS

DATA OUTLETS AT MANAGER OFFICE/LEDGE (5)TOTAL		DATA OUTLETS AT SHIPPING/RECEIVING LEDGE (4) TOTAL	
MOR1	MOR4	SR-#1	SR-#3
MOR2	MOR5	SR-#2	SR-#4
MOR3			
DATA OUTLETS AT CASH WRAP COUNTER (2)TOTAL #1 & #2 WHEN MOBILE CASH WRAP IS NOT ADJACENT TO FIXED CASH WRAP		DATA OUTLETS AT BACK WRAP (2)TOTAL	
CH-#1	CH-#5	CH-#9	BH-#1
CH-#2	CH-#6	CH-#10	BH-#2
CH-#3	CH-#7	CH-#11	
CH-#4	CH-#8	CH-#12	

REFLECTED CEILING KEY NOTES

HVAC DIFFUSERS ARE SHOWN ON MECHANICAL PLANS FOR PLACEMENT AND SPECIFICATION.

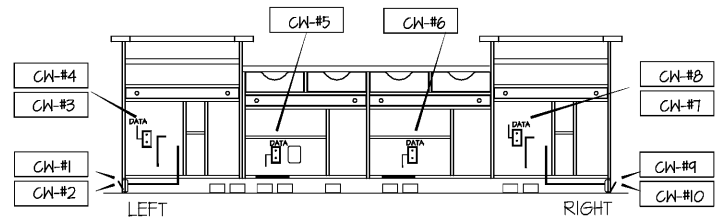

ASSOCIATE SIDE OF CASH WRAP ELEVATION
 FEB-3-2017MPPM

Order Plans @