


Order Plans @

FABRICATED HOLLOW "BATTENS" MOUNTED TO CEILING SURFACE. PROVIDED AND INSTALLED BY TENANTS FIXTURE CONTRACTOR.

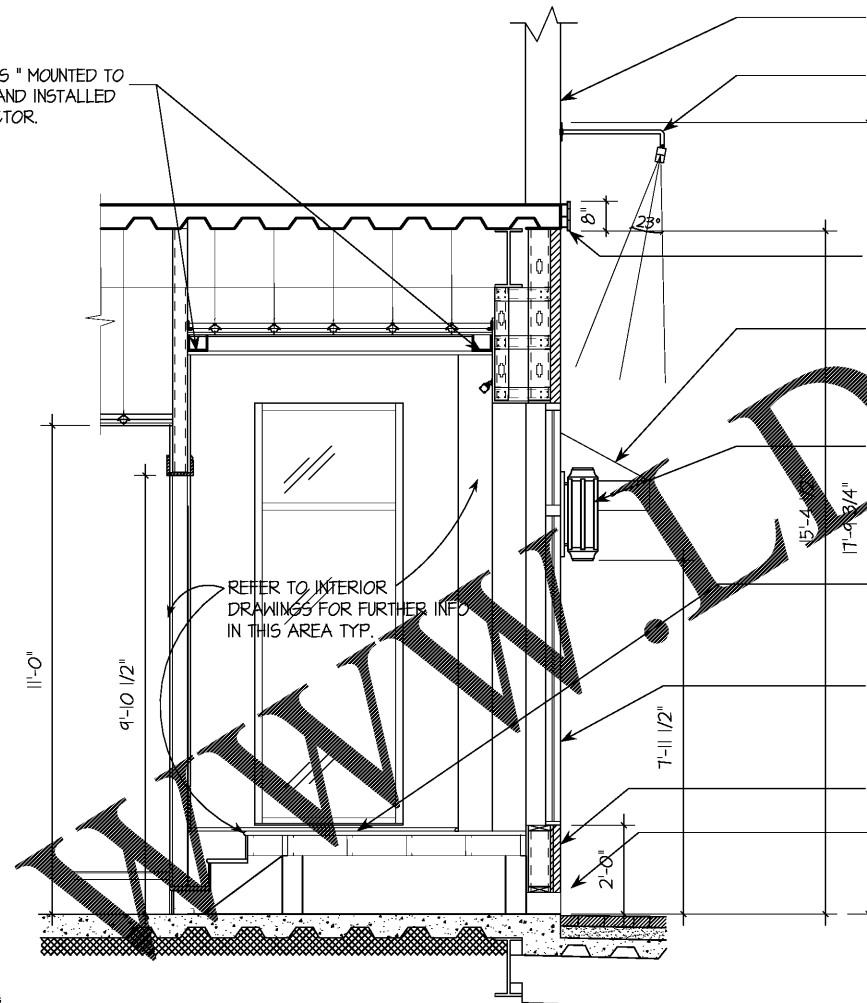

EXISTING FASCIA TO REMAIN.

NEW DARK BRONZE STOREFRONT LIGHTING. PROVIDE ACCESSIBILITY AT EXISTING LOCATION OF PREVIOUS FIXTURES. SEE LIGHTING PLAN AND SCHEDULE FOR SPEC. G.C TO VERIFY IN FIELD.

8" HIGH LED LETTERS WITH BRONZE FINISH ON FACE AND HALF SIZE FOR HALO LIGHT EFFECT.

NEW FABRIC AWNINGS ON NEW FRAME. WEATHER TYTE 839 44# WT. TINT SAPPHIRE SLATE BLUE

EXISTING EXTERIOR LANTERN SPOONCE LIGHTS TO REMAIN.

NEW DISPLAY PLATFORM AND STEPS. REFER TO ENLARGED DETAILS AND SECTIONS FOR FURTHER INFO.

EXISTING STOREFRONT GLAZING SYSTEM TO REMAIN.

EXISTING EXTERIOR FINISH TO REMAIN.

NEW DISPLAY PLATFORM. REFER TO ENLARGED DETAILS AND SECTIONS.

1  
A-4.1 STOREFRONT DISPLAY WINDOW SECTION  
SCALE: 1/2" = 1'-0"

GENERAL STOREFRONT SCOPE OF WORK:  
EXISTING EXTERIOR STOREFRONT TO REMAIN EXCEPT FOR NEW ENTRY DOORS, AWNINGS AND SIGNS. ALL MENTIONED NEW ITEMS ALREADY REVIEWED AND APPROVED BY HRC COMMISSION

FULL SIGN SHOP DRAWINGS SHALL BE SUBMITTED BY SIGN CONTRACTOR FOR REVIEW AND APPROVAL. TYP.

KEN NISCH, AIA

1110 Inks Road  
Suite 200  
Southfield, MI 48034 USA  
248 355 0890  
248 355 0895 Fax

Copyright © 2018  
KEN NISCH, AIA  
All rights reserved

Certification:  
I HEREBY CERTIFY THAT THESE PLANS WERE PREPARED BY ME AND OF UNDER MY SUPERVISION AND TO THE BEST OF MY KNOWLEDGE THEY CONFORM TO CODES AND ORDINANCES OF THE MUNICIPALITY



ARCHITECTURAL REG: 6090  
EXP. DATE: JUNE 30, 2018  
DATE SIGNED: APRIL 06, 2018

Consultants:  
RETAIL DESIGN CONSULTANT



JGA Prj #: 1-218-082

Project Location:  
Soft Surroundings  
BILTMORE VILLAGE  
10 BROOK STREET  
SPACE #160  
ASHEVILLE, TN 28803  
4,740 SQUARE FEET

DRAWINGS ISSUED FOR:  
 programming  
 schematic des.  
 design dev.  
 bidding  
 permits/LL review 04-06-18  
 construction

REVISIONS:

Prj. no. 8-218-030  
Drawn RM - GV  
Checked KR - GV  
Approved KN

Do not scale this print. Use figured dimensions only.

Drawing title:  
STOREFRONT SECTION

Sheet no.  
A-4.3