



PARTNERS in Architecture, PLC
 65 MARKET STREET
 MOUNT CLEMENS, MI 48043
 P 586 489 3000
 F 586 489 3007

Michael A. Malone, Architect
 - Georgia Registration No. 18474890

Statement of Intellectual Property:
 The ideas, concepts, drawings and thoughts conveyed herein are the intellectual property of PARTNERS in Architecture, PLC, 65 Market Street, Mount Clemens, MI, 48043 (P 586 489 3000). This set of drawings, in whole or in part, may not be reproduced, without the written consent of PARTNERS in Architecture, PLC. This information is protected under U.S. Copyright Law, all rights reserved.

© Copyright 2018

PROFESSIONAL SEAL


REFLECTED CEILING PLAN - GENERAL NOTES

- A. REFER TO FLOOR PLANS FOR ROOM DIMENSIONS.
- B. REFER TO ELECTRICAL FOR LIGHT FIXTURE TYPES AND SPECIFICATIONS.
- C. REFER TO MECHANICAL FOR DIFFUSERS, REGISTERS, AND RETURNS.
- D. ALL LIGHT FIXTURES ARE TO BE CENTERED WITHIN CEILING TILE AND 6" P.SOFFIT WHERE APPLICABLE U.O.N.
- E. CEILING GRID IS TO BE CENTERED IN ROOM U.O.N.
- F. PAINT ALL EXPOSED STRUCT., MECH., AND ELEC.
- G. COORD FIXT. LOCATIONS WITH FINAL EQUIPMENT LAYOUT.

REFLECTED CEILING PLAN - KEY PLAN

- 1 GYP BD ON 3 5/8" METAL STUD CONSTRUCTION AT 16" O.C. SECURE TO STRUCTURE ABOVE AT 48" O.C. MAX EACH WAY.
- 2 PREP & PAINT EXPOSED STEEL ROOF STRUCTURE AND DECK (TYPICAL AT ALL EXPOSED SURFACE CONDITIONS).
- 3 2' X 4' LAY-IN LIGHT FIXTURE IN GRID.
- 4 SUSPENDED LIGHT FIXTURE.
- 5 RECESSED ROUND LIGHT FIXTURE.
- 6 EXIT LIGHT - CEILING MOUNTED - SHOWN FOR COORDINATION ONLY, REFER TO ELECTRICAL.
- 7 EXIT LIGHT - WALL MOUNTED - SHOWN FOR COORDINATION ONLY, REFER TO ELECTRICAL.
- 8 SUPPLY AIR DIFFUSER (MECHANICAL).
- 9 RETURN AIR GRILLE (MECHANICAL).

KEY PLAN

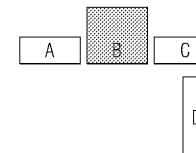

OWNER

Suwanee Grocery, LLC

8110 N. Saint Louis Avenue
 Skokie, IL 60076

PROJECT NAME

Suwanee Grocery, LLC
 Building-B Build-Out

3230 Caliber Street
 Suwanee, GA 30024

PROJECT NO.

16-177

ISSUES / REVISIONS

Bidding - Construction 05/01/18

DRAWN BY
 JEE

CHECKED BY
 FGM

APPROVED BY
 MAM

SHEET NAME

REFLECTED
 CEILING PLAN


SHEET NO.
 A4-01

Ceiling Symbols Legend

	5/8" GYP BD ON 3 5/8" METAL STUD CONSTRUCTION AT 16" O.C. SECURE TO STRUCTURE ABOVE AT 48" O.C. MAX EACH WAY.
	2' X 4' LAY-IN LIGHT FIXTURE IN GRID
	SUSPENDED LIGHT FIXTURE
	RECESSED ROUND LIGHT FIXTURE
	EXIT LIGHT - CEILING MOUNTED - SHOWN FOR COORDINATION ONLY, REFER TO ELECTRICAL.
	EXIT LIGHT - WALL MOUNTED - SHOWN FOR COORDINATION ONLY, REFER TO ELECTRICAL.
	SUPPLY AIR DIFFUSER (MECHANICAL)
	RETURN AIR GRILLE (MECHANICAL)



1 Reflected Ceiling Plan
 3/32" = 1'-0"

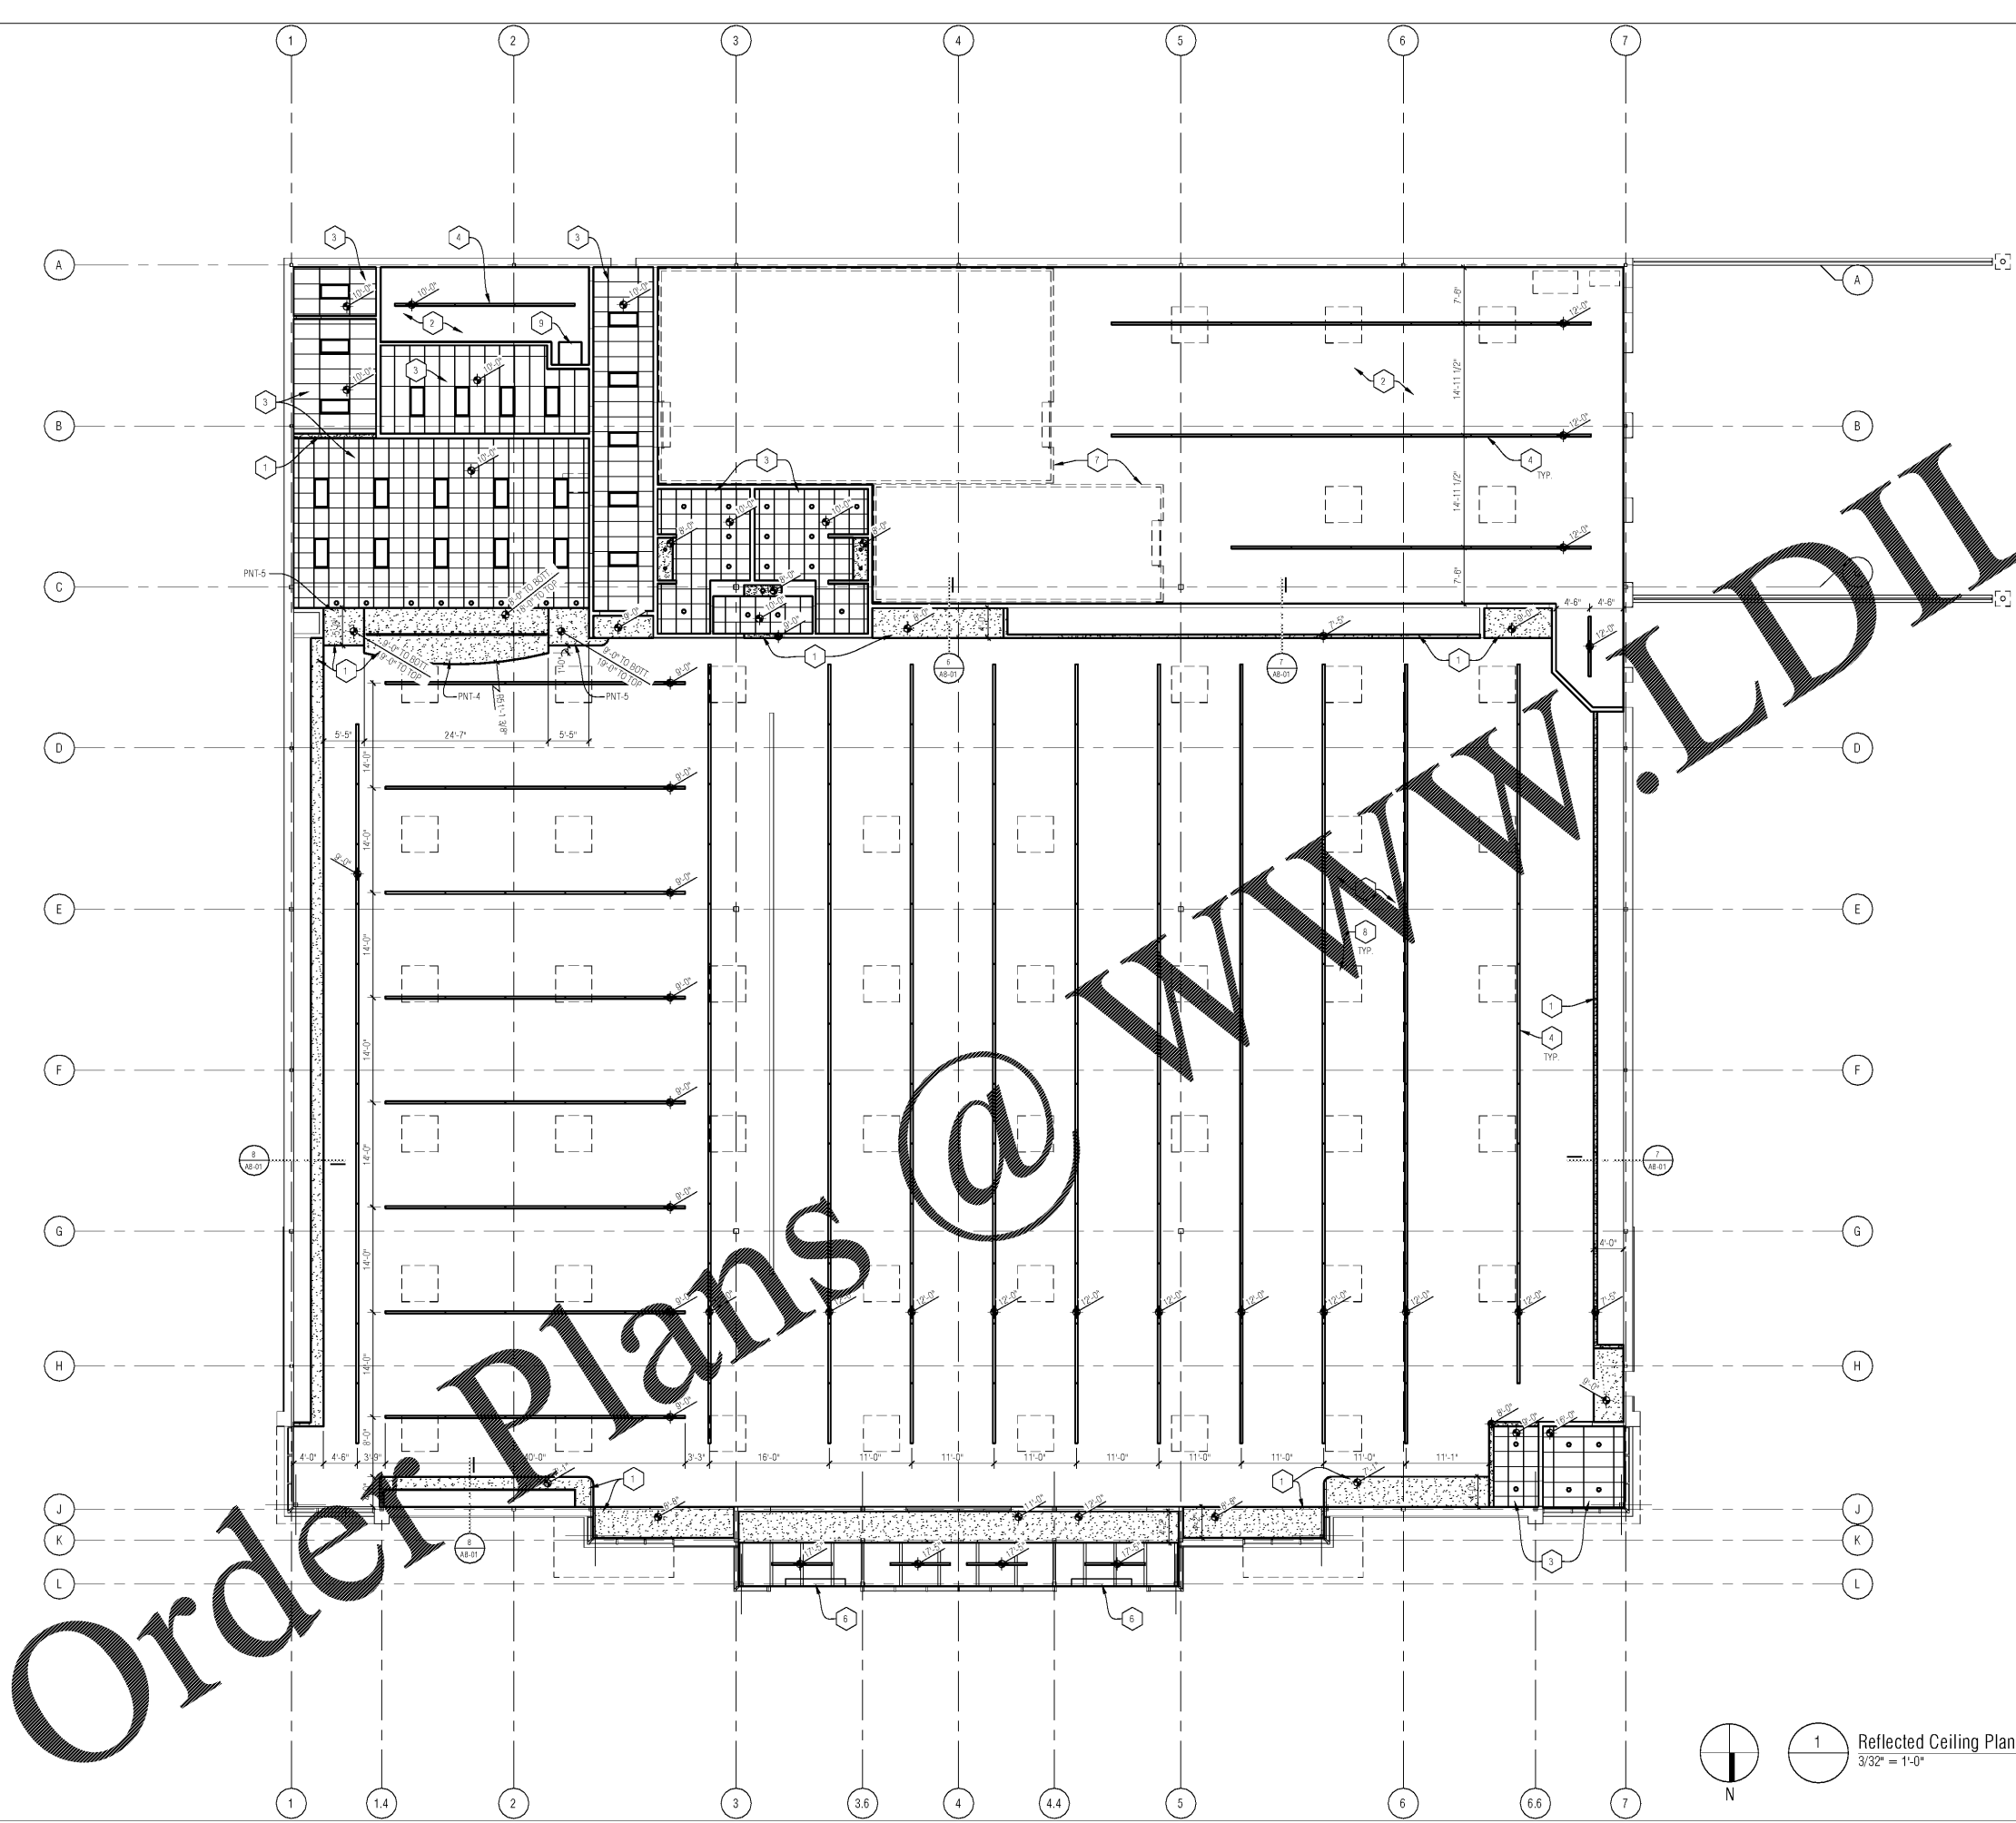

Order Plans @ www.LDILine.com